


- KEYNOTES**
- 1 PIPING W/ SHUT-OFF VALVE DN IN WALL OR CHASE TO FIXTURE (1), SIZE AS NOTED
 - 2 HOT WATER OR HOT WATER CIRCULATING UP IN WALL OR CHASE FROM FIXTURE TO ABOVE CEILING. ROUTE HOT WATER OR HOT WATER CIRCULATING TO WITHIN 24" OF FIXTURE TO WATER HEATER (SEE DETAIL)
 - 3 1-1/2" CW, 1-1/2" HW & 3/4" HWR TO WATER HEATER (SEE DETAIL)
 - 4 3/4" HWR TO RECIRCULATION PUMP (SEE DETAIL)
 - 5 1/2" VALVED HW TO GLASSWARE WASHER CONNECTION W/ WATER HAMMER ARRESTOR (SIOUX COOK MINI MASTER, SERIES 660, SIZE AA)
 - 6 1/2" CW TO TRAP PRIMER (TP-A) TO TP LINE B/F TO DRAIN

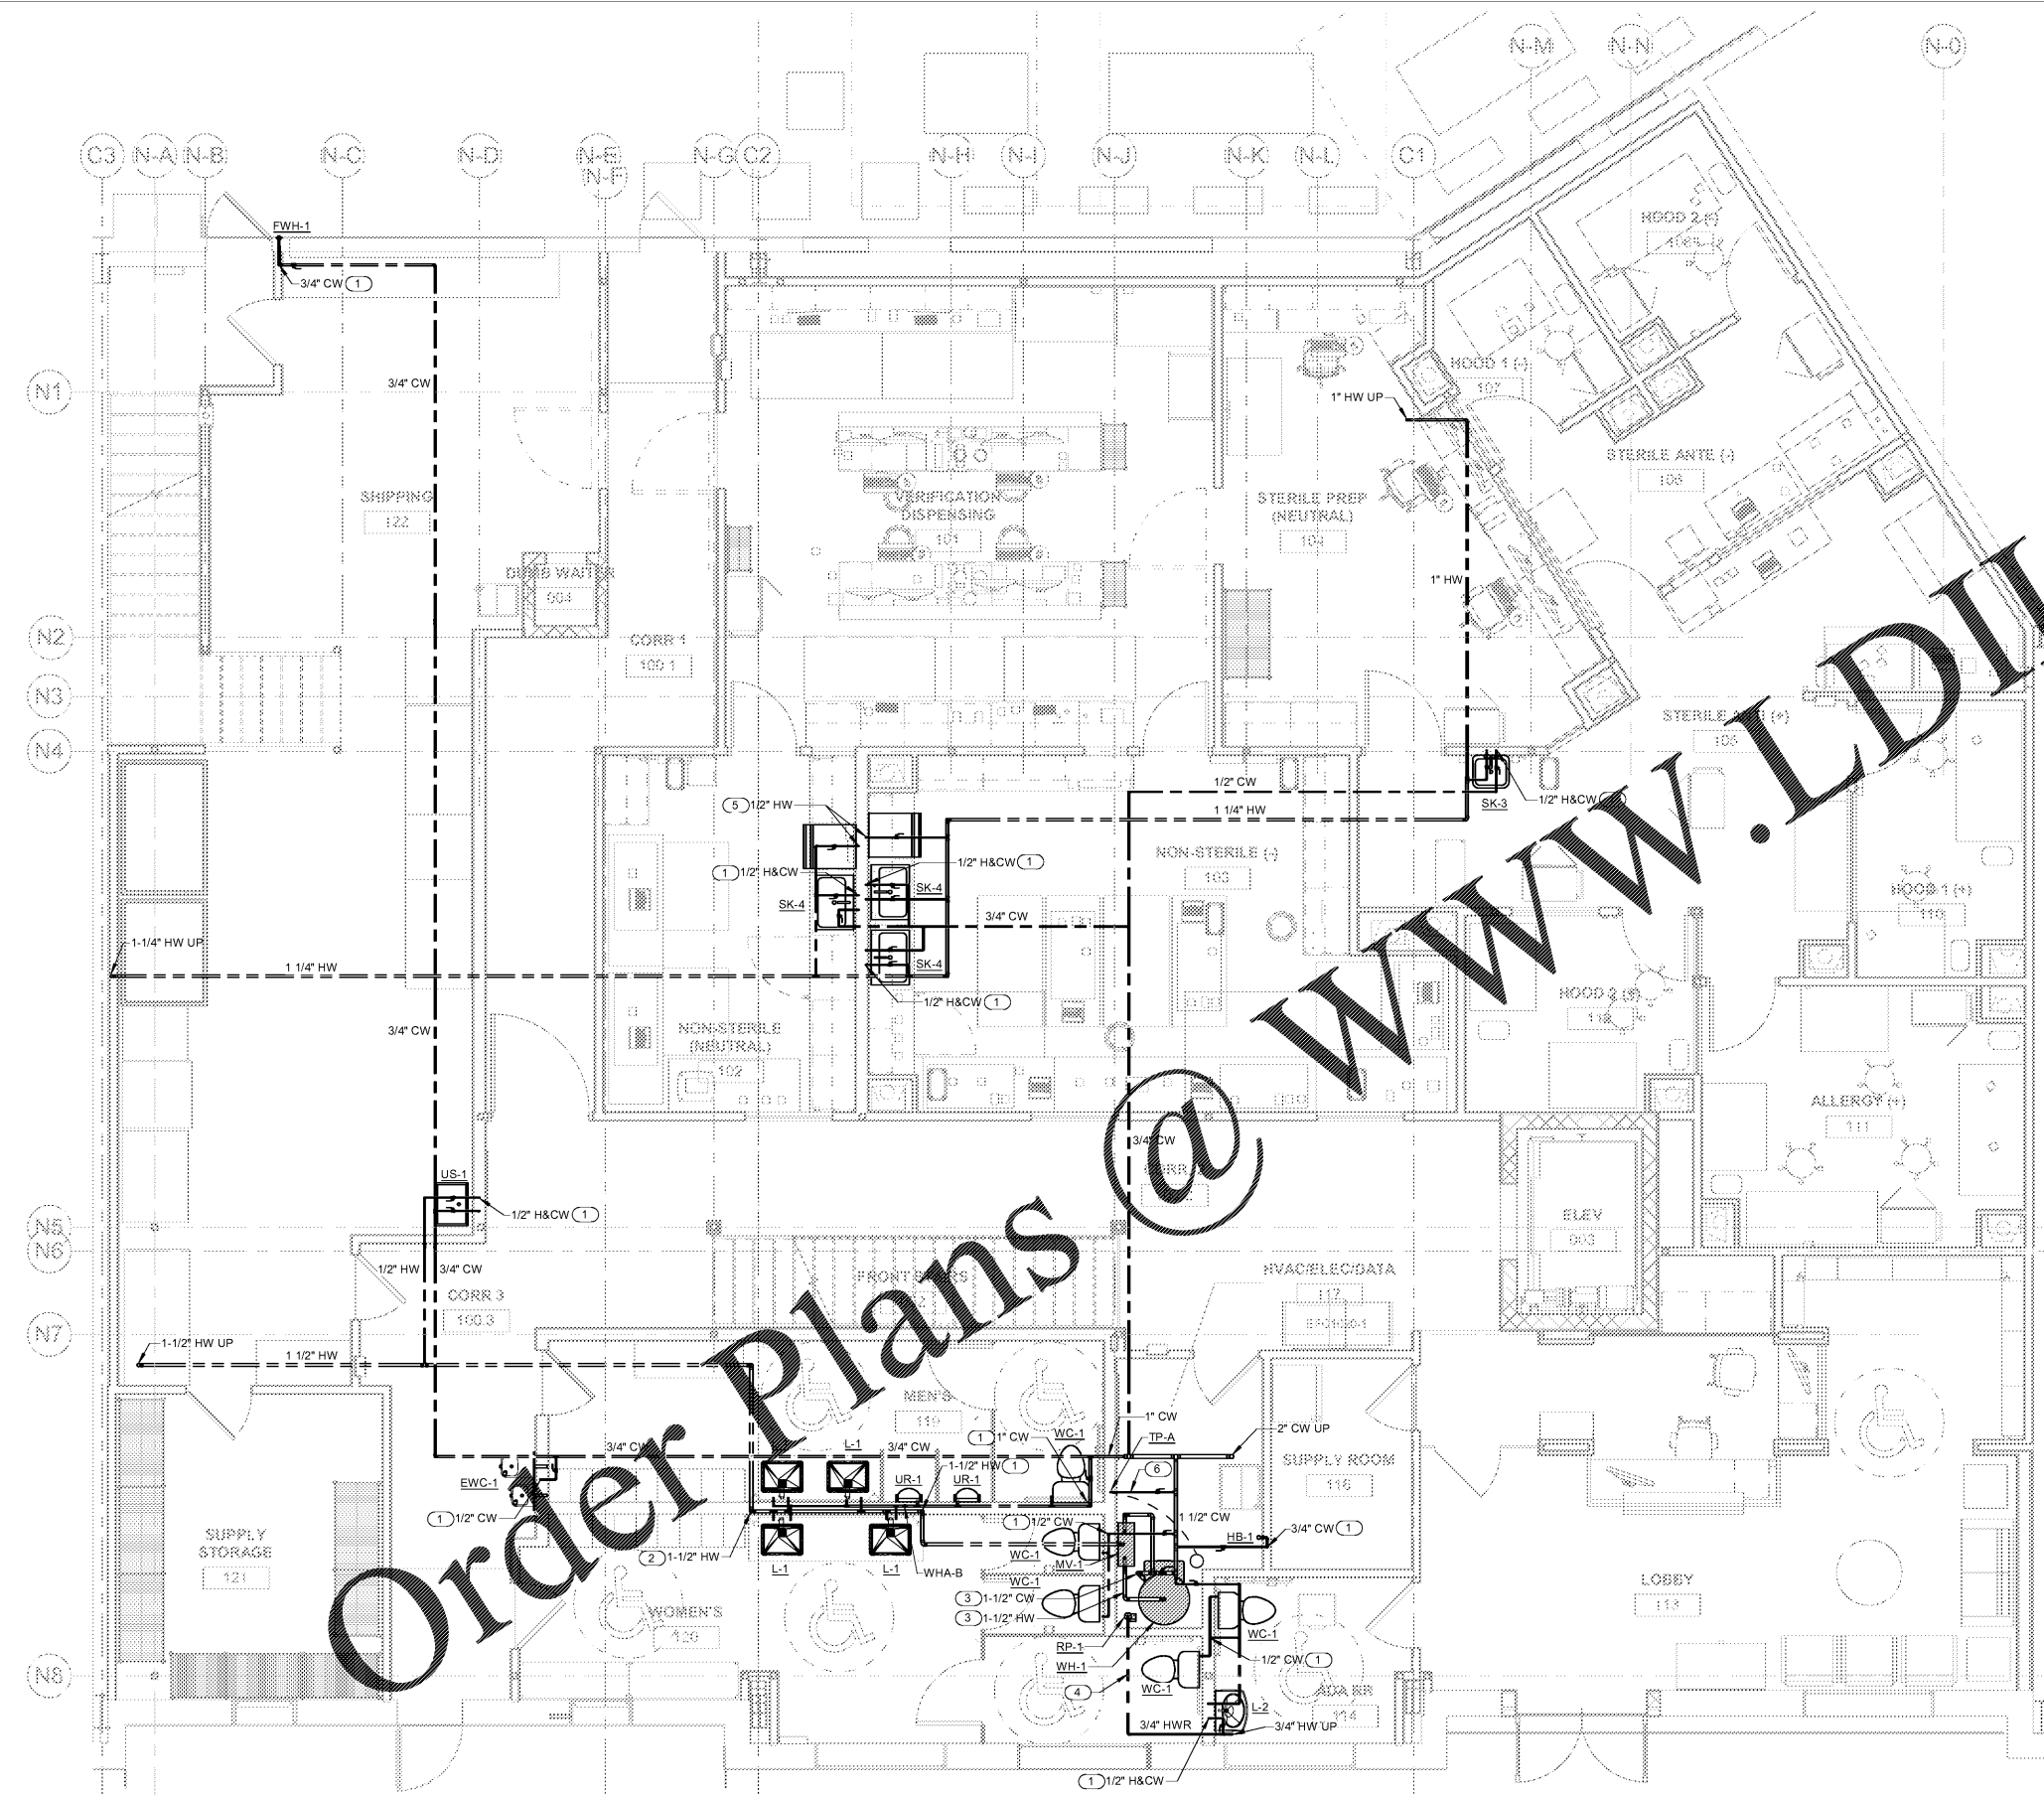

Order Plans @ www.LDILine.com

1 1ST FLOOR PLAN - SUPPLY
PI.1B 1/4" = 1'-0"



THIS DRAWING IS THE PROPERTY OF CROSSFIELDS, INC. AND ANY REPRODUCTION OR COPYING OF THIS DRAWING, IN WHOLE OR PART IS PROHIBITED WITH OUT WRITTEN PERMISSION.

INNOVATION
COMPOUNDING
DR. SHAWN HODGES
6095 PINE MOUNTAIN RD., SUITE 104
KENNESAW, GA 30152

REVISIONS:

NO.	DATE	DESCRIPTION

DRAWN BY: DS
CHECKED BY: MR
DATE: 09.24.19
PROJECT NUMBER: 17125-IC
SHEET NO:

PI.1B

ISSUED FOR PERMITTING