


- KEYNOTES**
- 1 TRAP PRIMER TP-L WITH 1/2" TP LINE B/F TO FD.
 - 2 EXTEND DRAIN HOSE FROM DW TO SINK TAILPIECE (OR DISPOSAL AS APPLICABLE) W/ AIR BREAK (SEE DETAIL).

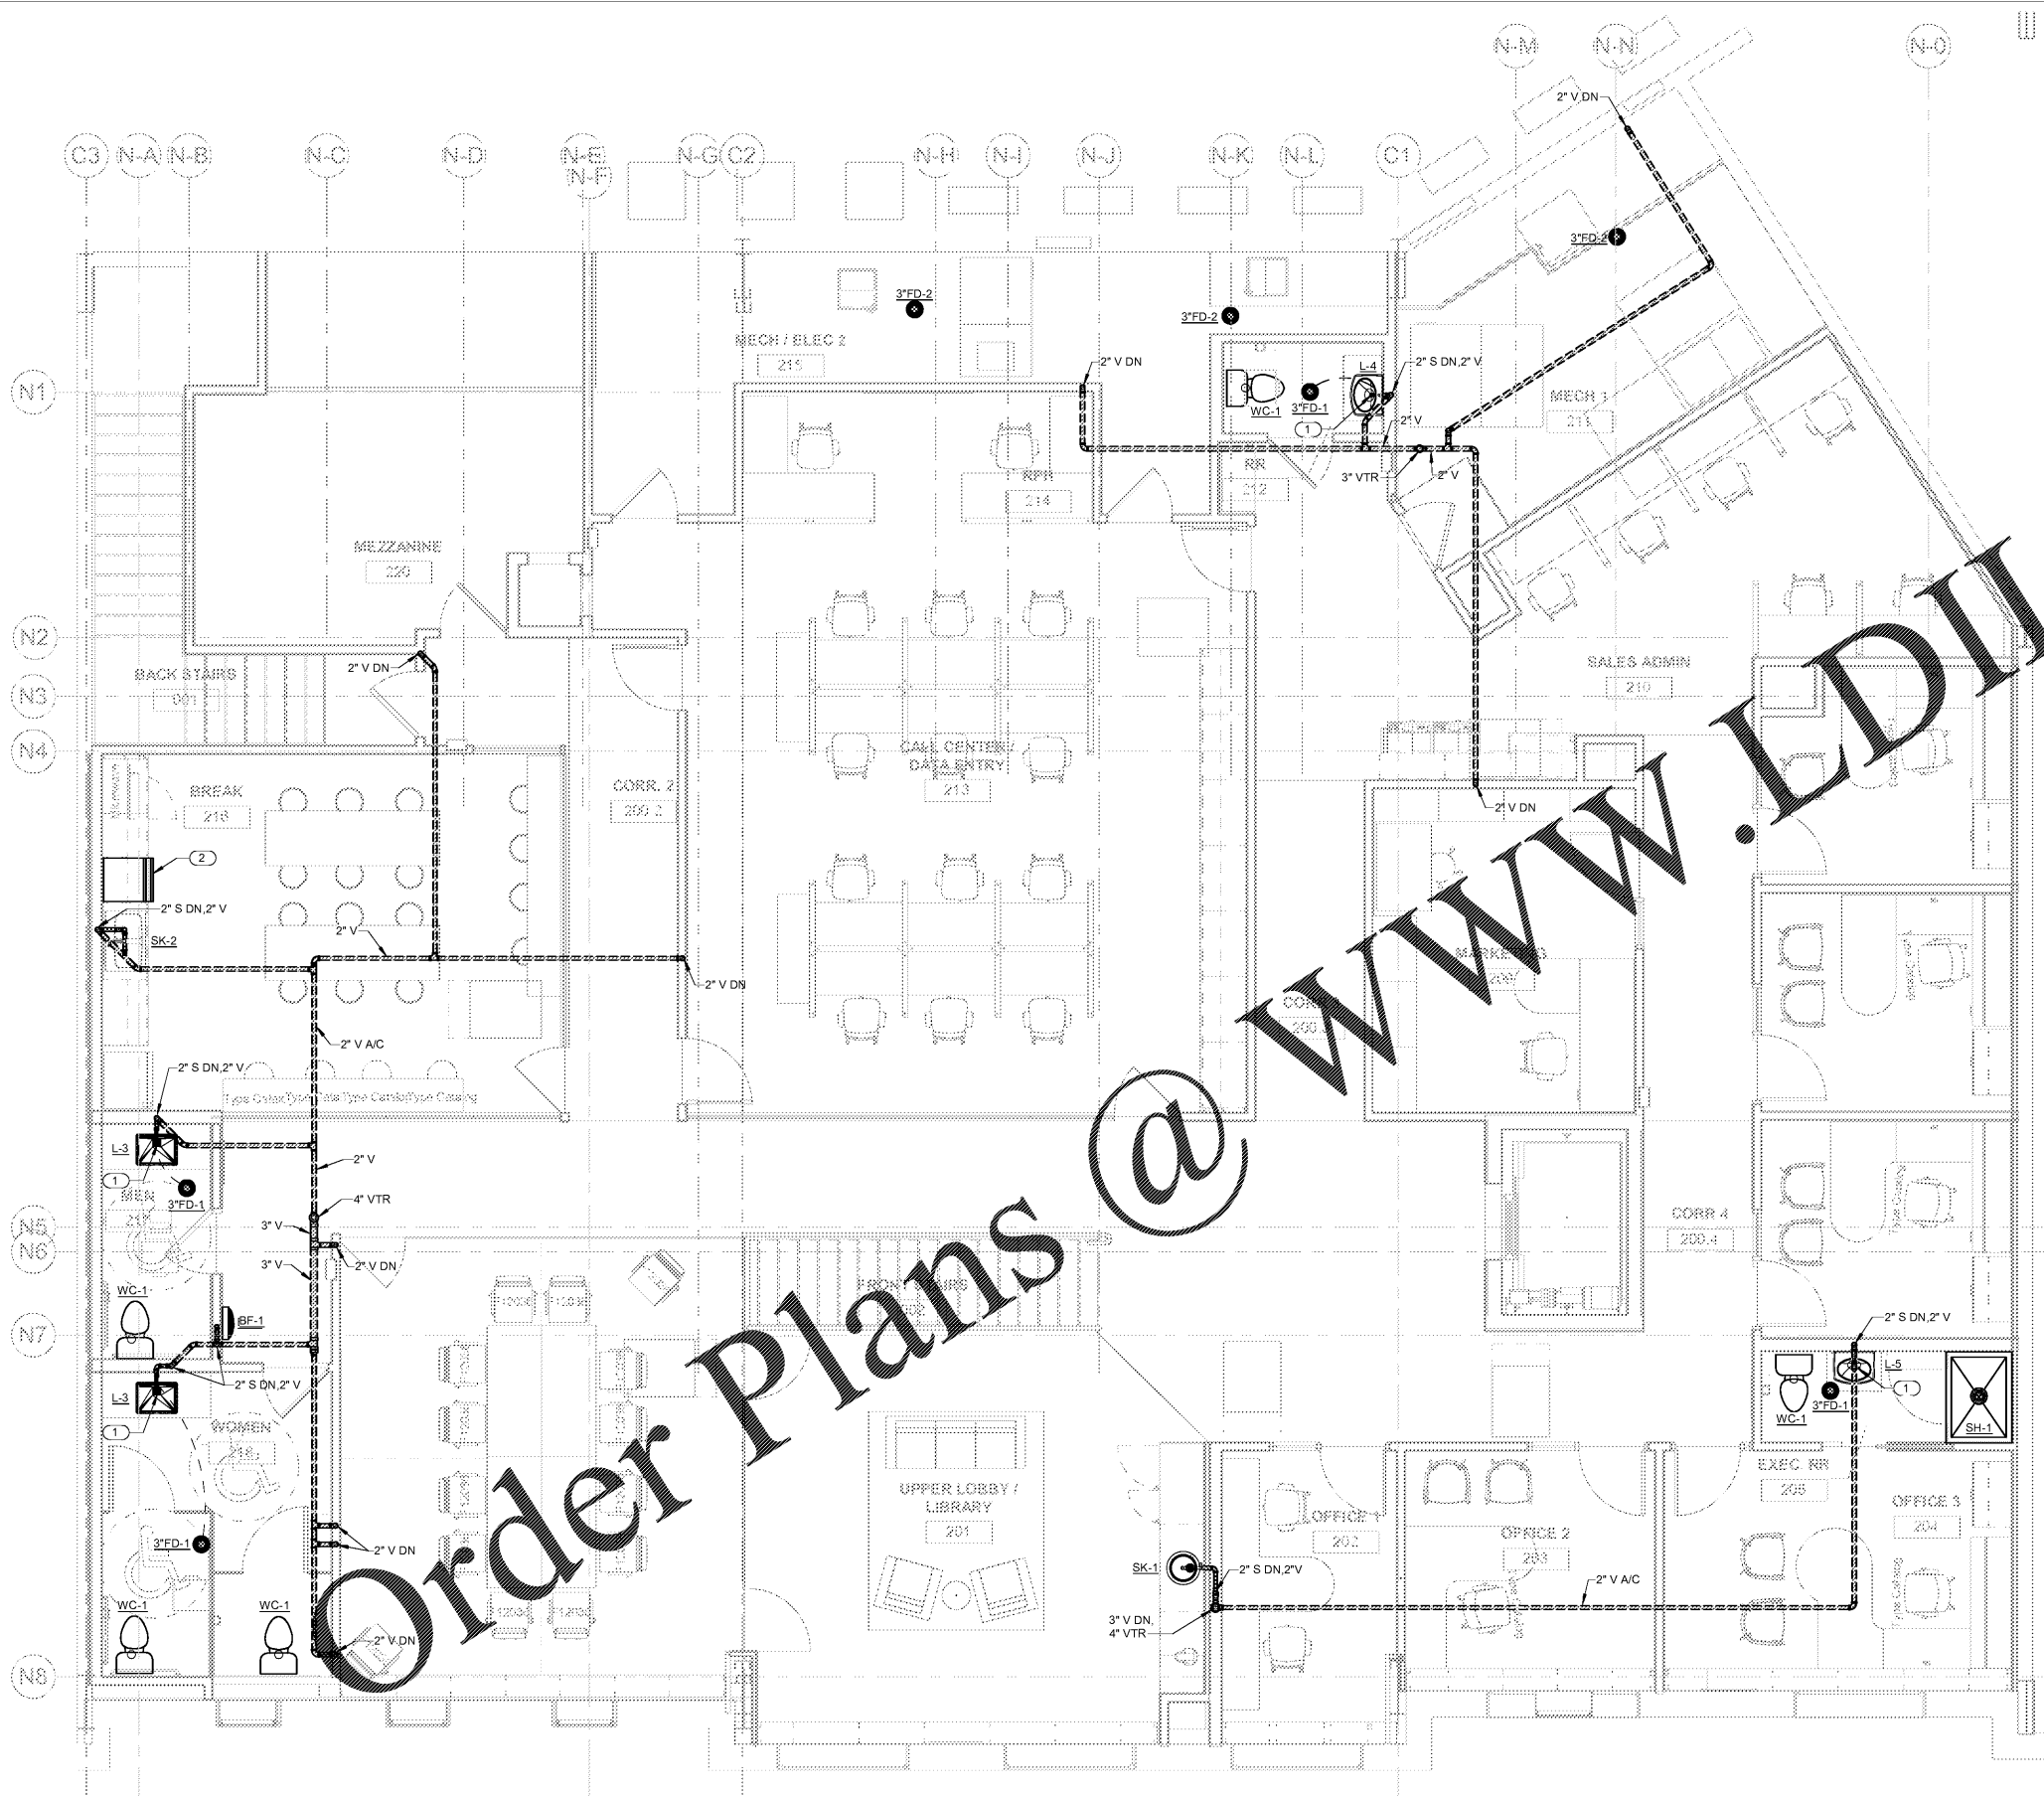

Order Plans @ www.LDILine.com



THIS DRAWING IS THE PROPERTY OF CROSSFIELDS, INC. AND ANY REPRODUCTION OR COPYING OF THIS DRAWING, IN WHOLE OR PART IS PROHIBITED WITHOUT WRITTEN PERMISSION.

**INNOVATION
COMPOUNDING
DR. SHAWN HODGES**
6095 PINE MOUNTAIN RD., SUITE 104
KENNESAW, GA 30152

REVISIONS:

NO.	DATE	DESCRIPTION

DRAWN BY: DS CHECKED BY: MR
DATE: 09.24.19
PROJECT NUMBER: 17125-IC
SHEET NO:

P1.2A

1 2ND FLOOR PLAN - WASTE & VENT
P1.2A 1/4" = 1'-0"

ISSUED FOR PERMITTING