


Order Plans @

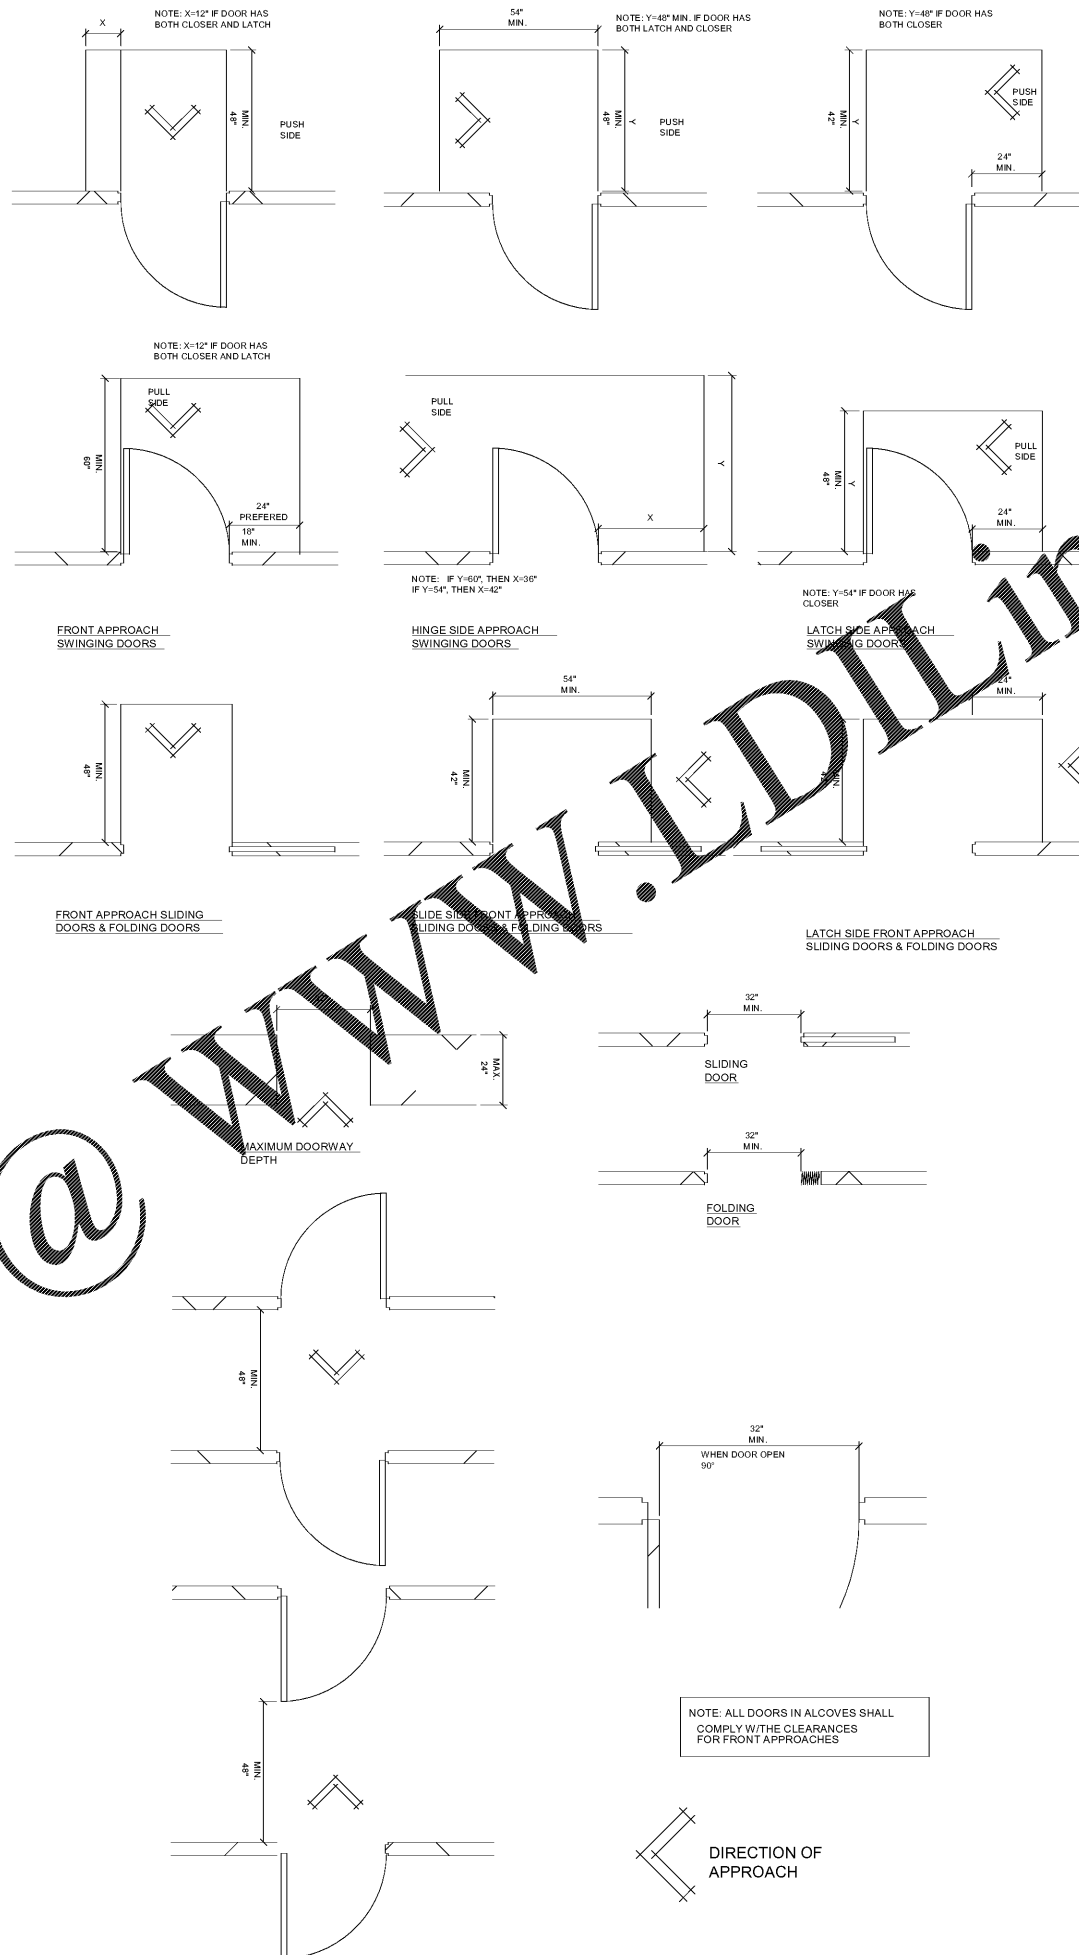

MANEUVERING CLEARANCES AT DOORS

LIST OF REQUIRED SUBMITTALS TO ARCHITECT

- DIVISION 01 - GENERAL REQUIREMENTS
 - 017700 Closeout Procedures
 - 017823 Operation And Maintenance Data
 - 017839 Project Record Documents
- DIVISION 02 - EXISTING CONDITIONS
- DIVISION 03 - CONCRETE
 - 35413 Gypsum Cement Underlayment
- DIVISION 04 - MASONRY
- DIVISION 05 - METALS
- DIVISION 06 - WOOD, PLASTICS, AND COMPOSITES
 - 061000 Rough Carpentry
 - 064023 Interior Architectural Woodwork & Millwork
- DIVISION 07 - THERMAL AND MOISTURE PROTECTION
 - 072100 Thermal Insulation
 - 078413 Penetration Firestop Systems
 - 079200 Joint Sealants
- DIVISION 08 - OPENINGS
 - 081113 Hollow Metal Doors And Frames
 - 081416 Flush Wood Doors
 - 087100 Door Hardware
 - 089000 Glazing
 - 089000 Louvers And Vents
- DIVISION 09 - FINISHES
 - 092216 Non-Structural Metal Framing
 - 092900 Gypsum Board
 - 093000 Tiling
 - 093113 Acoustic Panel Ceilings
 - 093513 Resilient Base And Accessories
 - 096513 Resilient Tile Flooring
 - 096813 Tile Carpeting
 - 097100 Wall Coverings
 - 097100 Painting And Staining
- DIVISION 10 - SPECIALTIES
 - 101400 Signage
 - 102800 Toilet And Bath Accessories
 - 104413 Fire Extinguisher Cabinets
 - 104416 Fire Extinguishers
- 11 - EQUIPMENT
 - 113100 Residential Appliances
- DIVISION 12 - FURNISHINGS
- DIVISION 13 - SPECIAL CONSTRUCTION
- DIVISION 14-CONVEYING EQUIPMENT
 - 211300 Fire Sprinkler System
- DIVISION 22 - PLUMBING
 - 220719 Pipe Insulation
 - 221116 Domestic Water Piping
 - 221316 Sanitary Waste Piping
 - 224200 Plumbing Fixtures
- DIVISION 23 - HEATING VENTILATING AND AIR
 - 230519 Meters and Gages
 - 230713 Duct Insulation
 - 230900 HVAC Temperature Controls
 - 231123 Gas Piping
 - 233113 Metal Ducts
 - 233300 Duct Accessories
 - 233423 Exhaust Fans
- DIVISION 26 - ELECTRICAL
 - 260516 Low-Voltage Conductors and Cables
 - S 1 & 7 260525 Grounding and Bonding
 - 260529 Hangers and Supports for Electrical Systems
 - 260533 Raceways and Boxes for Electrical Systems
 - 260923 Lighting Control Devices
 - 262416 Panelboards
 - 262726 Wiring Devices
 - 265100 Interior Lighting
 - 265600 Exterior Lighting
- DIVISION 27 - COMMUNICATIONS
 - 270533 Raceways and Boxes for Communications Systems
 - 271000 Telecommunications System
 - 271500 Communications Horizontal Cab ing
 - 275132 CATV, CCTV and Card Reader Systems
- DIVISION 28 - ELECTRONIC SAFETY AND SECURITY
 - 283100 Fire Detection and Alarm
- DIVISION 31 - EARTHWORK
- DIVISION 32 - EXTERIOR IMPROVEMENTS
- DIVISION 33 - UTILITIES



THESE DRAWINGS, INCLUDING ALL DESIGN DETAILS, SPECIFICATIONS AND INFORMATION ARE THE SOLE PROPERTY AND COPYRIGHT OF ML GROUP DESIGN + DEVELOPMENT. THEY SHALL NOT BE USED ON ANY OTHER WORK WITHOUT WRITTEN PERMISSION OF ML GROUP DESIGN + DEVELOPMENT.

JOB NO. P19-1023

DATE	ISSUE DESCRIPTION
11/01/2019	ISSUED FOR PERMIT
10/18/2019	ISSUED FOR COORDINATION

PROJECT: **CITADEL WINSTON-SALEM**
 1900 WEST FIRST STREET,
 WINSTON-SALEM, NC 27104

OWNER: THE CITADEL AT WINSTON-SALEM, LLC
 15720 BROOKHAM HILL AVE #300 | CHARLOTTE, NC 28277

GENERAL DETAILS & SUBMITTALS

SHEET NUMBER
G1.1.1