


**SITE LIGHTING PLAN GENERAL NOTES**

1. CONTRACTOR TO PROVIDE AND INSTALL ALL CONDUIT, WIRE AND DEVICES REQUIRED FOR MONUMENT SIGN. VERIFY LOCATION AND REQUIREMENTS WITH SIGN MANUFACTURER PRIOR TO ROUGH-IN.
2. PROVIDE ALL GROUNDING FOR MONUMENT SIGN PER MANUFACTURER'S AND LOCAL CODE REQUIREMENTS.
3. REFERENCE CIVIL SITE LIGHTING PLAN FOR THE FOLLOWING INFORMATION:
  - 3.1. POLE SPECIFICATIONS
  - 3.2. LIGHTING FIXTURE MOUNTING HEIGHT
  - 3.3. LIGHTING FIXTURE SPECIFICATIONS
  - 3.4. LIGHTING FIXTURE DESIGNATIONS
4. REFER TO SHEET E1 FOR BUILDING MOUNTED LIGHT FIXTURE LOCATIONS AND DESIGNATIONS

**Ⓢ SITE LIGHTING PLAN KEY NOTES**

1. REFERENCE SHEET E5 FOR CONTACTOR DIAGRAM AND PANELBOARD SCHEDULES.

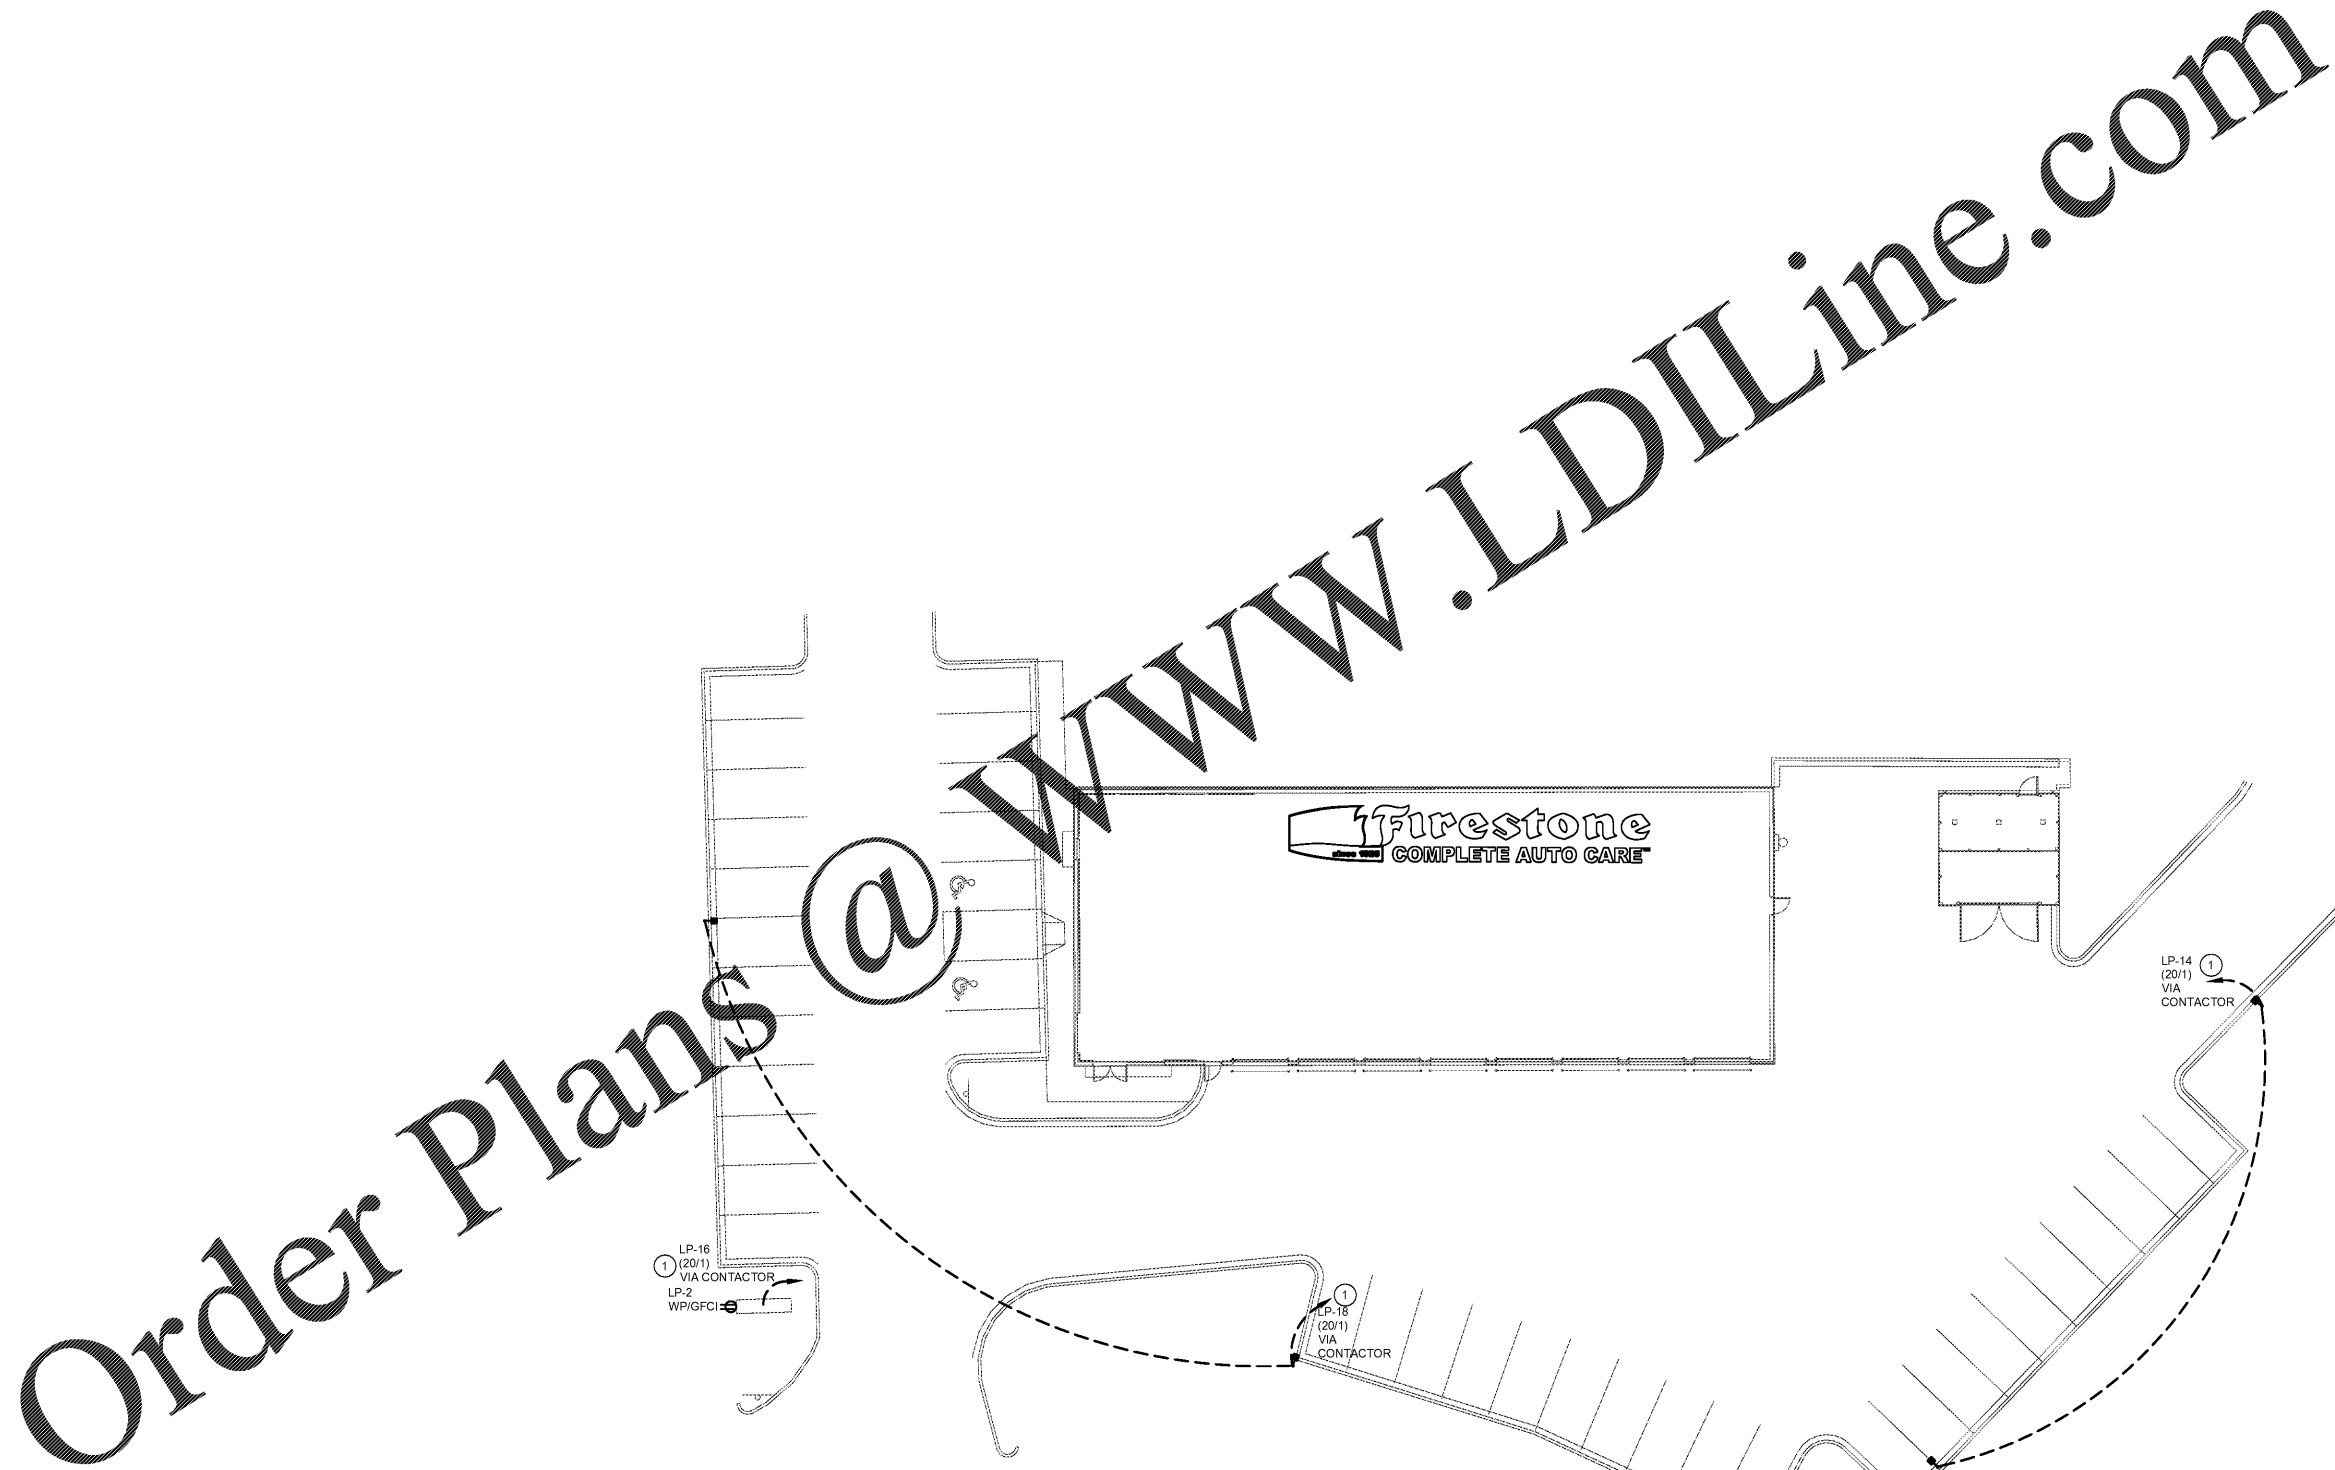


**1** ELECTRICAL SITE PLAN  
 ESL1 SCALE: 1/16" = 1'-0"



REPRODUCTION OF THIS DRAWING IS PROHIBITED WITHOUT THE WRITTEN PERMISSION OF ACERTUS CONSULTING GROUP, LLC. THIS DRAWING IS THE PROPERTY OF BRIDGESTONE RETAIL OPERATIONS, LLC AND IS LOANED ON THE EXPRESS CONDITION THAT IT IS NOT TO BE USED IN ANY WAY DEPRECIATE TO THE INTERESTS OF BRIDGESTONE RETAIL OPERATIONS, LLC. NO PART OF THIS DRAWING IS TO BE REPRODUCED OR TRANSMITTED IN ANY FORM OR BY ANY MEANS, ELECTRONIC OR MECHANICAL, INCLUDING PHOTOCOPYING, RECORDING, OR BY ANY INFORMATION STORAGE AND RETRIEVAL SYSTEM, WITHOUT THE EXPRESS WRITTEN PERMISSION OF BRIDGESTONE RETAIL OPERATIONS, LLC. ADISSION TO THE EXCLUSIVE OWNERSHIP AND TO THE DRAWING BY BRIDGESTONE RETAIL OPERATIONS, LLC.

**NEW FCAC STORE**  
 2019 JANUARY -SMALL ER  
 5845 NC HWY 42  
 GARNER, NC

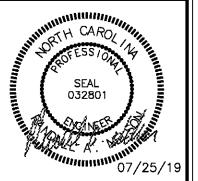

ISSUE BLOCK	

PROPERTY NO.: 160017  
 6 DIGIT NO.: 903065  
 4 DIGIT NO.: 015P  
 AOR PROJECT NUMBER: 1955801  
 TO PERMIT: DATE: 07-28-19  
 TO BID: DATE: ##-##-##

SHEET TITLE:  
**SITE LIGHTING PLAN**

SHEET NUMBER:  
**ESL1**