


Order Plans @

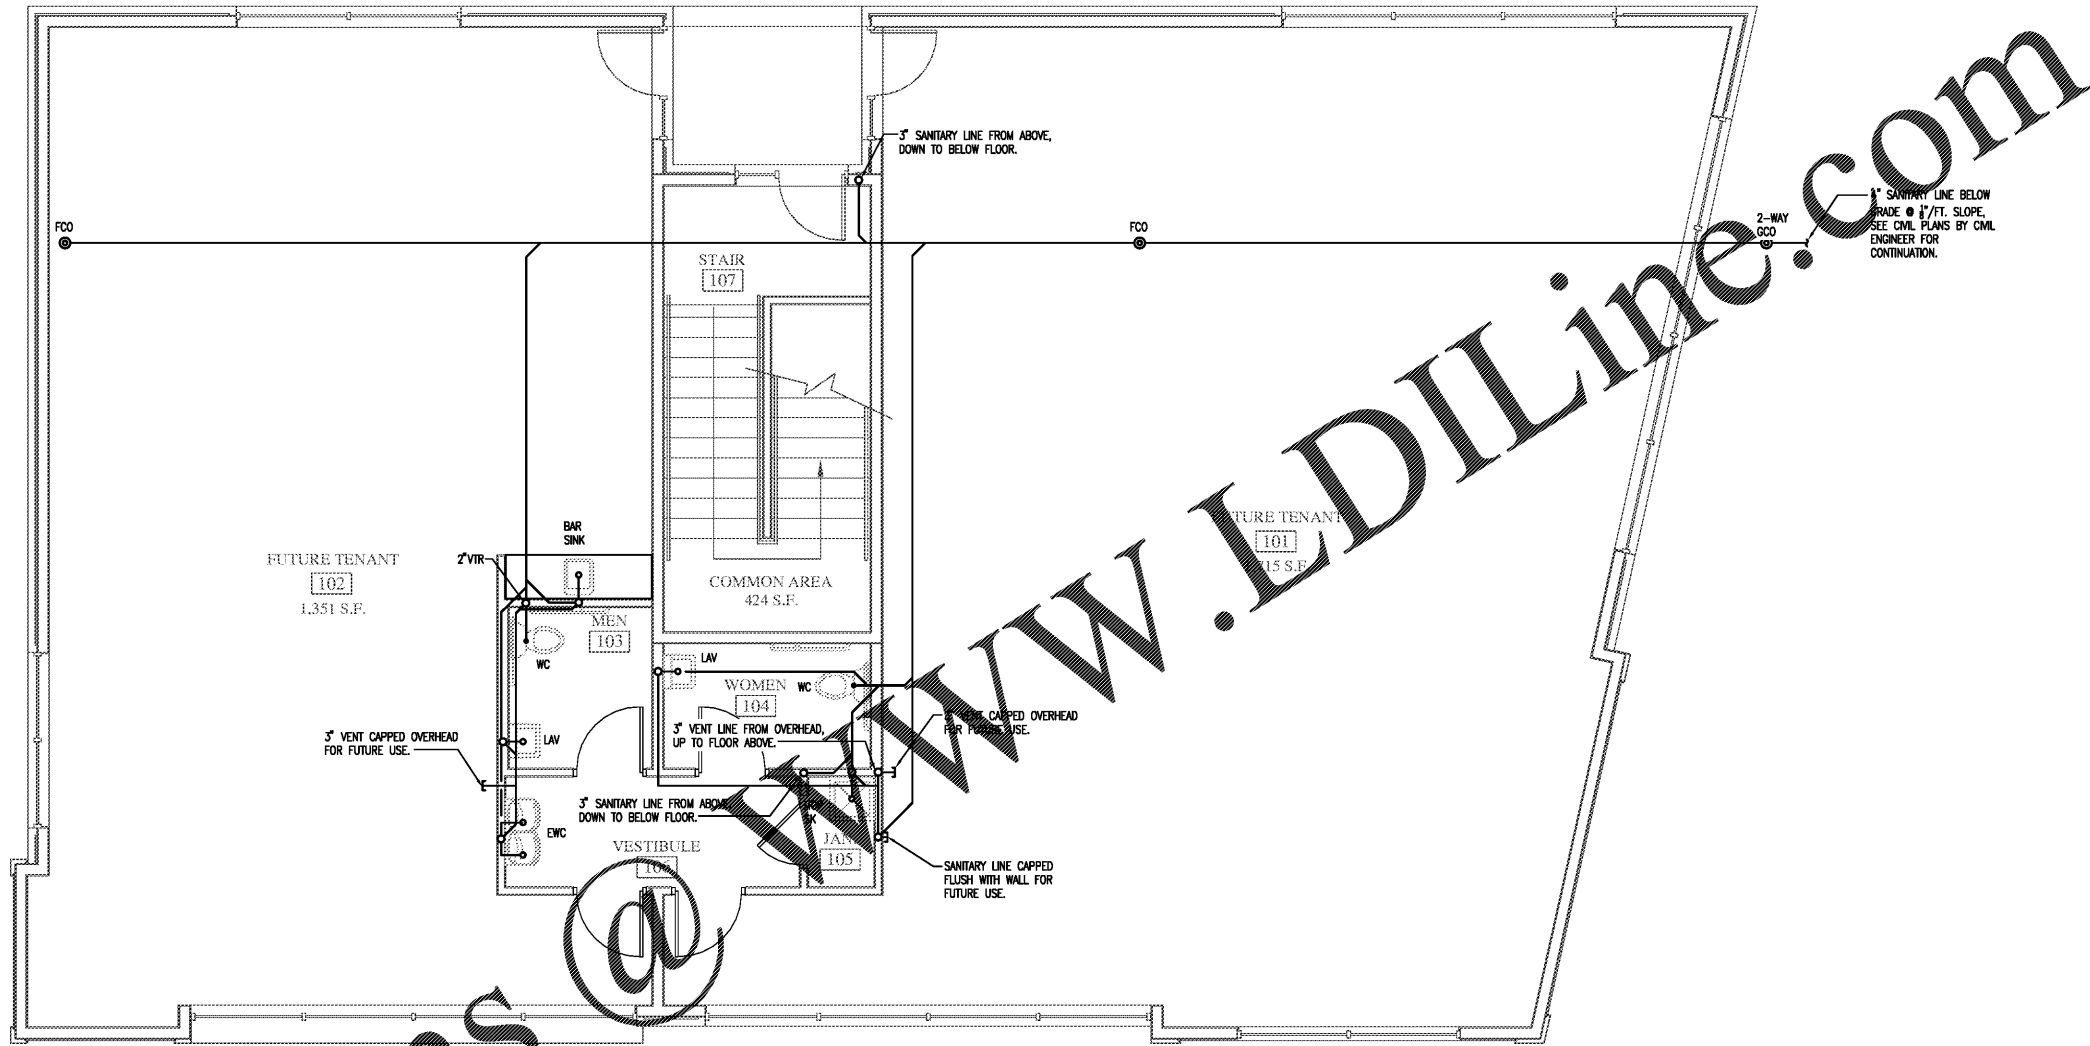

1 1ST FLOOR SANITARY PLAN  
P-2 1/4"=1'-0"

FOR PRICING ONLY

REVISIONS	
NO.	DATE

Project No: 1923  
 Scale:  
 Date Drawn: 10/04/19  
 Sheet Title  
 1ST FLOOR  
 SANITARY  
 PLAN