


Order Plans @ www.LDILine.com

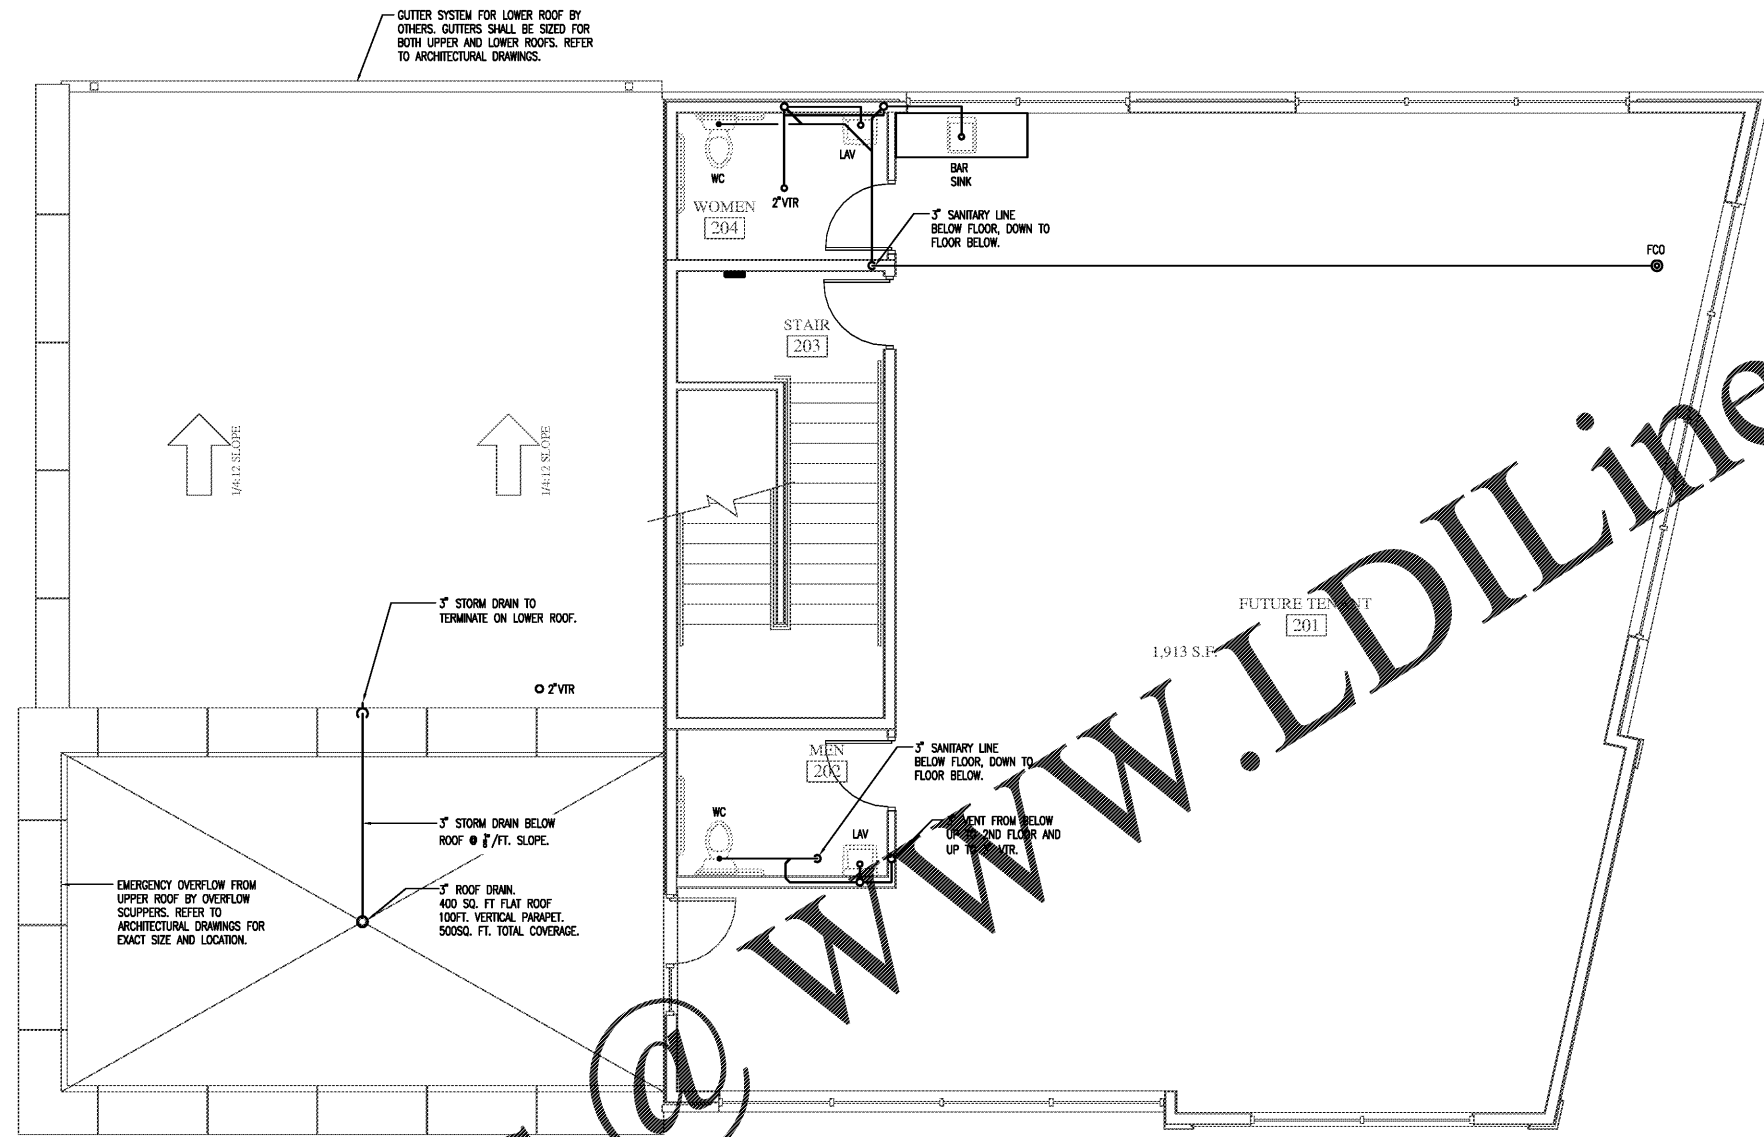

1 2ND FLOOR SANITARY PLAN
P-3 1/4"=1'-0"

FOR PRICING ONLY

REVISIONS	
NO.	DATE

BH PECAN, LLC
 900 PECAN AVENUE
 CHARLOTTE, NORTH CAROLINA 28205

Project No: 1923
 Scale:
 Date Drawn: 10/04/19
 Sheet Title
 2ND FLOOR
 SANITARY
 PLAN