


Order Plans

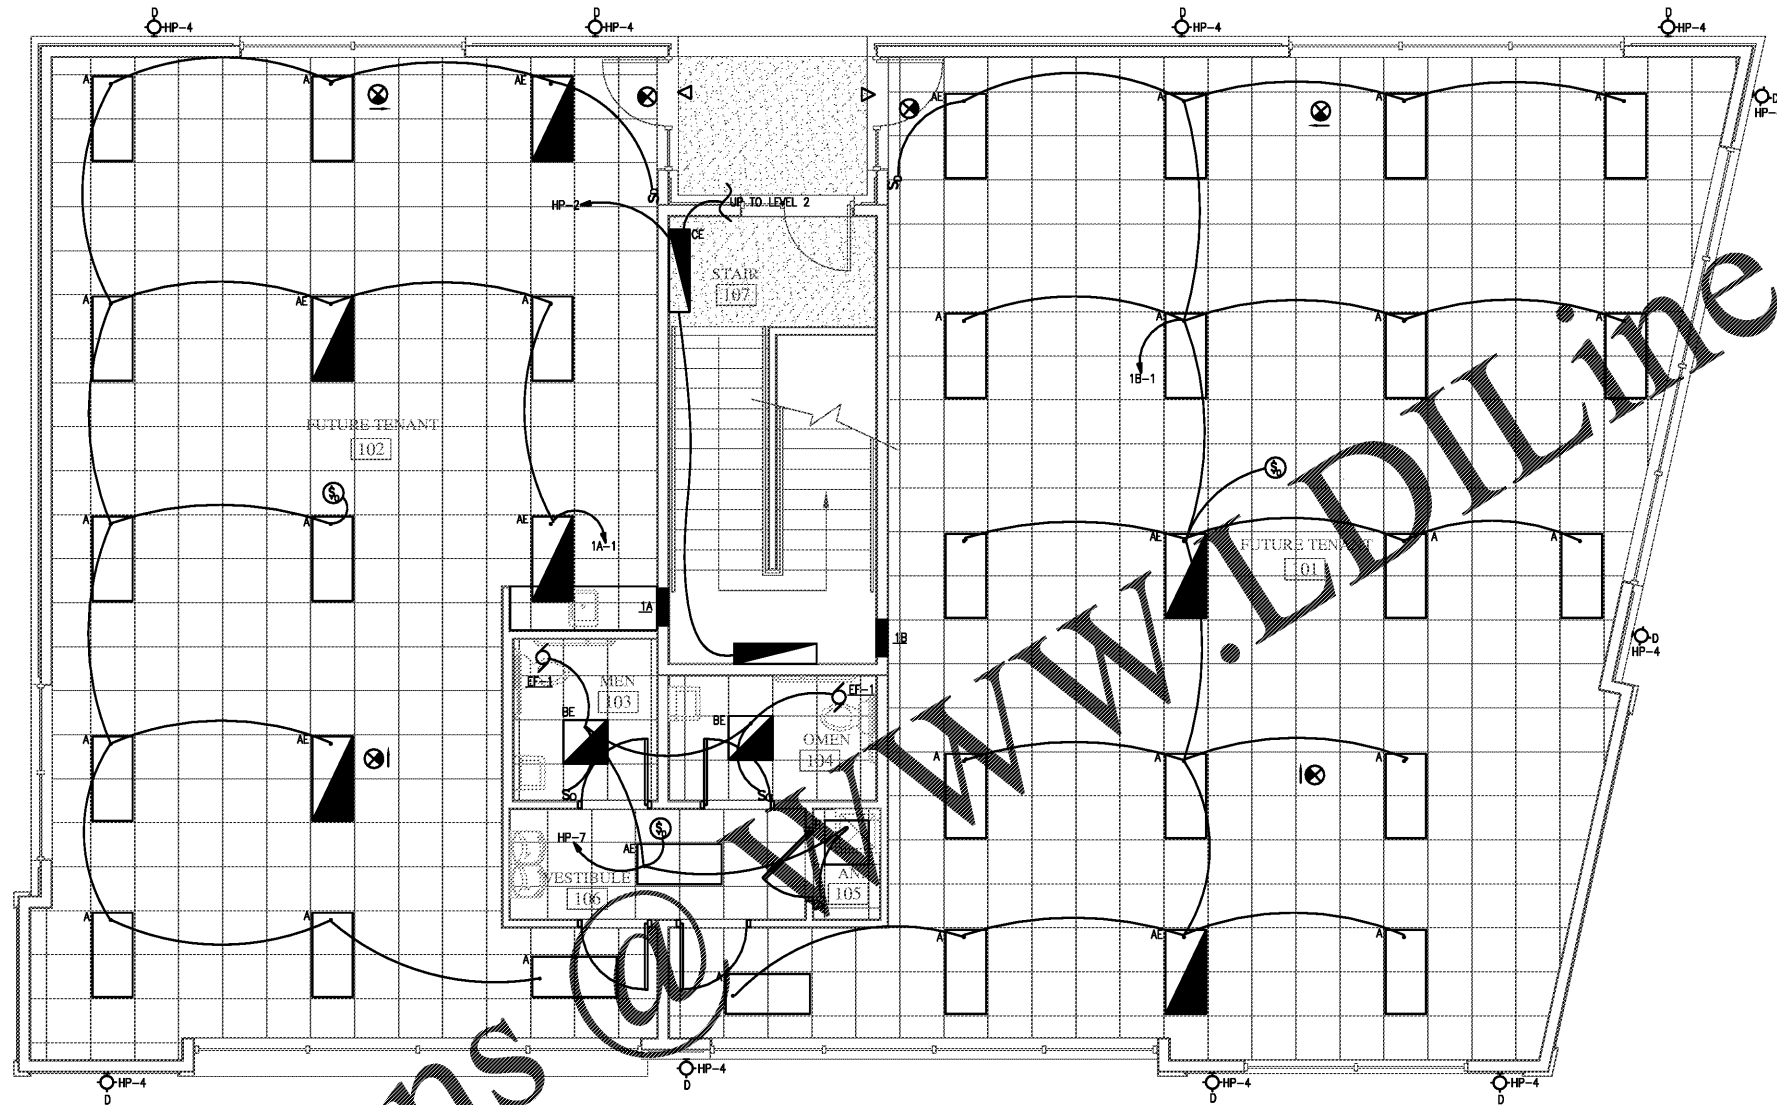

1 1ST FLOOR LIGHTING PLAN
E-2 1/4"=1'-0"

- GENERAL NOTES:
- A. ALL EXIT/EM LIGHTS SHALL BE CONNECTED TO NEAREST CIRCUIT AHEAD OF SWITCHING. ALL EXIT AND EMERGENCY BATTERIES SHALL BE TESTED. REPLACE FIXTURE IF BATTERY IS NOT OPERATING.
 - B. ALL EXTERIOR LIGHTING ARE NEW AND CONTROLLED BY TIMECLOCK 'ON' AND TIMECLOCK 'OFF'.

WWW.LDILINE.COM

PRIEST ARCHITECTURE
PRIEST ARCHITECTURE, PLLC
 1501 W. WILSON ROAD, SUITE 100, CHARLOTTE, NC 28205
 PHONE: 704.376.1400 FAX: 704.376.1500 MOBILE: 800.253.8600
 EMAIL: PRIESTARCHITECT@BELL.SOUTHLINET

ENGINEERING SOLUTIONS
1401 CENTRAL AVE-200J
 CHARLOTTE, NC 28205
 704.266.0942
 CERTIFICATE P-1340

FOR PRICING ONLY

| REVISIONS | |
|-----------|------|
| NO. | DATE |
| | |
| | |

BH PECAN, LLC
 900 PECAN AVENUE
 CHARLOTTE, NORTH CAROLINA 28205

Project No: 1923
 Scale:
 Date Drawn: 10/04/19
 Sheet Title
 1ST FLOOR LIGHTING PLAN

E-2