


H  
G  
F  
E  
D  
C  
B  
A

1 2 3 4 5 6 7 8 9 10

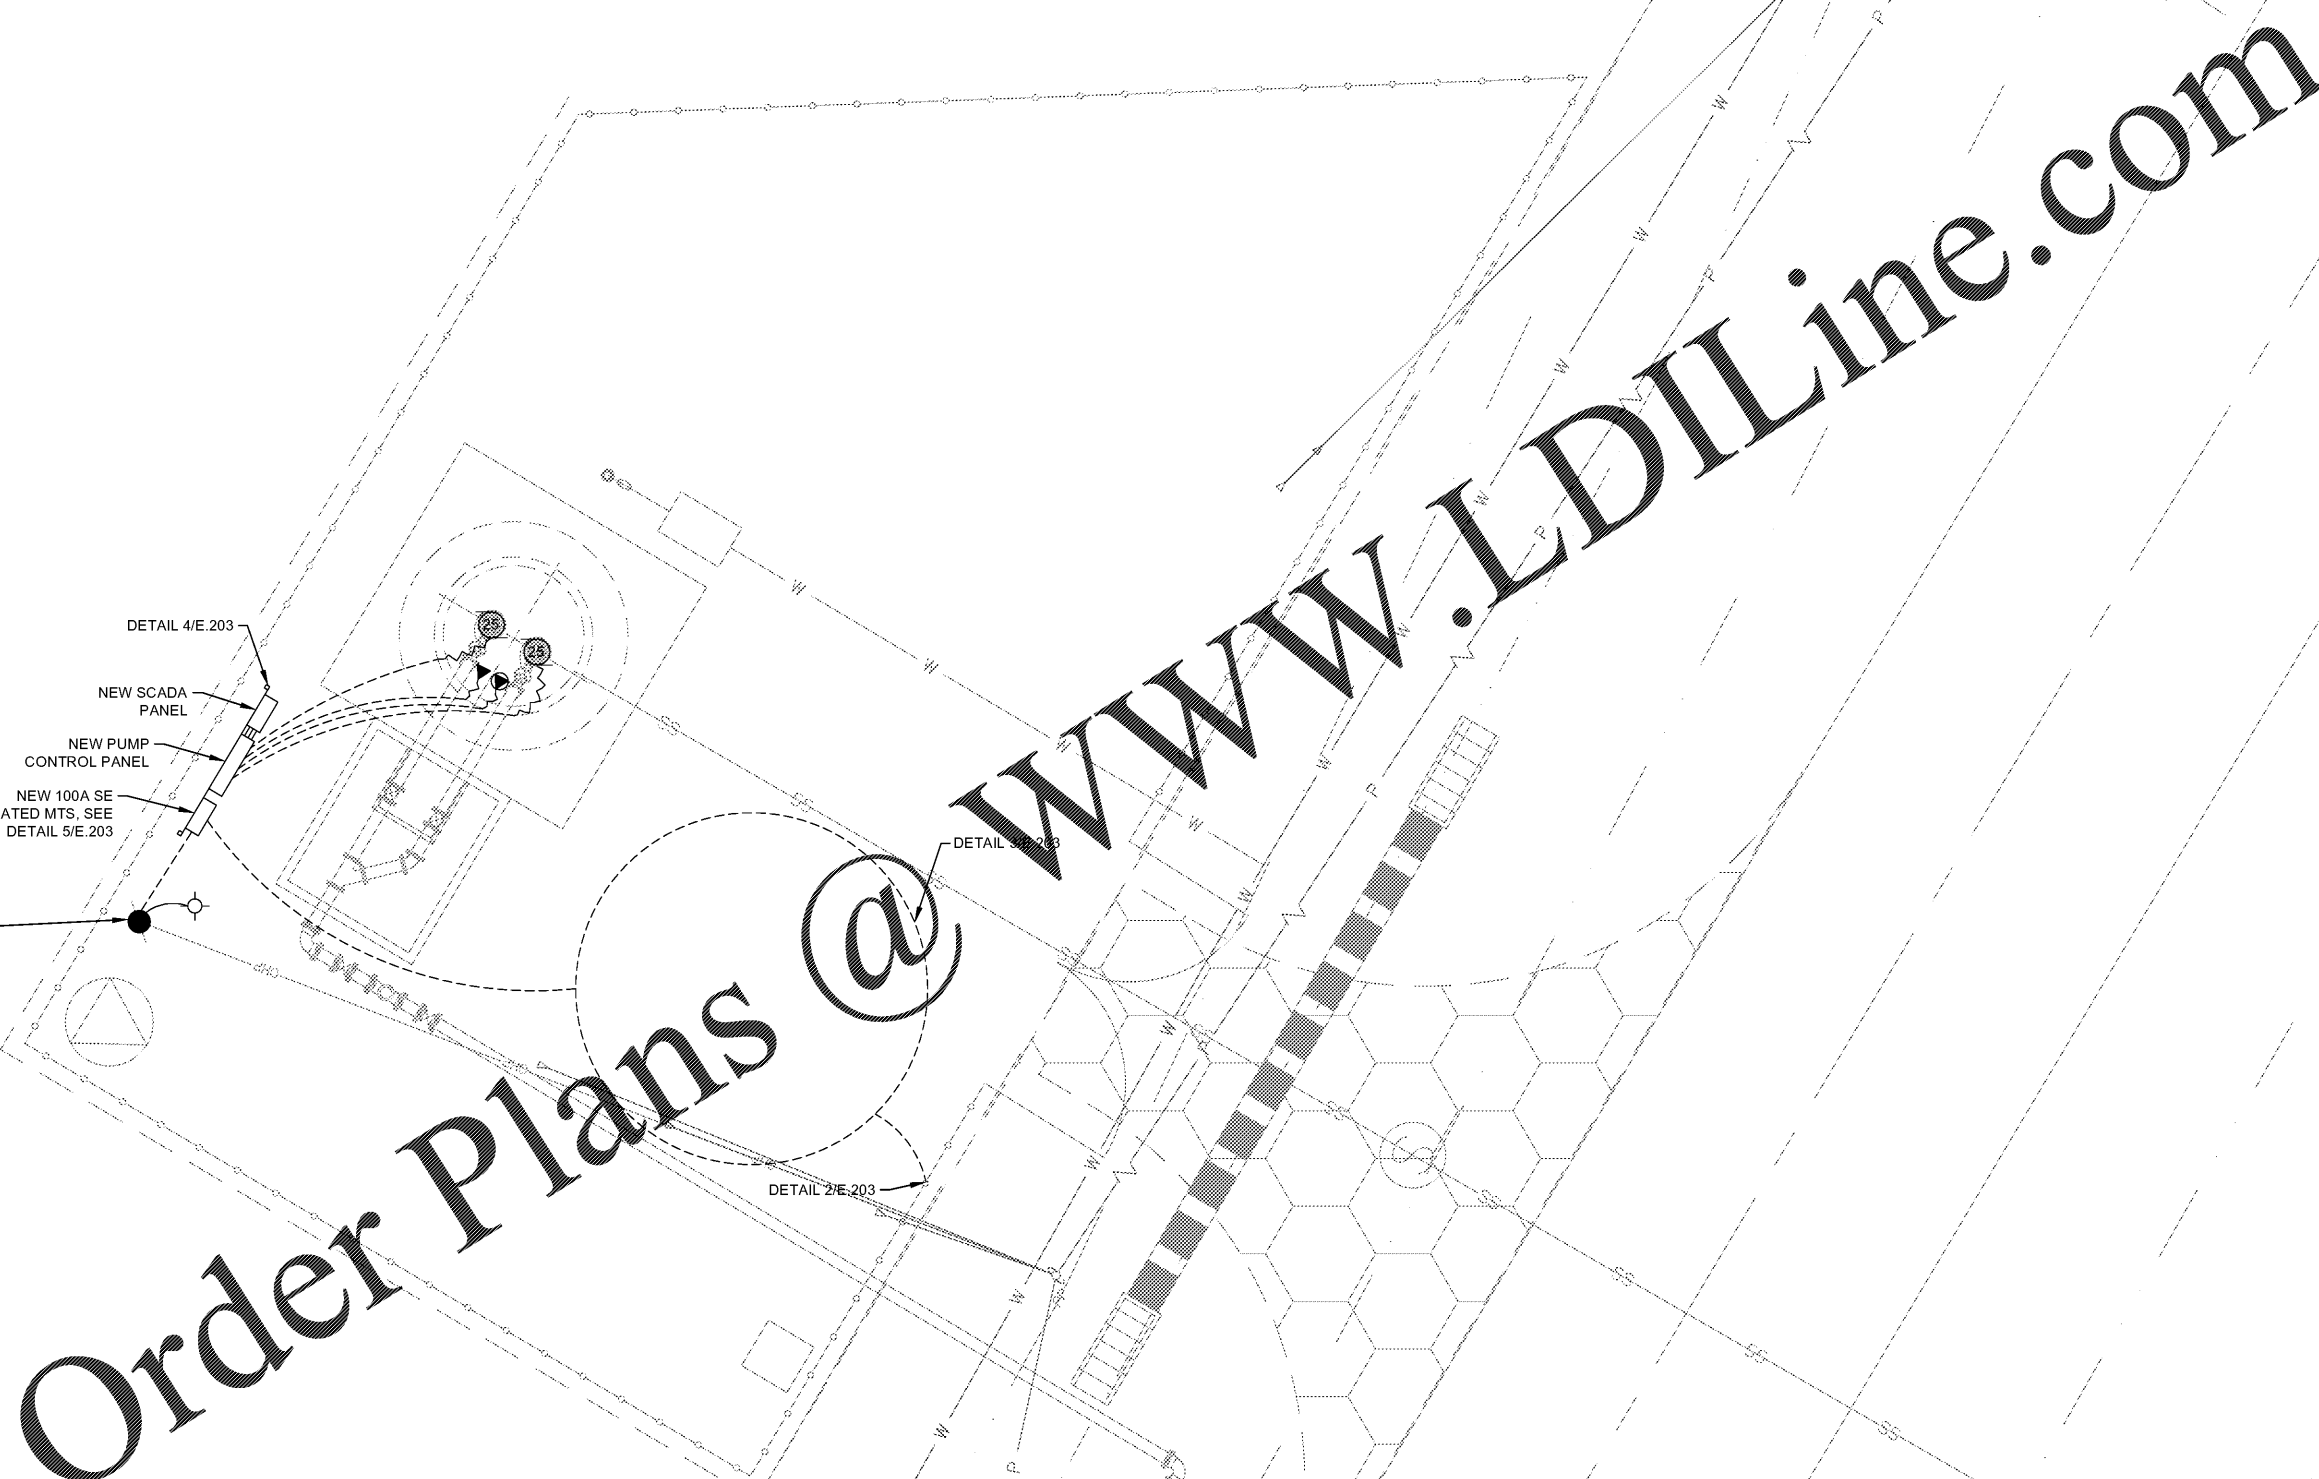

Order Plans @

NEW SCADA PANEL  
NEW PUMP CONTROL PANEL  
NEW 100A SE RATED MTS, SEE DETAIL 5/E.203

NEW SERVICE POLE WITH NEW SITE LIGHT, FEED THRU UTILITY METER, AND SERVICE DISCONNECT, SEE RISER DIAGRAM ON SHEET E.203


DETAIL 4/E.203

DETAIL 3/E.203

DETAIL 2/E.203

1  
E.202 ELECTRICAL SITE PLAN  
SCALE: 1" = 5'-0"

1 2 3 4 5 6 7 8 9 10

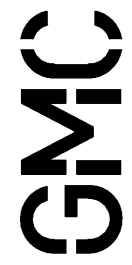


6120 Powers Ferry Road NW, Suite 350  
Atlanta, GA 30339  
T 770.952.2481  
GMCNETWORK.COM

ISSUE	DATE
PRELIMINARY	08.15.2019
75% SUBMITTAL	10.01.2019
BID READY	10.18.2019
DRAWN BY: JRD	
CHECKED BY: IMG, JEA	

NORTHGATE HIGH SCHOOL  
SANITARY SEWER  
COWETA COUNTY WATER AND  
SEWERAGE AUTHORITY

CATL190025

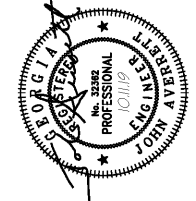

PETER ROAD PUMP  
STATION ELECTRICAL  
SITE PLAN

E.202  
Sheet of