



DRAWING LEGEND	
	ROOF DRAIN
	OVERFLOW SCUPPER
	EXPANSION JOINT AT WALL
	DRAIN SCUPPER WITH CONDUCTOR HEAD TO DOWNSPOUT
	VENT THROUGH ROOF
	MECHANICAL UNIT
	ROOF HATCH
	LADDER OVER COPING

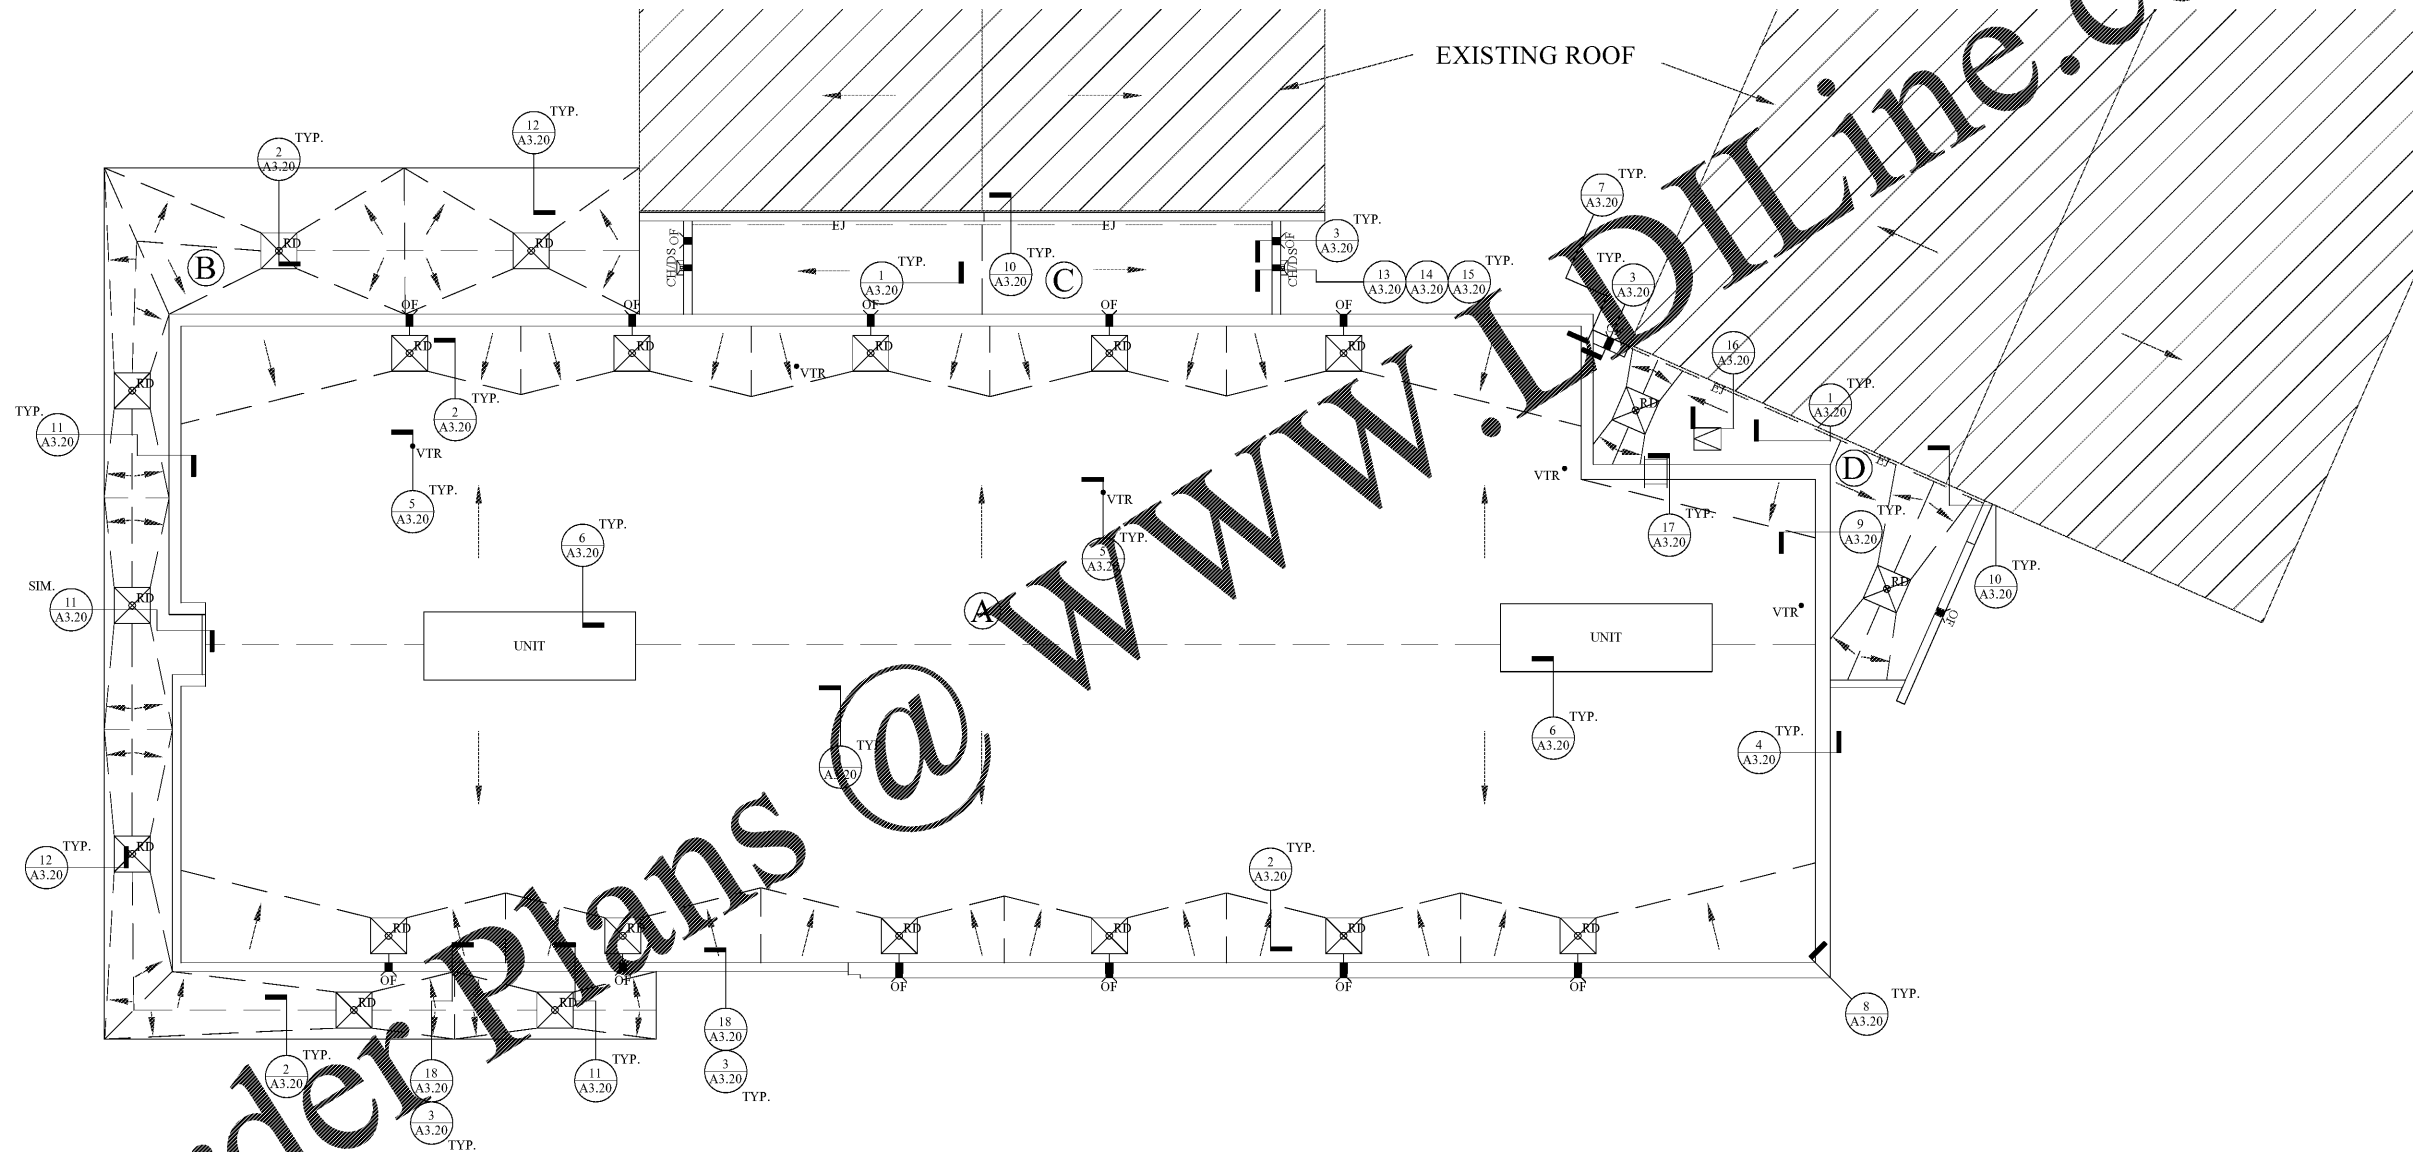


Order Plans @ [www.diline.com](http://www.diline.com)

**NOTES:**  
 1. OVERFLOW SCUPPER LOCATION PER ARCHITECTURAL ELEVATION DRAWINGS.

**NEW ROOF PLAN**

 

1219 Weyne  
 8664616, SC  
 29201  
 803/786-1476 R.K.C.  
 O.M.

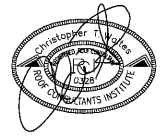

ISSUE	BID.	DATE
1		10.24.19

DRAWN BY: AL  
 CHECKED BY: EW

MILLBROOK ELEMENTARY  
 SCHOOL - ADDITIONS AND  
 RENOVATIONS  
 255 E PINE LOG RD, AIKEN, SC -29803  
 GMC # ACOL180004

ROOF PLAN -  
 RENOVATION PLAN

A3.10