


10/21/2019 12:27:48 PM



# Order Plans @ WWW.VDILine.com
 
## 1 ROOF PLAN - PLUMBING

SCALE: 1/8" = 1'-0"

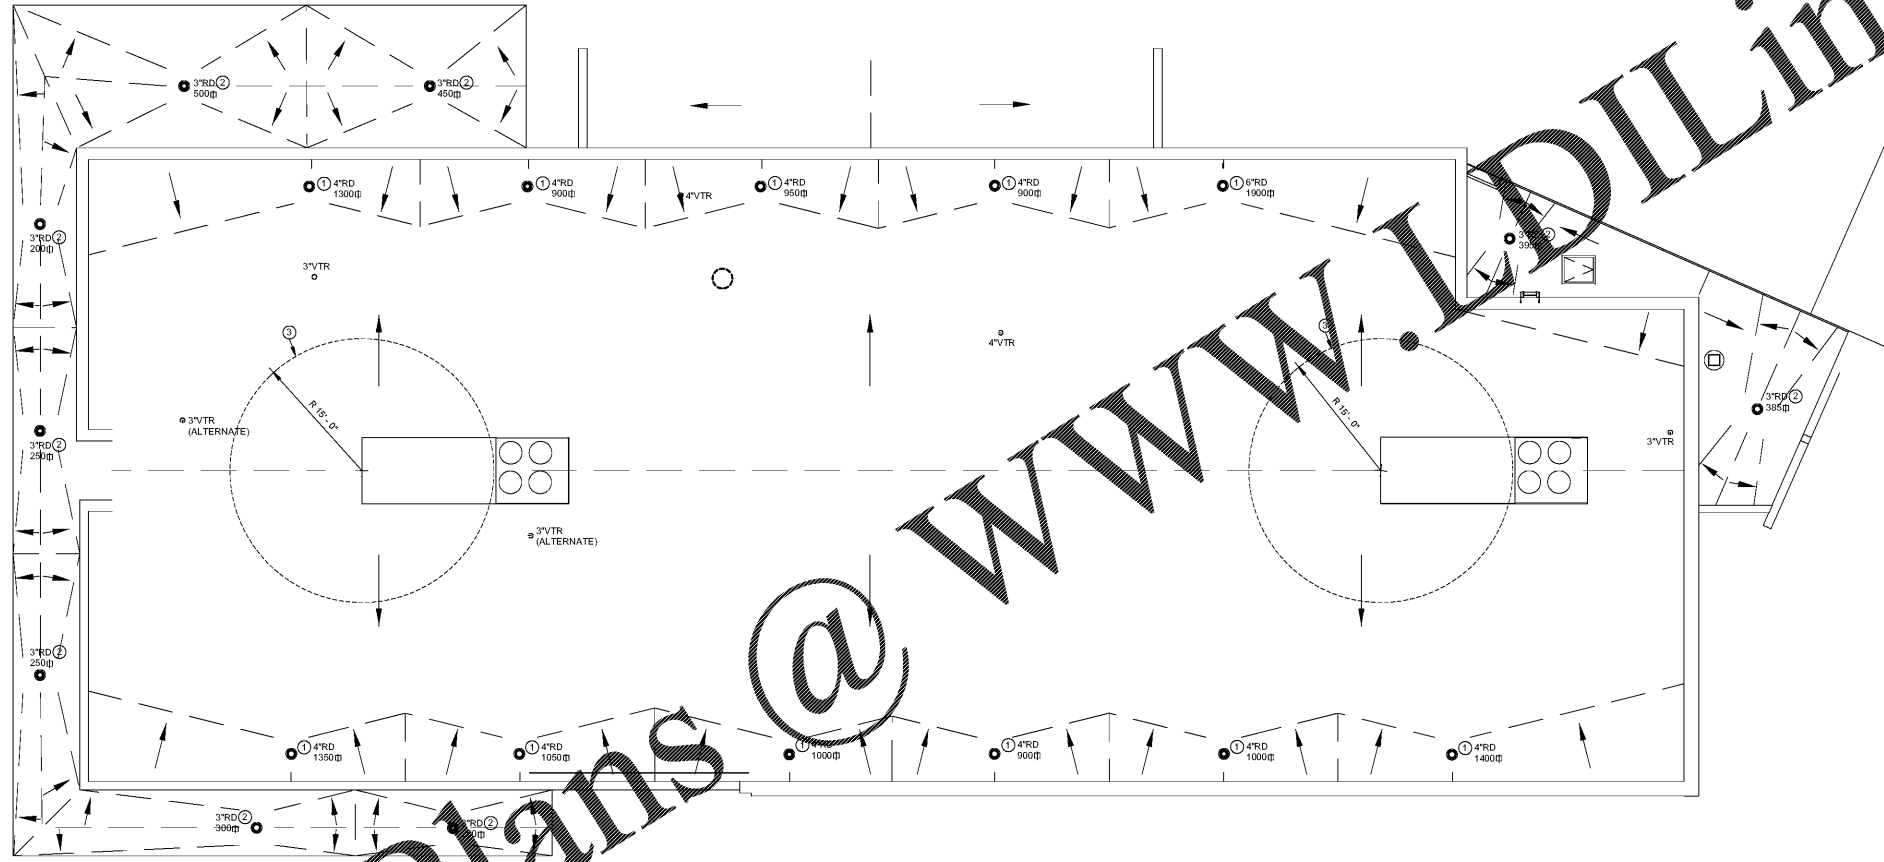

KEY PLAN

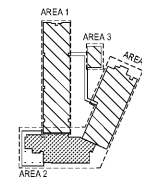

### NOTES

- ① 4" S.D. LINE DN.
- ② 3" S.D. LINE DN.
- ③ HVAC FRESH AIR INTAKE AREA. DO NOT INSTALL ANY VTR IN THIS AREA.

ROOF PLAN - PLUMBING

# P1.3

MILLBROOK ELEMENTARY SCHOOL - ADDITIONS AND RENOVATIONS  
 255 E PINE LOG RD, AIKEN, SC 29803  
 GMC # ACOL180004

ISSUE DATE

BID DOCUMENTS	DATE
	10.24.19

Buford Goff & Associates, Inc.

Engineers & Planners  
 1433 Boulevard Ave.  
 Suite 200, Columbia, SC 29201  
 Phone: 803.746.4332



1219 Wayne  
 Columbia, SC  
 GMCNETWORK.CO

