
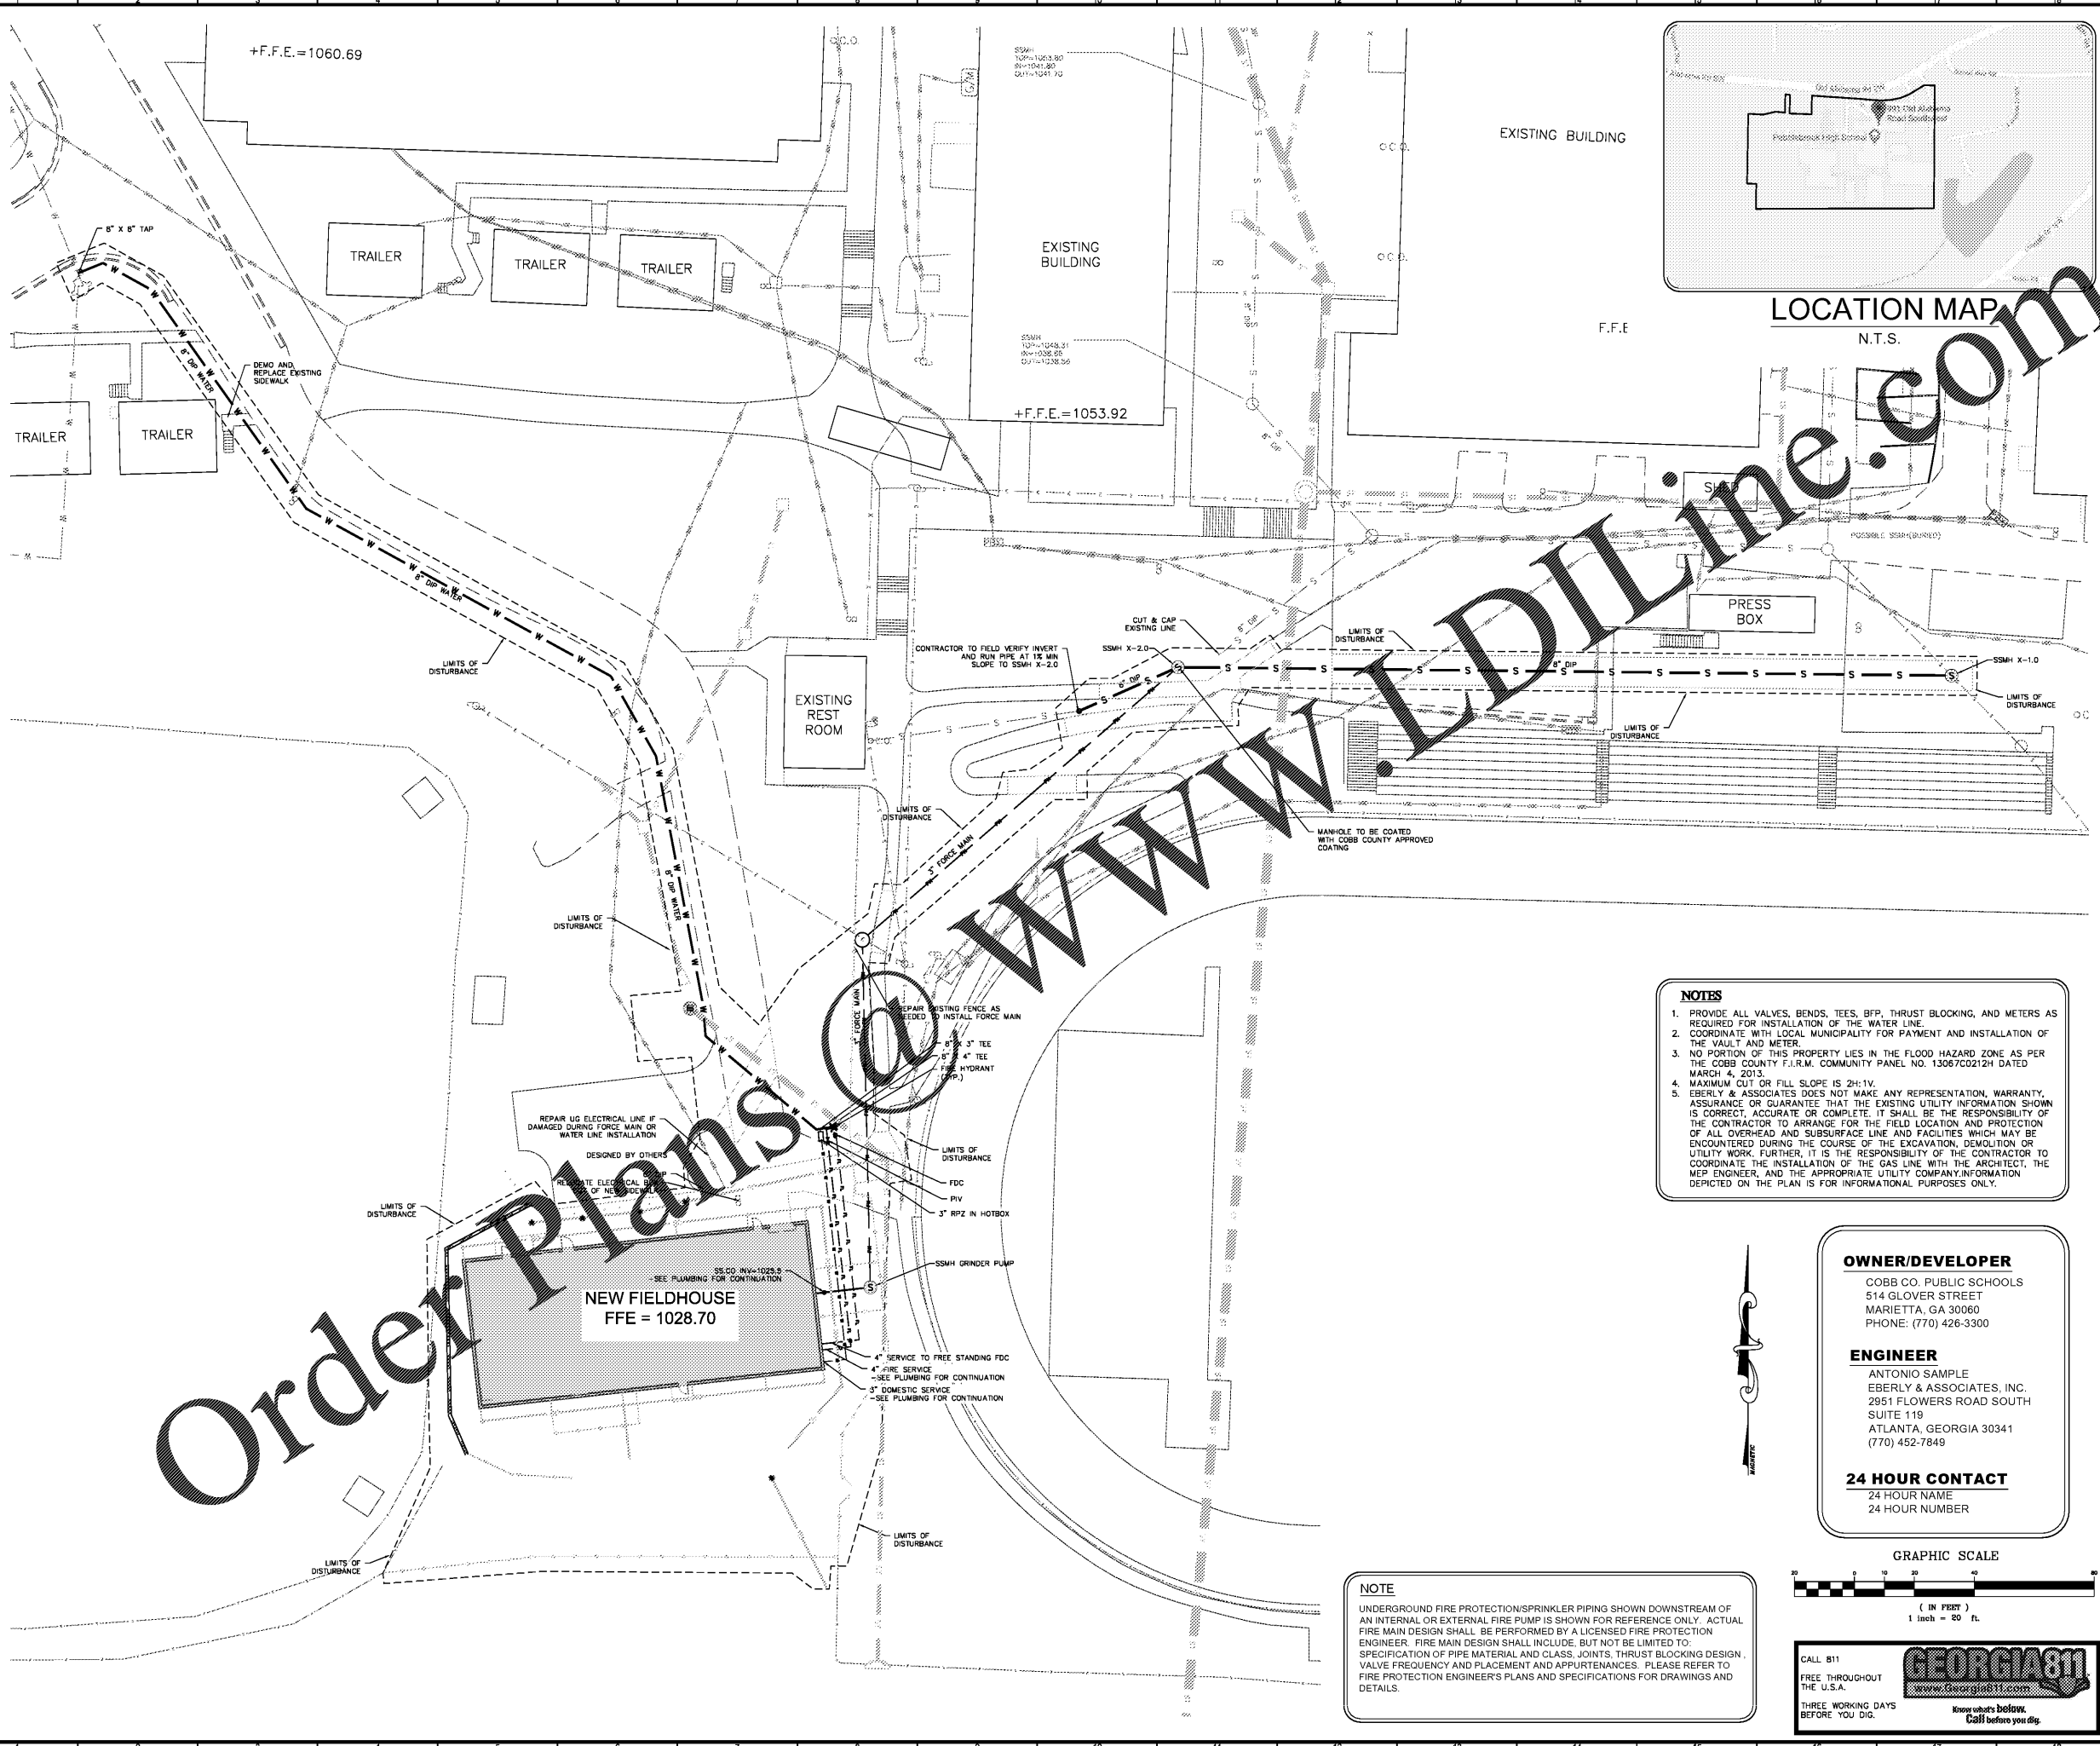


ISSUANCES		
No.	Drawing Issue Description	Date
A	ISSUE PRELIMINARY SUBMITTAL	2018/07/31
B	ISSUED FOR BID	2019/10/04

 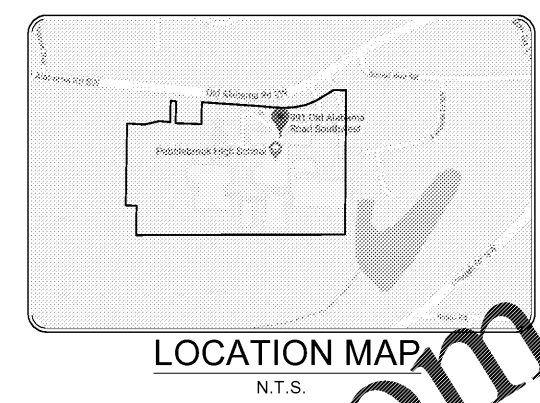


- NOTES**
1. PROVIDE ALL VALVES, BENDS, TEES, BFP, THRUST BLOCKING, AND METERS AS REQUIRED FOR INSTALLATION OF THE WATER LINE.
 2. COORDINATE WITH LOCAL MUNICIPALITY FOR PAYMENT AND INSTALLATION OF THE VAULT AND METER.
 3. NO PORTION OF THIS PROPERTY LIES IN THE FLOOD HAZARD ZONE AS PER THE COBB COUNTY F.I.R.M. COMMUNITY PANEL NO. 13067C0212H DATED MARCH 4, 2013.
 4. MAXIMUM CUT OR FILL SLOPE IS 2H:1V.
 5. EBERLY & ASSOCIATES DOES NOT MAKE ANY REPRESENTATION, WARRANTY, ASSURANCE OR GUARANTEE THAT THE EXISTING UTILITY INFORMATION SHOWN IS CORRECT, ACCURATE OR COMPLETE. IT SHALL BE THE RESPONSIBILITY OF THE CONTRACTOR TO ARRANGE FOR THE FIELD LOCATION AND PROTECTION OF ALL OVERHEAD AND SUBSURFACE LINE AND FACILITIES WHICH MAY BE ENCOUNTERED DURING THE COURSE OF THE EXCAVATION, DEMOLITION OR UTILITY WORK. FURTHER, IT IS THE RESPONSIBILITY OF THE CONTRACTOR TO COORDINATE THE INSTALLATION OF THE GAS LINE WITH THE ARCHITECT, THE MEP ENGINEER, AND THE APPROPRIATE UTILITY COMPANY INFORMATION DEPICTED ON THE PLAN IS FOR INFORMATIONAL PURPOSES ONLY.

OWNER/DEVELOPER
 COBB CO. PUBLIC SCHOOLS
 514 GLOVER STREET
 MARIETTA, GA 30060
 PHONE: (770) 426-3300

ENGINEER
 ANTONIO SAMPLE
 EBERLY & ASSOCIATES, INC.
 2951 FLOWERS ROAD SOUTH
 SUITE 119
 ATLANTA, GEORGIA 30341
 (770) 452-7849

24 HOUR CONTACT
 24 HOUR NAME
 24 HOUR NUMBER



NOTE
 UNDERGROUND FIRE PROTECTION/SPRINKLER PIPING SHOWN DOWNSTREAM OF AN INTERNAL OR EXTERNAL FIRE PUMP IS SHOWN FOR REFERENCE ONLY. ACTUAL FIRE MAIN DESIGN SHALL BE PERFORMED BY A LICENSED FIRE PROTECTION ENGINEER. FIRE MAIN DESIGN SHALL INCLUDE, BUT NOT BE LIMITED TO: SPECIFICATION OF PIPE MATERIAL AND CLASS, JOINTS, THRUST BLOCKING DESIGN, VALVE FREQUENCY AND PLACEMENT AND APPURTENANCES. PLEASE REFER TO FIRE PROTECTION ENGINEER'S PLANS AND SPECIFICATIONS FOR DRAWINGS AND DETAILS.



Order Plans @

WWW.DIline.com

PROJECT NUMBER: 20190224.01 PROJECT NAME: PEBBLEBROOK HS B007 - FIELDHOUSE
 SHEET NUMBER: G0.00 - COVER
 SHEET DATE: 10/25/2019
 10/27/2019 7:48:58 AM

PEBBLEBROOK HS B007 - FIELDHOUSE
 DOE Facility Code 4086
 FTE = 2787
 IU = 143
 991 OLD ALABAMA ROAD
 MABLETON, GA 30126
 COBB COUNTY SCHOOL DISTRICT

SITE UTILITY PLAN

Prepared By:	JEREMIAH PHILLIPS	19-110.10
Checked By:	ANTONIO SAMPLE	10/25/2019
Drawn By:	DYLAN LEE	
Project Engineer:	ROBERT NIEBESKI	
Scale:		C5.00