




COOPER CARRY
THE CENTER FOR CONNECTIVE ARCHITECTURE

191 Peachtree Street NE
Suite 2400
Atlanta, GA 30303-1770
(404) 257-2000
coopercarry.com

©2019 COOPER CARRY



ISSUANCES		
No.	Drawing Issue Description	Date
0600E	PRELIMINARY SUBMITTAL	07/31/19
1104W	ISSUED FOR B/D	11/04/19

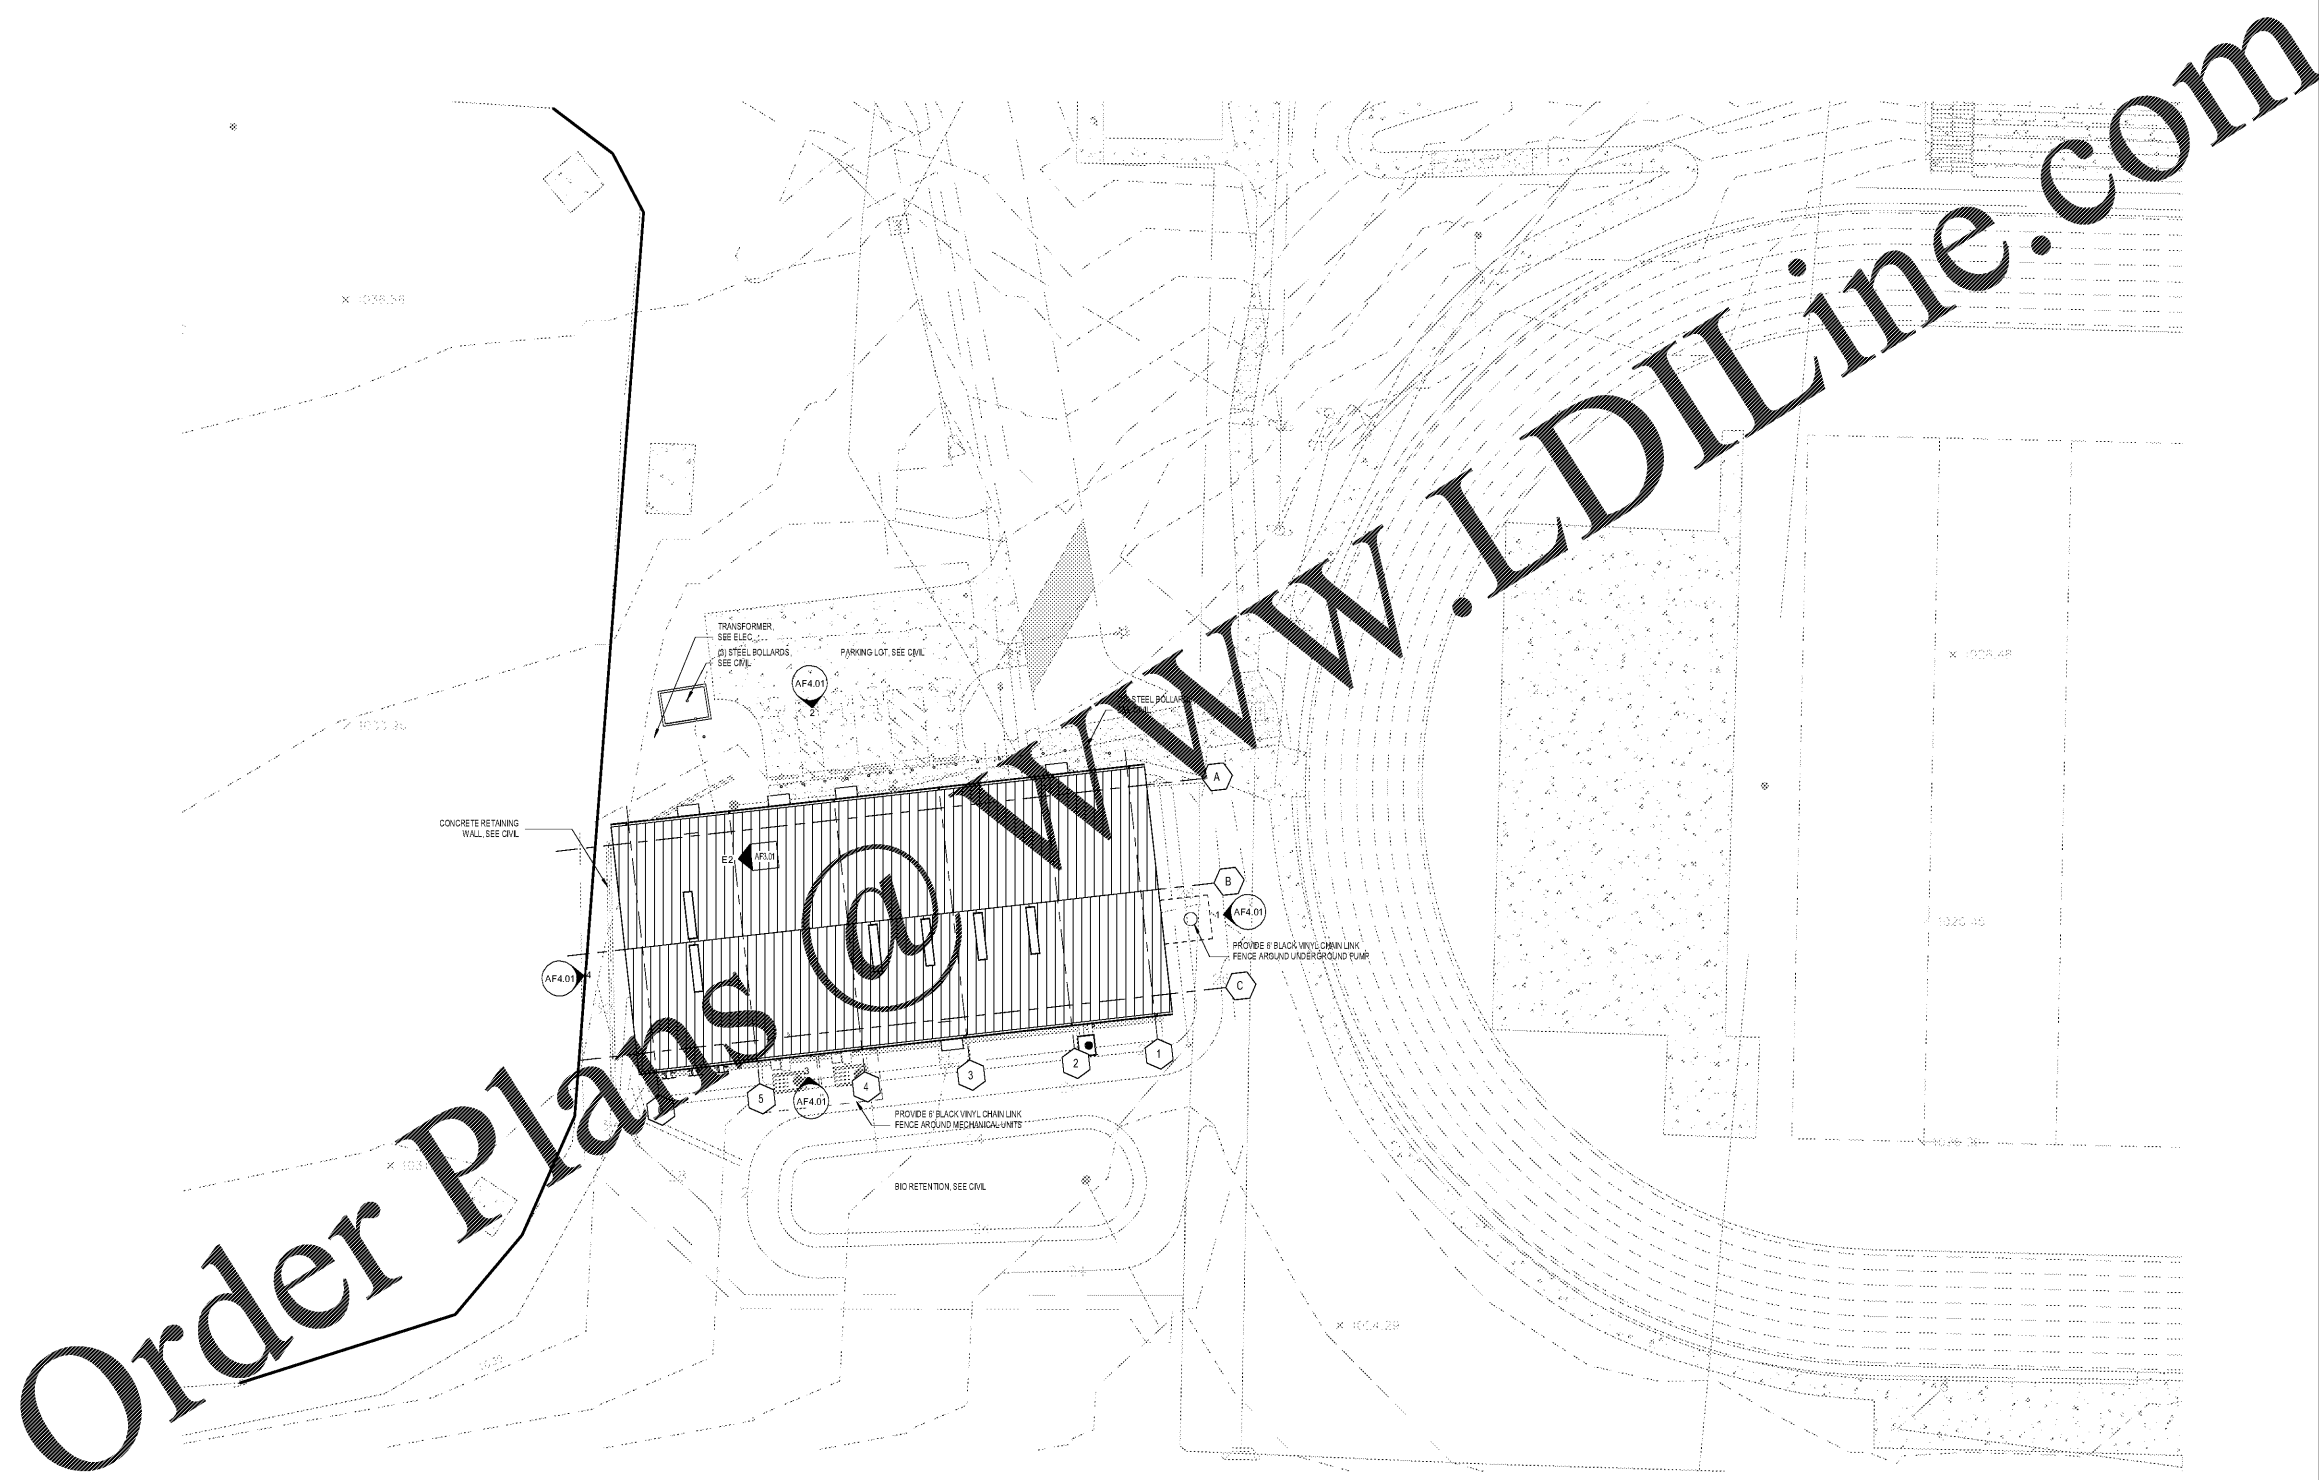

Order Plans @ www.LDILine.com

1 SITE PLAN - FIELDHOUSE
AF1.01 SCALE: 1/16" = 1'-0"
4 8 16 32

PROJECT NUMBER: 20190224.01 PROJECT NAME: PEBBLEBROOK HS S5B007 - FIELDHOUSE
SHEET NUMBER: AF1.01 - FIELDHOUSE SITE PLAN
M:\2018\20180008\07 drawings\4-7 rev\Users\20180008_Pebblebrook HS S5B007_Callaahan\01947.rvt
11/11/2019 10:42:40 AM

PEBBLEBROOK HS S5B007 -
FIELDHOUSE
DOE Facility Code 7010
FTE = 2787
IU = 143
991 OLD ALABAMA ROAD
MABLETON, GA 30126
COBB COUNTY SCHOOL DISTRICT
FIELDHOUSE SITE PLAN

ROBERT JUST 20190224.01
Principal/Designer
SOPHIA TARKHAN 11/04/19
Project Manager
MARC NUNES
Project Architect
WILLIAM CALLAHAN
Staff Architect

AF1.01

ISSUED FOR CONSTRUCTION