




COOPER CARRY
THE CENTER FOR CONNECTIVE ARCHITECTURE

191 Peachtree Street NE
Suite 2400
Atlanta, GA 30303-1770
(404) 237-2000
coopercarry.com

00219 COOPER CARRY



ISSUANCES		
No.	Drawing Issue Description	Date
1	ISSUED FOR BID	11/04/19

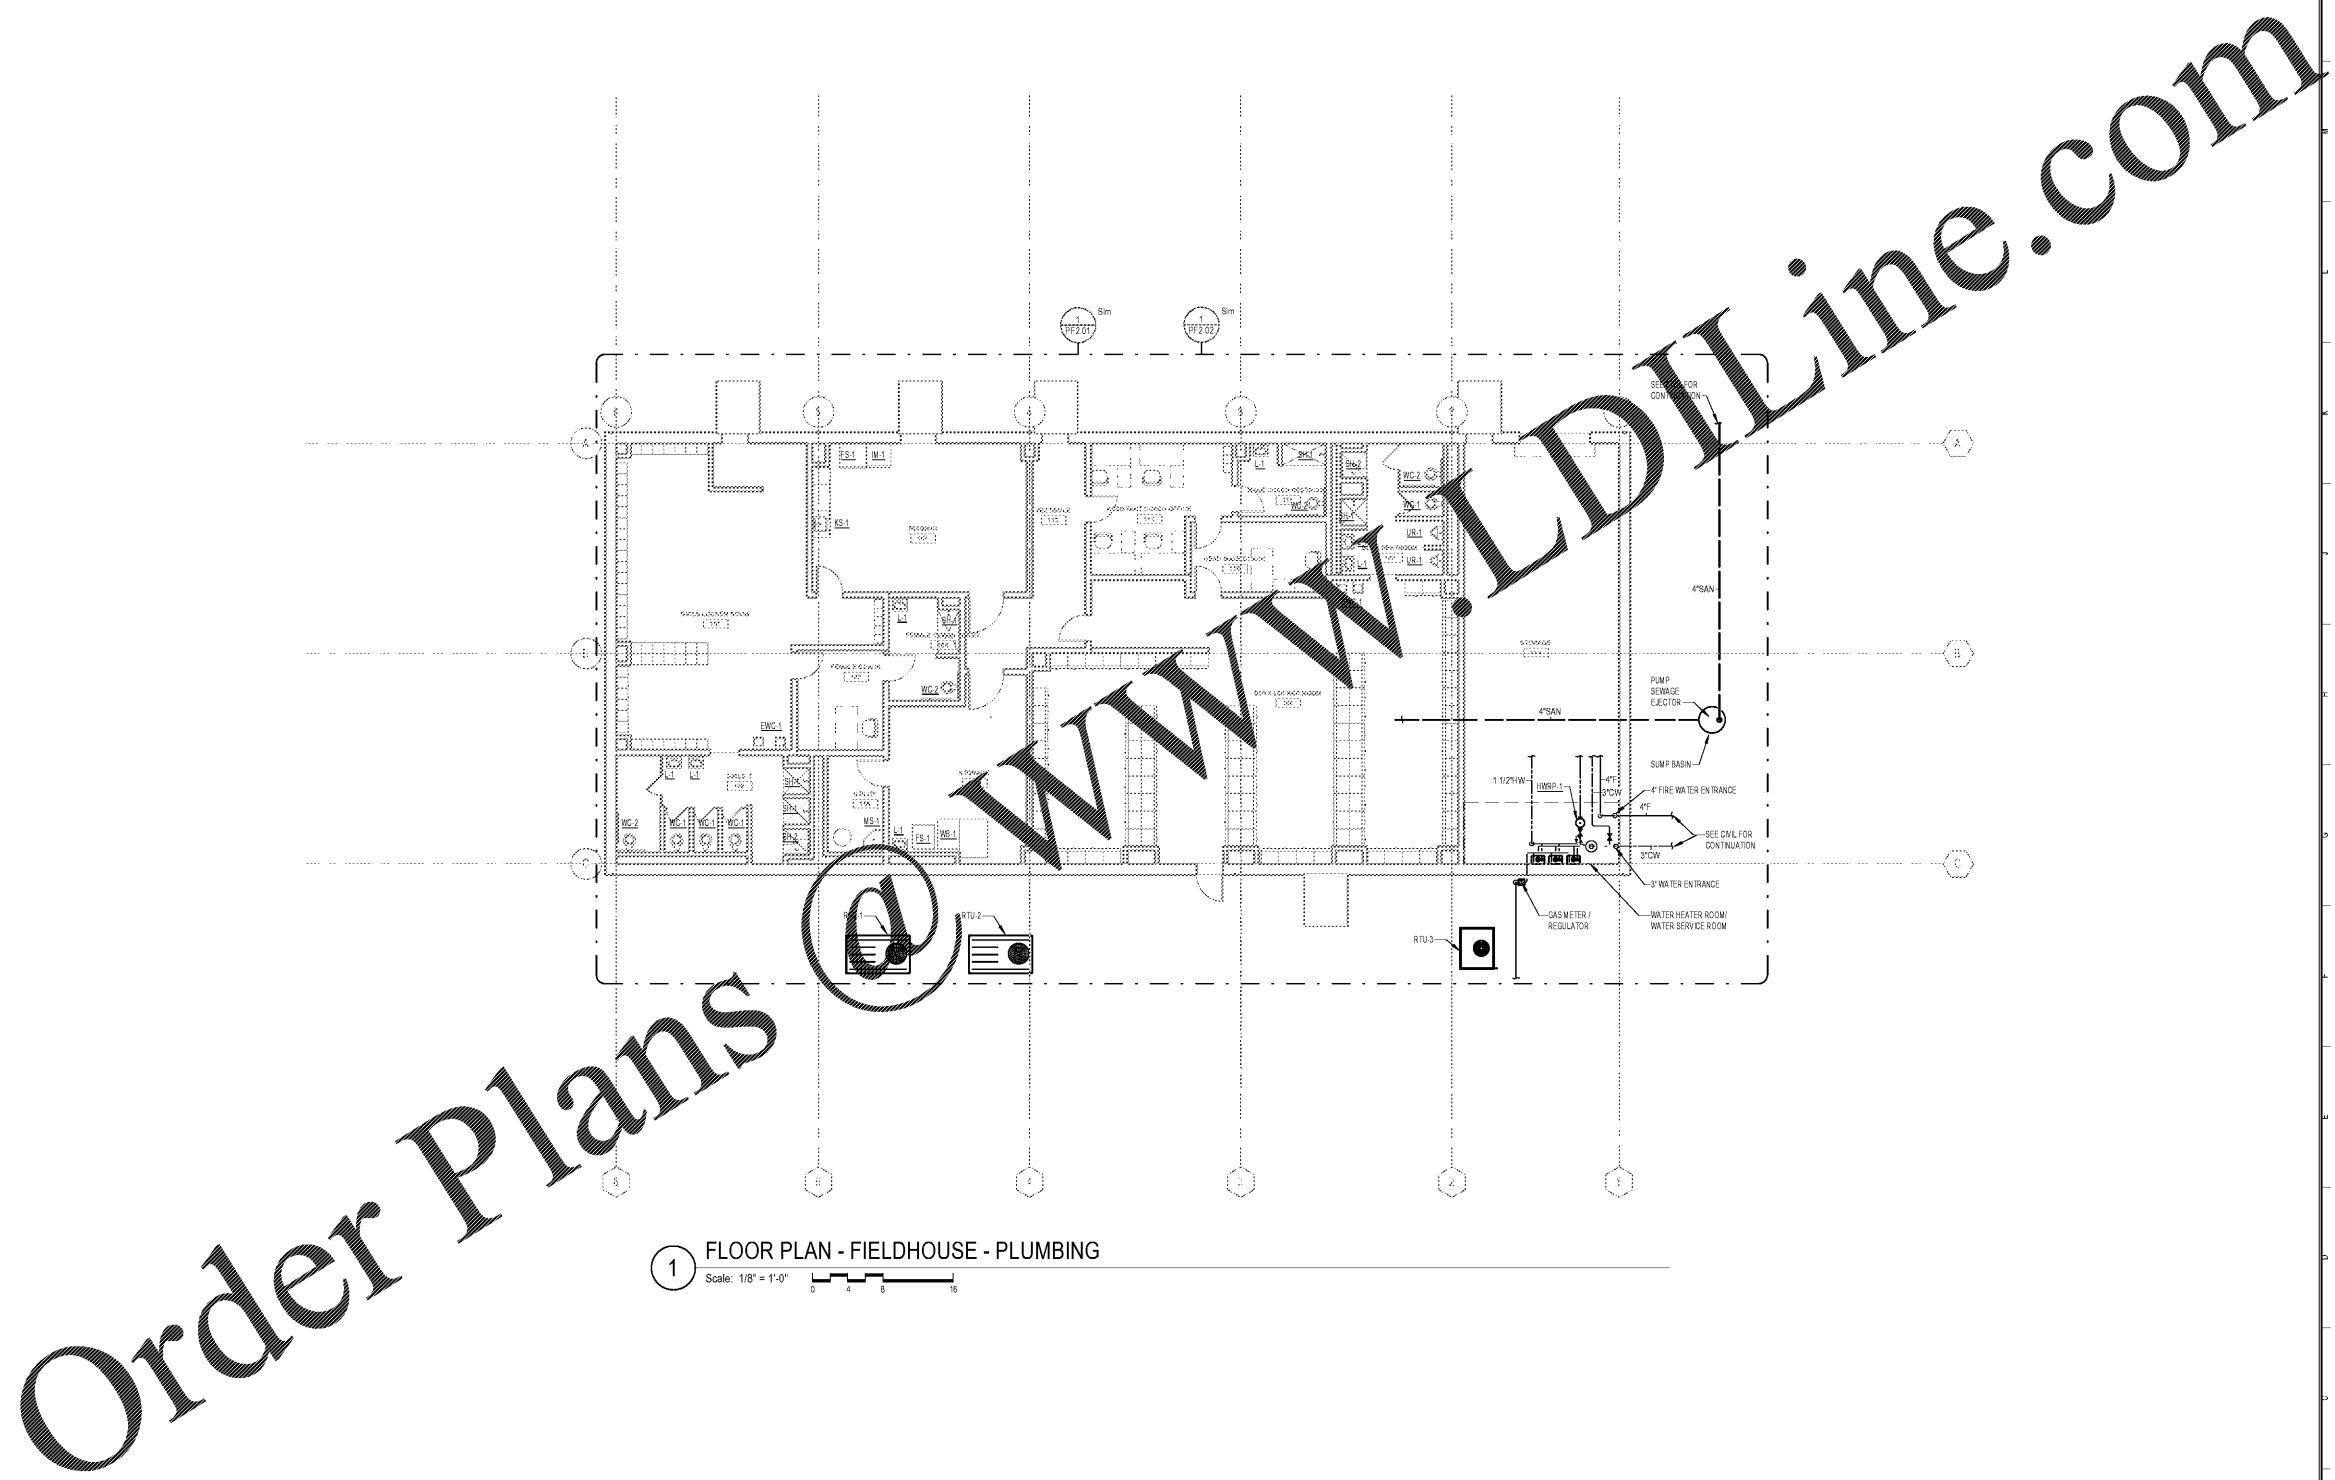

1 FLOOR PLAN - FIELDHOUSE - PLUMBING
Scale: 1/8" = 1'-0"

Order Plans

WWW.LDILine.com

PROJECT NUMBER: 20190224.01 PROJECT NAME: PEBBLEBROOK HS B007 - FIELDHOUSE
SHEET NUMBER: PF1.01 - FIELDHOUSE - PLUMBING
D:\Revit Projects\1810370_Pebblebrook B007_Fieldhouse_MEP_19_Central_EsterA.rvt
10/31/2019 11:59:26 AM

PEBBLEBROOK HS B007 -
FIELDHOUSE
DOE Facility Code 4066
FTE = 2787
IU = 143
991 OLD ALABAMA ROAD
MABLETON, GA 30126
COBB COUNTY SCHOOL DISTRICT
FIELDHOUSE - PLUMBING

DHS	20190224.01
Principal Charge	Project No.
DWG	11/04/19
Project Manager	Date
JMW	
Project Architect	
EIA	
Staff Architect	
	PF1.01

JSE Jordan & Skala Engineers
4275 Shalkeford Road, Suite 200 • Norcross, GA 30093
p 770 447 5547 • f 770 448 0262
Project Number: 1810370 Drawn By: EIA Checked By: JMW

ISSUED FOR CONSTRUCTION