




COOPER CARRY
THE CENTER FOR CONNECTIVE ARCHITECTURE

191 Peachtree Street NE
Suite 2400
Atlanta, GA 30303-1770
(404) 237-2000
coopercarry.com

0019 COOPER CARRY



ISSUANCES		
No.	Drawing Issue Description	Date
1	ISSUED FOR BID	11/04/19

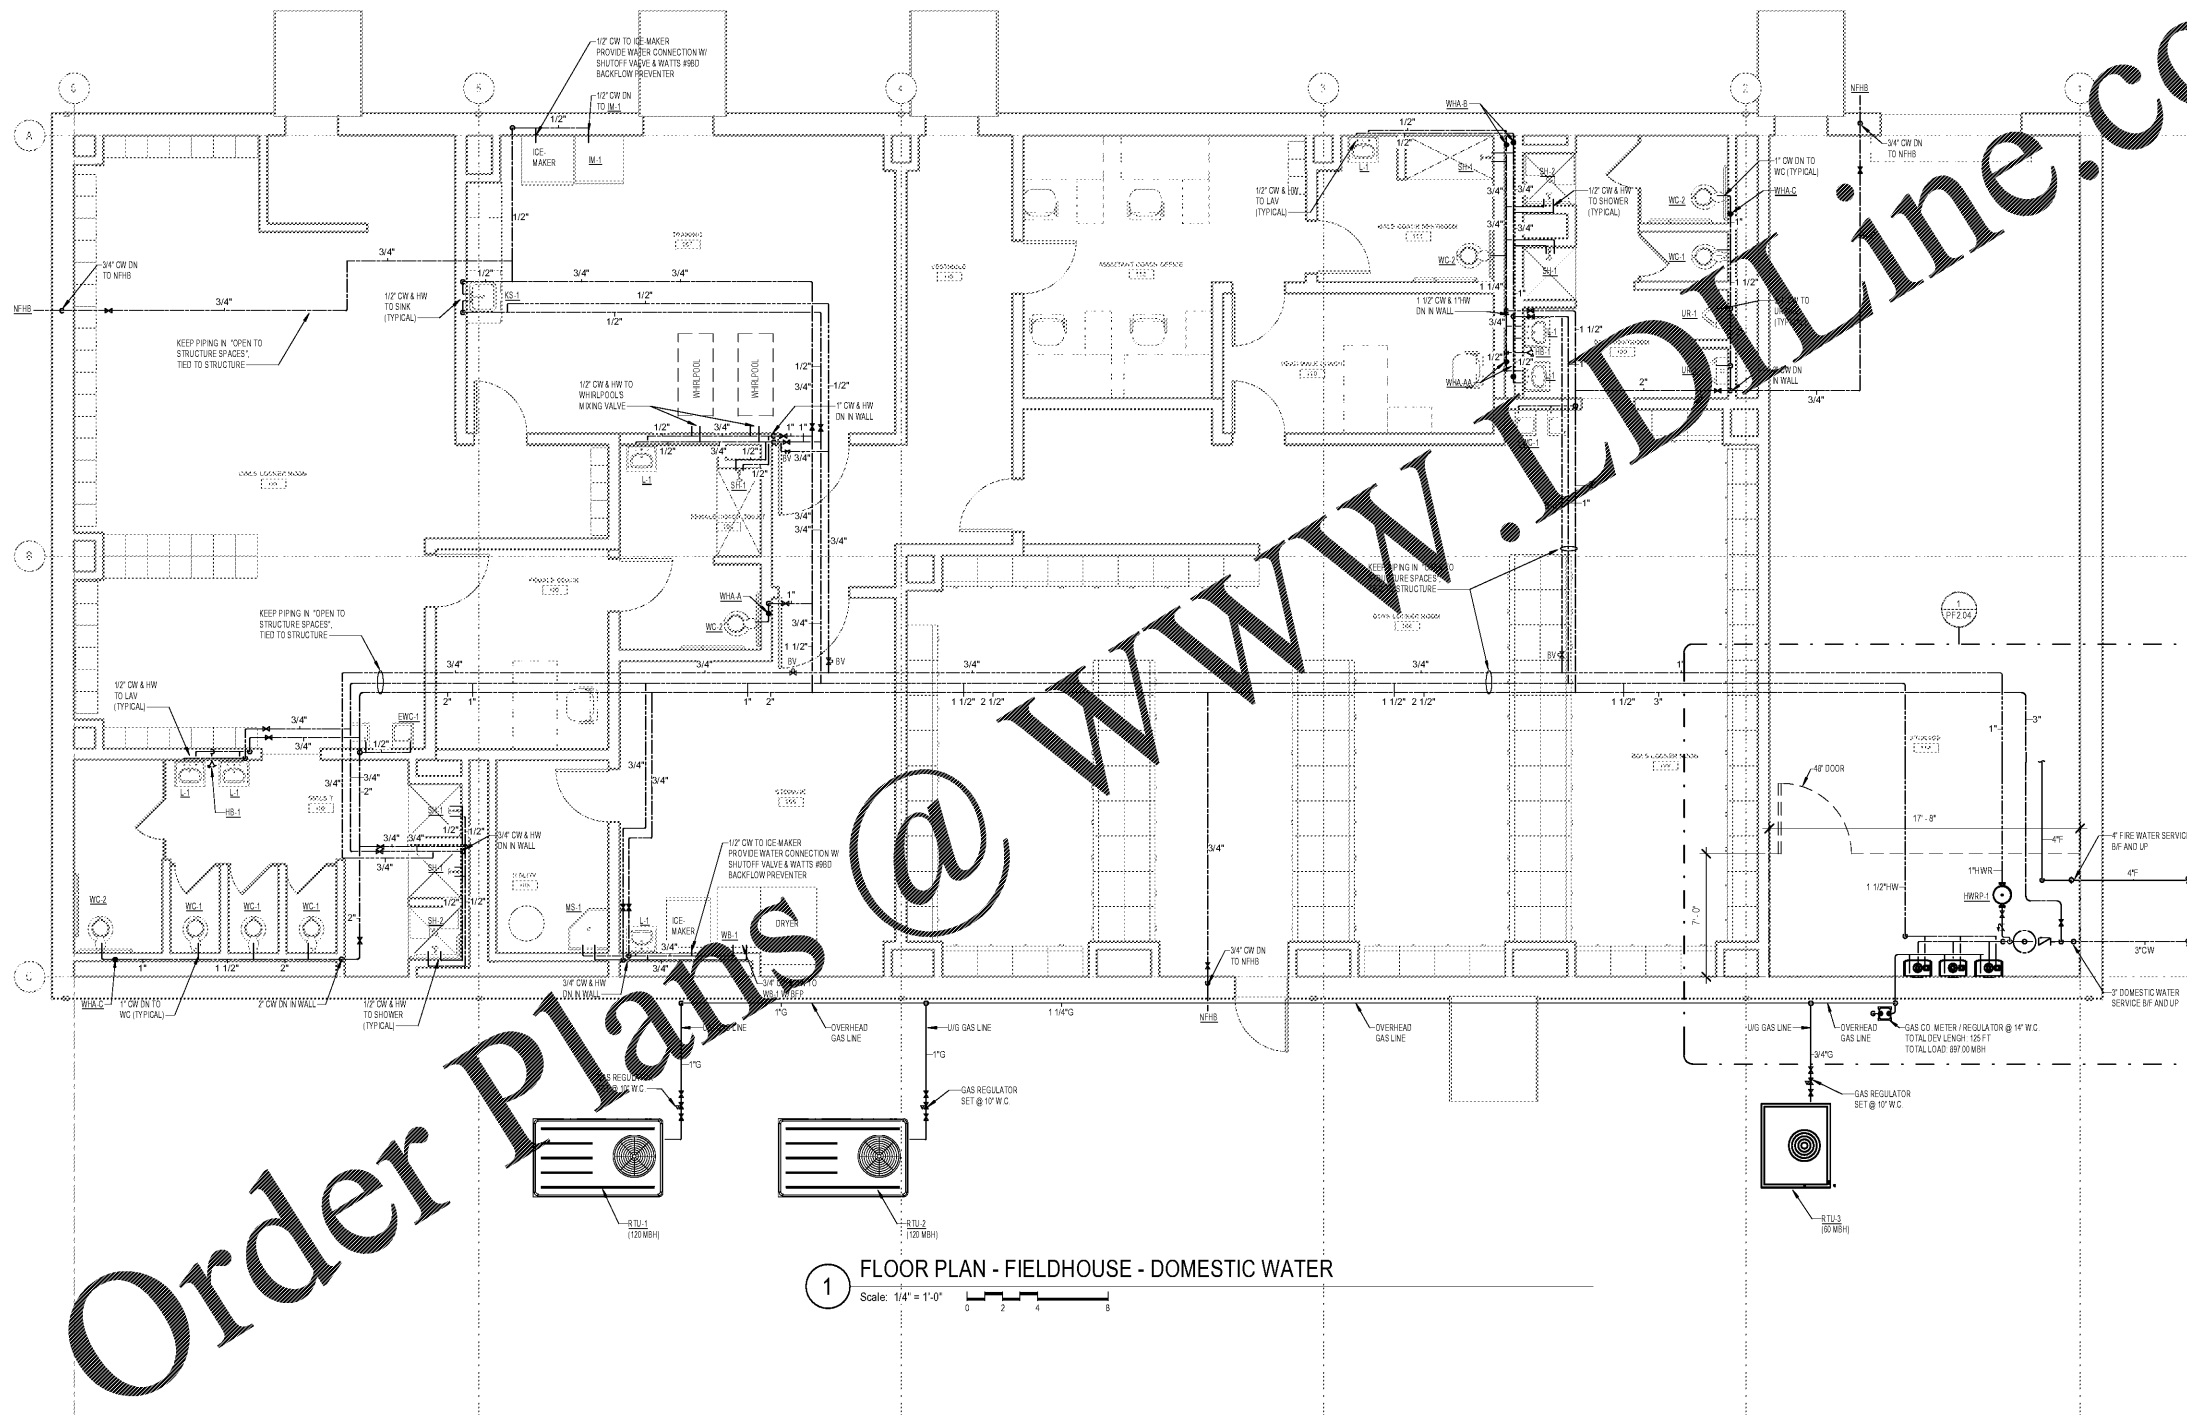

Order Plans @ WWW.LDILine.com

1 FLOOR PLAN - FIELDHOUSE - DOMESTIC WATER
Scale: 1/4" = 1'-0"

PROJECT NUMBER: 20190224.01 PROJECT NAME: PEBBLEBROOK HS B007 - FIELDHOUSE
SHEET NUMBER: PF2.01 - ENLARGED PLANS - PLUMBING
D:\Revit\Projects\1810370_Pebblebrook B007_Fieldhouse_MEP_19_Central_EsterA.rvt
10/31/2019 11:59:53 AM

PEBBLEBROOK HS B007 - FIELDHOUSE
DOE Facility Code 4066
FTE = 2787
IU = 143
991 OLD ALABAMA ROAD
MABLETON, GA 30126
COBB COUNTY SCHOOL DISTRICT
**ENLARGED PLANS
PLUMBING**

JSE Jordan & Skala Engineers
4275 Shalokford Road, Suite 200 • Norcross, GA 30093
p 770 447 5547 • f 770 448 0262
Project Number: 1810370 Drawn By: EIA Checked By: JMW

DHS	20190224.01
Principal Charge	
DWG	11/04/19
Project Manager	isa
JMW	
Project Architect	
EIA	
Staff Architect	

PF2.01

ISSUED FOR CONSTRUCTION