



COOPER CARRY
THE CENTER FOR CONNECTIVE ARCHITECTURE

191 Peachtree Street NE
Suite 2400
Atlanta, GA 30303-1770
(404) 257-2000
coopercarry.com

©2019 COOPER CARRY




| ISSUANCES | | |
|-----------|---------------------------|----------|
| No. | Drawing Issue Description | Date |
| 1 | ISSUED FOR B/D | 11/04/19 |

GENERAL NOTES:

- COORDINATE WITH GA POWER FOR EXACT LOCATION & INSTALLATION REQUIREMENTS OF ALL UTILITY TRANSFORMERS AND UNDERGROUND ELECTRICAL SERVICES.

| KEYNOTE | DESCRIPTION |
|---------|--|
| 1 | NEW UTILITY TRANSFORMER, COORDINATE EXACT LOCATION AND INSTALLATION DETAIL WITH GA POWER AS REQUIRED. |
| 2 | TWO (2) - 3" CONDUITS TO EXISTING BETTY GREY BUILDING FOR ALL SYSTEMS WIRING (DATA, TELEPHONES, SECURITY, FIRE ALARM, INTERCOM AND TV). |
| 3 | TWO (2) - 3" CONDUITS EXTEND 5 FEET BEYOND BUILDING EXTERIOR FOR FUTURE ELECTRICAL. |
| 4 | PROVIDE ONE (1) - 2" CONDUIT WITH WEATHERHOOD ON ROOF DIRECTLY ABOVE INTERCOM CONSOLE FOR FUTURE WIRING TO PORTABLE CLASSROOMS. |
| 5 | PROVIDE AND INSTALL 3/4" RGSC WITH #14 AWG STRANDED RED, BLACK, BLUE, AND WHITE CONDUCTORS FROM 200A MAIN DISCONNECT SWITCH TO POWER COMPANY TRANSFORMER PAD LOCATION - SHALL BE STUBBED ADJACENT TO TRANSFORMER PAD AND 1-FOOT ABOVE FINISHED GRADE WITH A 6"X6" WEATHER PROOF GALVANIZED JUNCTION BOX. |
| 6 | GROUND ROD TRIAD. |

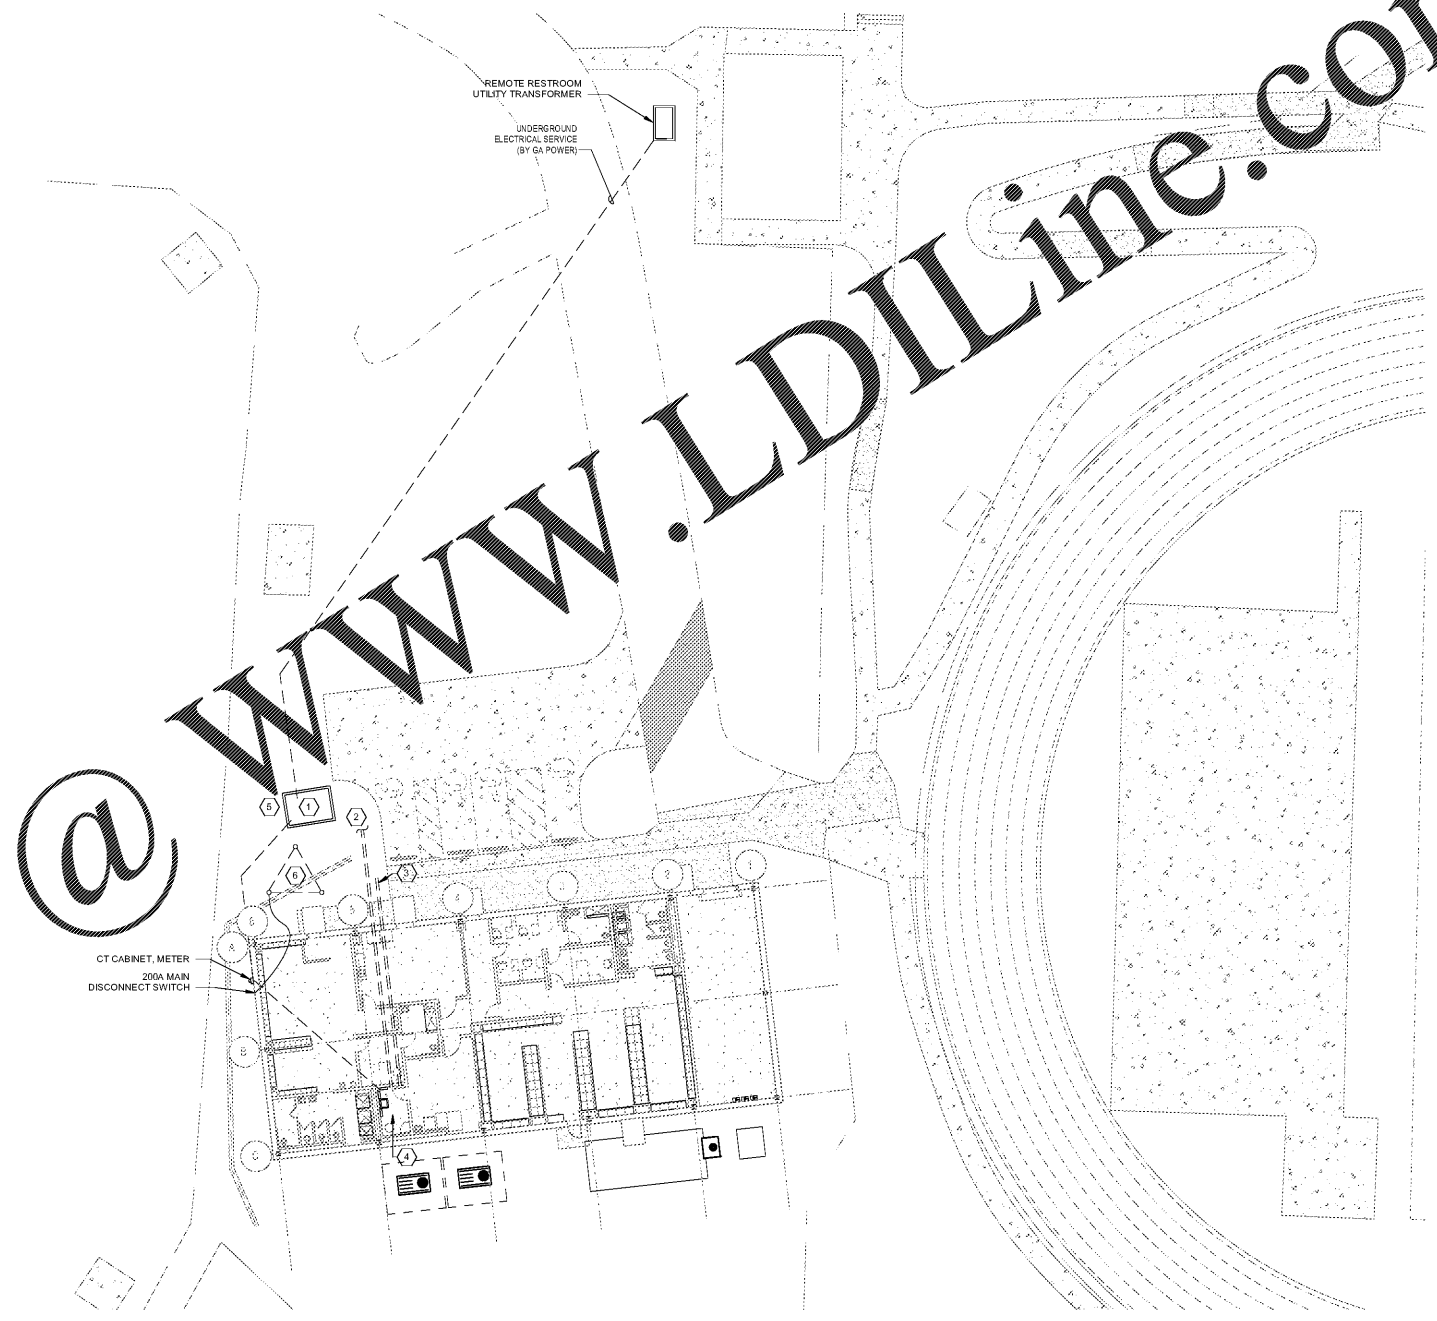

1 SITE PLAN - ELECTRICAL
Scale: 1/16" = 1'-0"

Order Plans @ www.LDILine.com

PROJECT NUMBER: 20190224.01 PROJECT NAME: PEBBLEBROOK HS B007 - FIELDHOUSE
SHEET NUMBER: EF1.00 - FIELDHOUSE - SITE ELECTRICAL
D:\Revit\Projects\1810370_Pebblebrook B007_Fieldhouse_MEP_r19_Central_DuvV.rvt
10/31/2019 12:06:01 PM

PEBBLEBROOK HS B007 - FIELDHOUSE
DOE Facility Code 4066
FTE = 2787
IU = 143
991 OLD ALABAMA ROAD
MABLETON, GA 30126
COBB COUNTY SCHOOL DISTRICT
FIELDHOUSE - SITE ELECTRICAL

| | |
|-------------------|---------------|
| TW | 20190224.01 |
| Principal Charge | |
| DWG | 10/25/19 |
| Project Manager | |
| WRB | |
| Project Architect | |
| DV | |
| Staff Architect | |
| | EF1.00 |

JSE Jordan & Skala Engineers
4275 Shackleford Road, Suite 200 • Norcross, GA 30093
p. 770.447.8547 • f. 770.448.0262
Project Number: 1810370 Drawn By: DV Checked By: WRB

ISSUED FOR CONSTRUCTION