




COOPER CARRY
THE CENTER FOR CONNECTIVE ARCHITECTURE

191 Peachtree Street NE
Suite 2400
Atlanta, GA 30303-1770
(404) 257-2000
coopercarry.com


©2019 COOPER CARRY

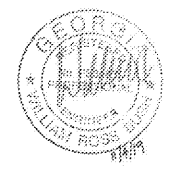

ISSUANCES		
No.	Drawing Issue Description	Date
1	ISSUED FOR B/D	11/04/19

GENERAL NOTES (FIRE ALARM):

1. PROVIDE STI-1100 COVER FOR ALL FIRE ALARM PULL STATION.
2. PROVIDE WIRE GUARD FOR ALL FIRE ALARM HORN STROBE DEVICES.
3. DUCT MOUNTED SMOKE DETECTORS SHALL BE WIRED TO SHUT DOWN THE UNIT WHERE THEY ARE MOUNTED. DO NOT SHUT DOWN THE ENTIRE HVAC SYSTEM.
4. COORDINATE WEATHER HEAD FLASHING DETAILS WITH SPECIFIED ROOF SYSTEMS.
5. LOCATE A 6"x6"x4" JUNCTION BOX ABOVE THE CEILING NEAR AN EXTERIOR WALL WITH A 2" CONDUIT WEATHER HEAD THROUGH THE ROOF NEAREST TO EACH AREA OF PLANNED FUTURE ADDITIONS AND/OR PORTABLE CLASSROOMS.
6. INTERFACE WITH INTERCOM SYSTEM OVERRIDE AND THE SECURITY SYSTEM.

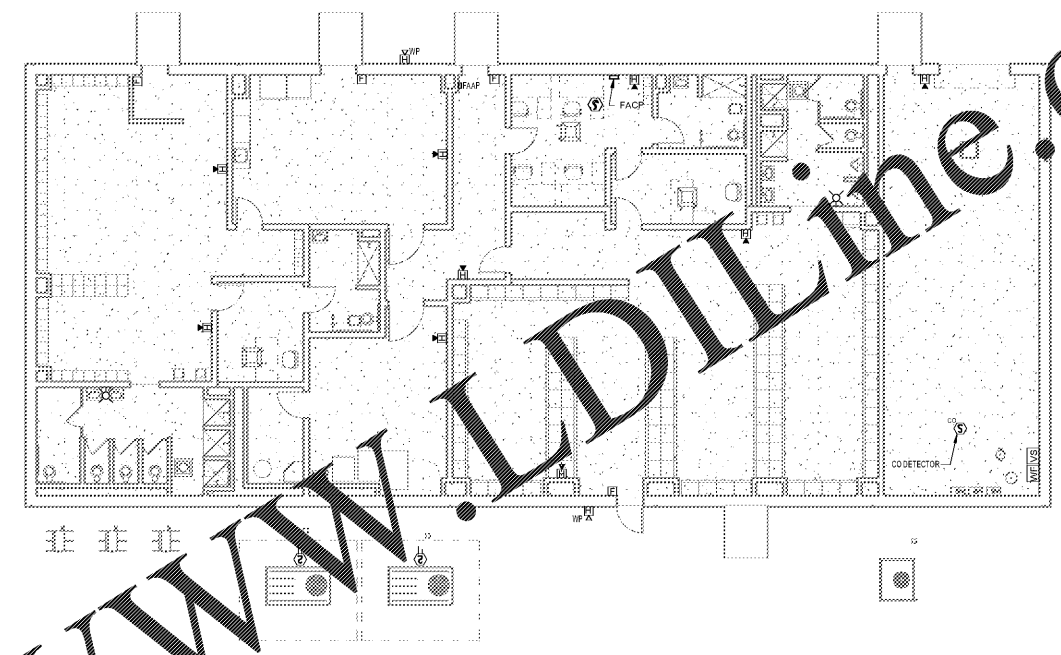

1 FLOOR PLAN - FIRE ALARM
Scale: 1/8" = 1'-0"

Order Plans @ www.LDILine.com

PROJECT NUMBER: 20190224.01 PROJECT NAME: PEBBLEBROOK HS B007 - FIELDHOUSE
SHEET NUMBER: EF1.02 - FIELDHOUSE - FIRE ALARM
D:\Revit\Projects\1810370_Pebblebrook B007_Fieldhouse_MEP_r19_Central_DuvV.rvt
10/31/2019 12:06:09 PM

PEBBLEBROOK HS B007 -
FIELDHOUSE
DOE Facility Code 4066
FTE = 2787
IU = 143
991 OLD ALABAMA ROAD
MABLETON, GA 30126
COBB COUNTY SCHOOL DISTRICT
FIELDHOUSE - FIRE ALARM

JSE Jordan & Skala Engineers
4275 Shackleford Road, Suite 200 • Norcross, GA 30093
p. 770.447.5547 • f. 770.448.0262
Project Number: 1810370 Drawn By: DV Checked By: WRB

TM	20190224.01
Principal Charge	
DWG	10/25/19
Project Manager	
WRB	
Project Architect	
DV	
Staff Architect	
	EF1.02

ISSUED FOR CONSTRUCTION