


Order Plans @

WWW.DIline.com

- KEYED NOTES:**
1. RECEPTACLE MOUNTED AT 44" A.F.F. TO THE TOP OF BOX. VERIFY MOUNTING HEIGHT WITH ARCHITECT AND CASEWORK.
 2. RECEPTACLE MOUNTED AT 46" A.F.F. TO THE TOP OF BOX. VERIFY MOUNTING HEIGHT WITH ARCHITECT AND CASEWORK.
 3. RECEPTACLE MOUNTED AT 24" A.F.F. TO THE TOP OF BOX. VERIFY MOUNTING HEIGHT WITH ARCHITECT AND CASEWORK.
 4. RECEPTACLE MOUNTED IN RECESSED WALL BOX FOR WALL MOUNTED TIME CLOCK. VERIFY MOUNTING HEIGHT OF TIME CLOCK PRIOR TO ROUGH-IN.
 5. COORDINATE EXACT LOCATION OF FLOORBOX WITH ARCHITECT/TOWNER PRIOR TO ROUGH-IN.

- MECHANICAL EQUIPMENT NOTES:**
1. COORDINATE WITH MANUFACTURER'S CUTSHEETS OR NAMEPLATE DATA AND ADJUST OVERCURRENT PROTECTION AS NEEDED TO PROTECT EQUIPMENT PER MANUFACTURER'S RECOMMENDATIONS AND TO COMPLY WITH N.E.C. AND LOCAL CODES.
 2. ALL DISCONNECTS SHALL BE HEAVY DUTY TYPE.
 3. ALL FUSES SHALL BE SIZED PER NAMEPLATE DATA.
 4. PROVIDE FUSES IN DISCONNECT PER MECHANICAL EQUIPMENT NAMEPLATE OR MANUFACTURER'S REQUIREMENTS.
 5. MULTIPLE DUCTLESS MINI-SPLIT SYSTEM MECHANICAL UNITS CAN BE ON THE SAME CIRCUIT. CONTRACTOR SHALL ROUTE CIRCUIT TO UNITS IN MOST ECONOMICAL ORDER FOLLOWING THE SPECIFICATIONS AND THE N.E.C.
 6. MOUNT MANUAL MOTOR START SWITCH NEAR UNIT ABOVE ACCESSIBLE CEILING SPACE OR 48" A.F.F. TO THE TOP OF THE BOX AND LABEL AS NECESSARY.

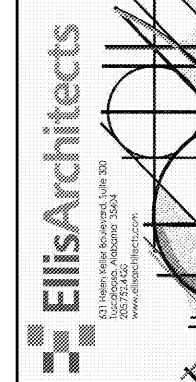


New Construction for:
BIBB COUNTY COURTHOUSE ANNEX
8 Court Square West
Centreville, Alabama



Copyright © 2019
Ellis Architects, Inc.
Ellis Architects, Inc. maintains all intellectual rights and ownership of all information contained on these documents. Ellis Architects, Inc. and its consultants shall be deemed the authors and owners of their respective instruments of service and shall retain all common law, statutory and other reserved rights, including copyrights. This document shall not be reproduced without the written authorization of Ellis Architects.
Do Not Scale From Drawings.
Contractor must verify all dimensions prior to construction.

JOB No.	18004
DOCUMENT	DATE
FINAL CDS	09/06/2019
DRAWN BY:	JAM/JR

POWER PLAN
E3.1

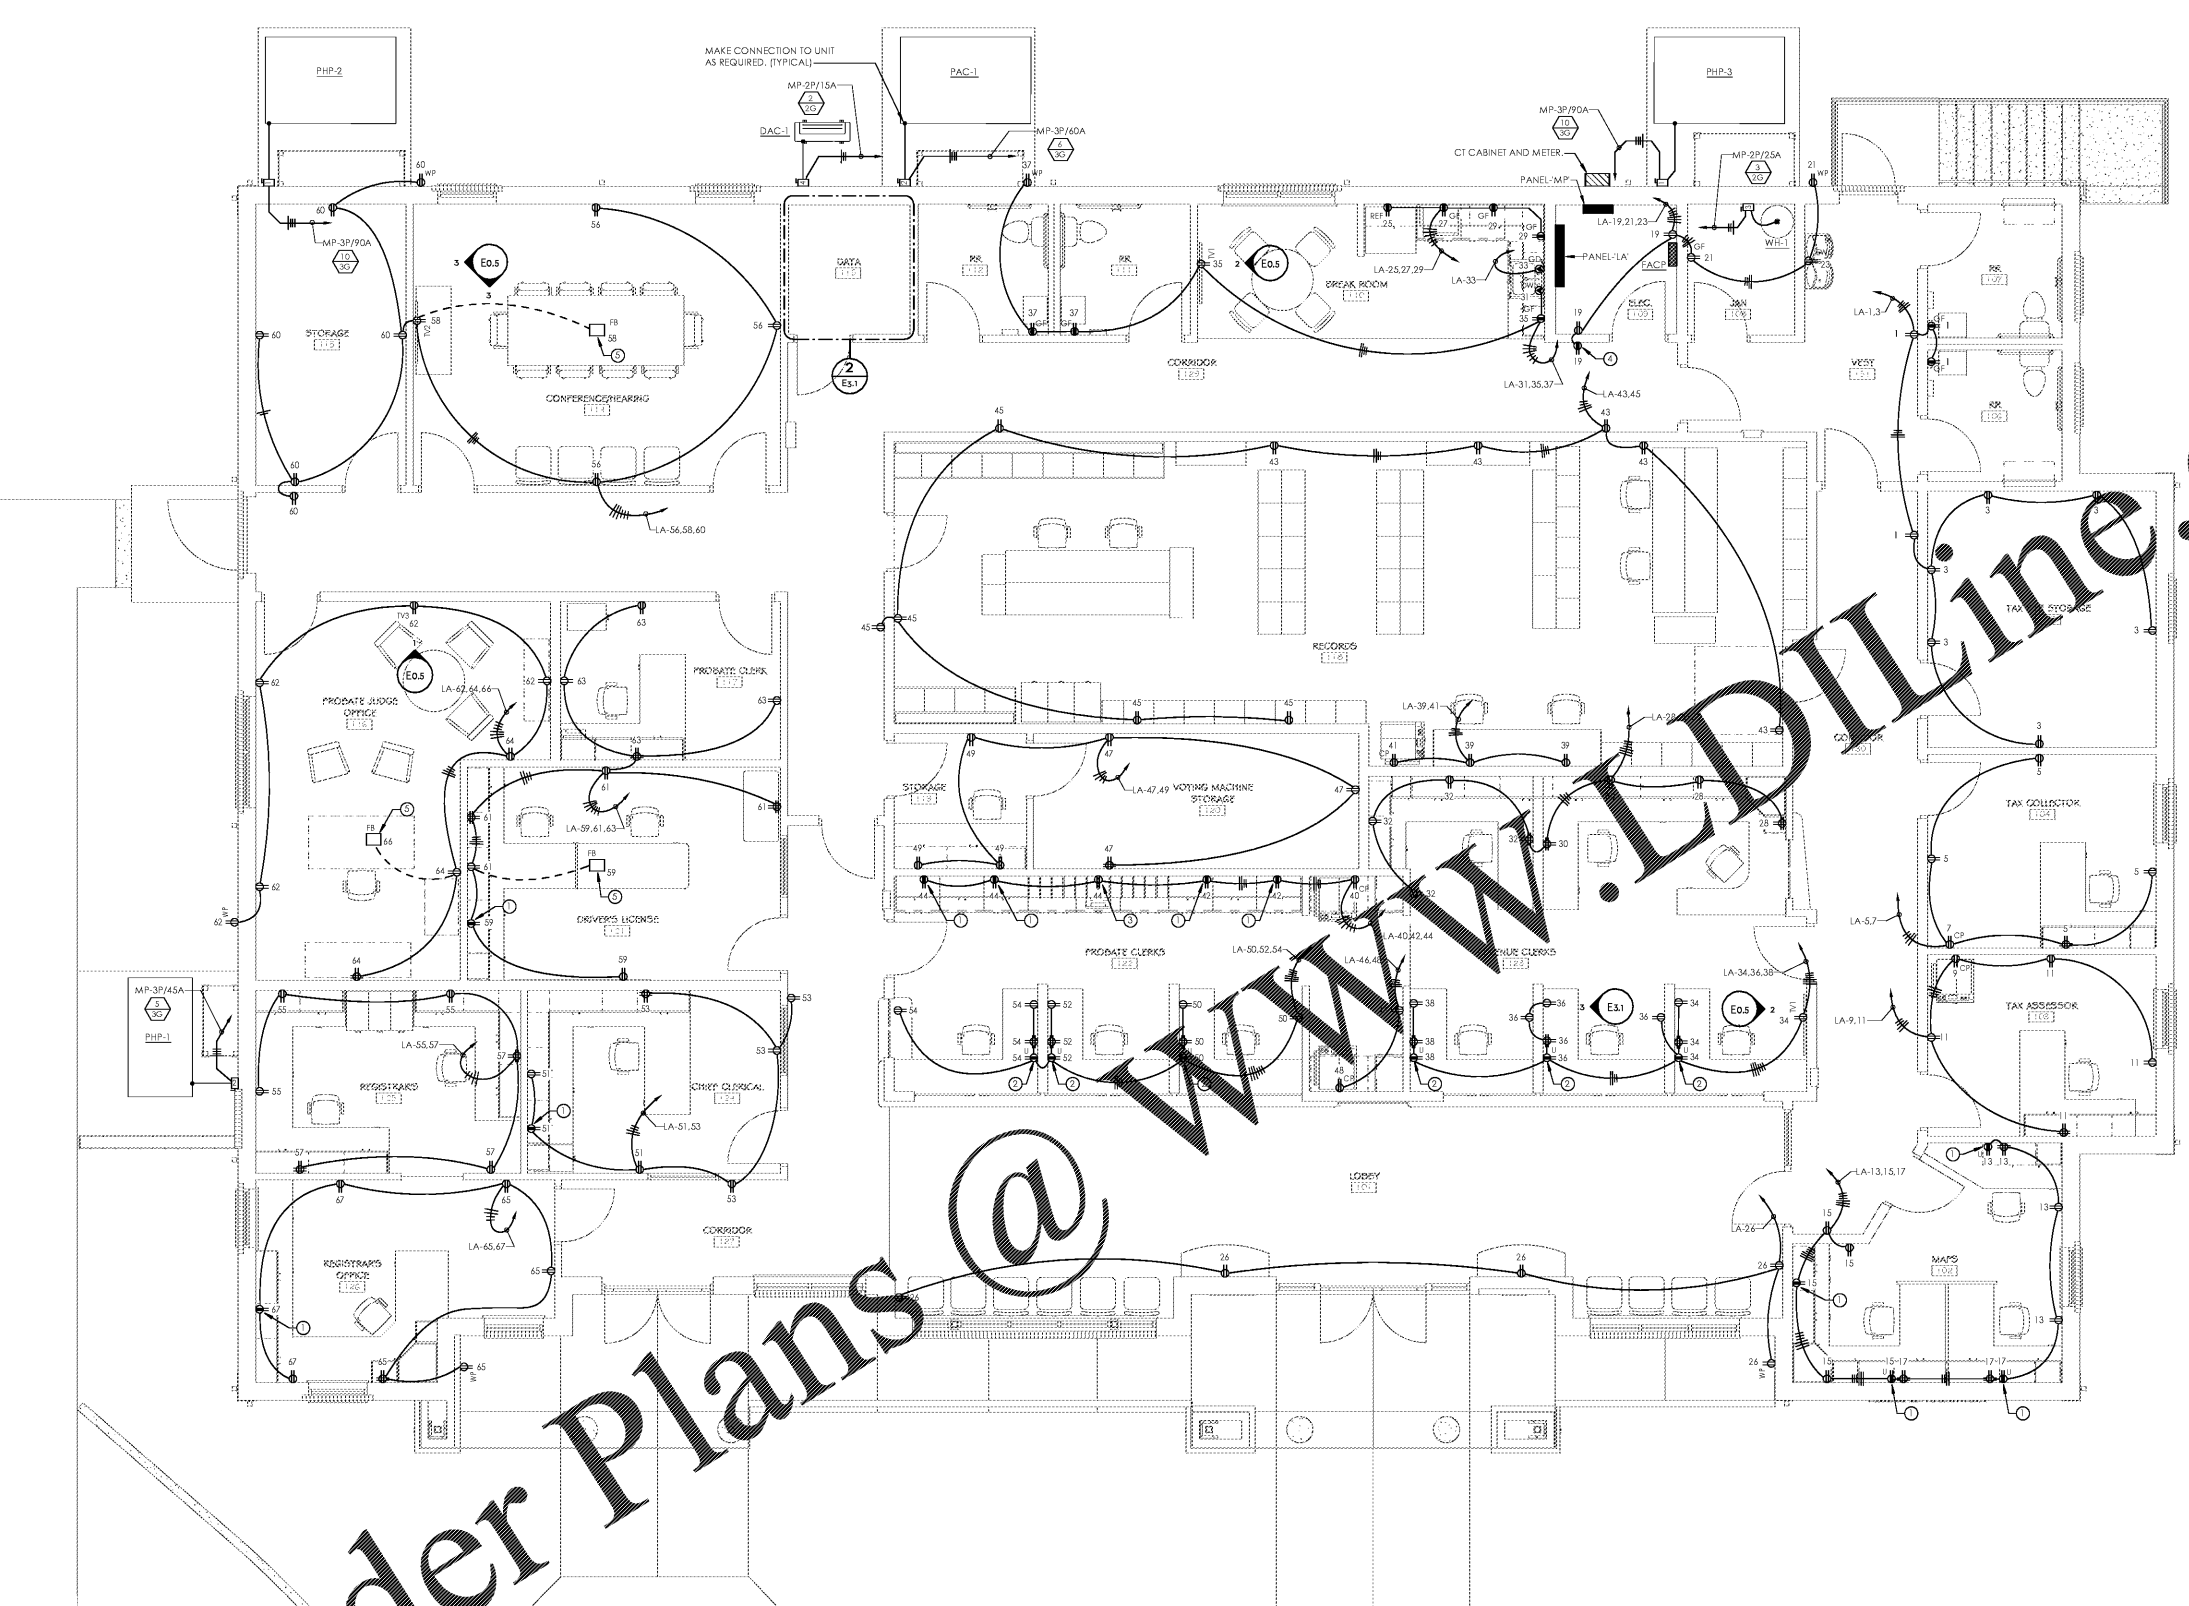

1 POWER PLAN
3/4" = 1'-0"

