


COLUMBUS, GA AAA RETAIL CENTER

6201 Veterans Pkwy, Suite C
Columbus, GA 31909

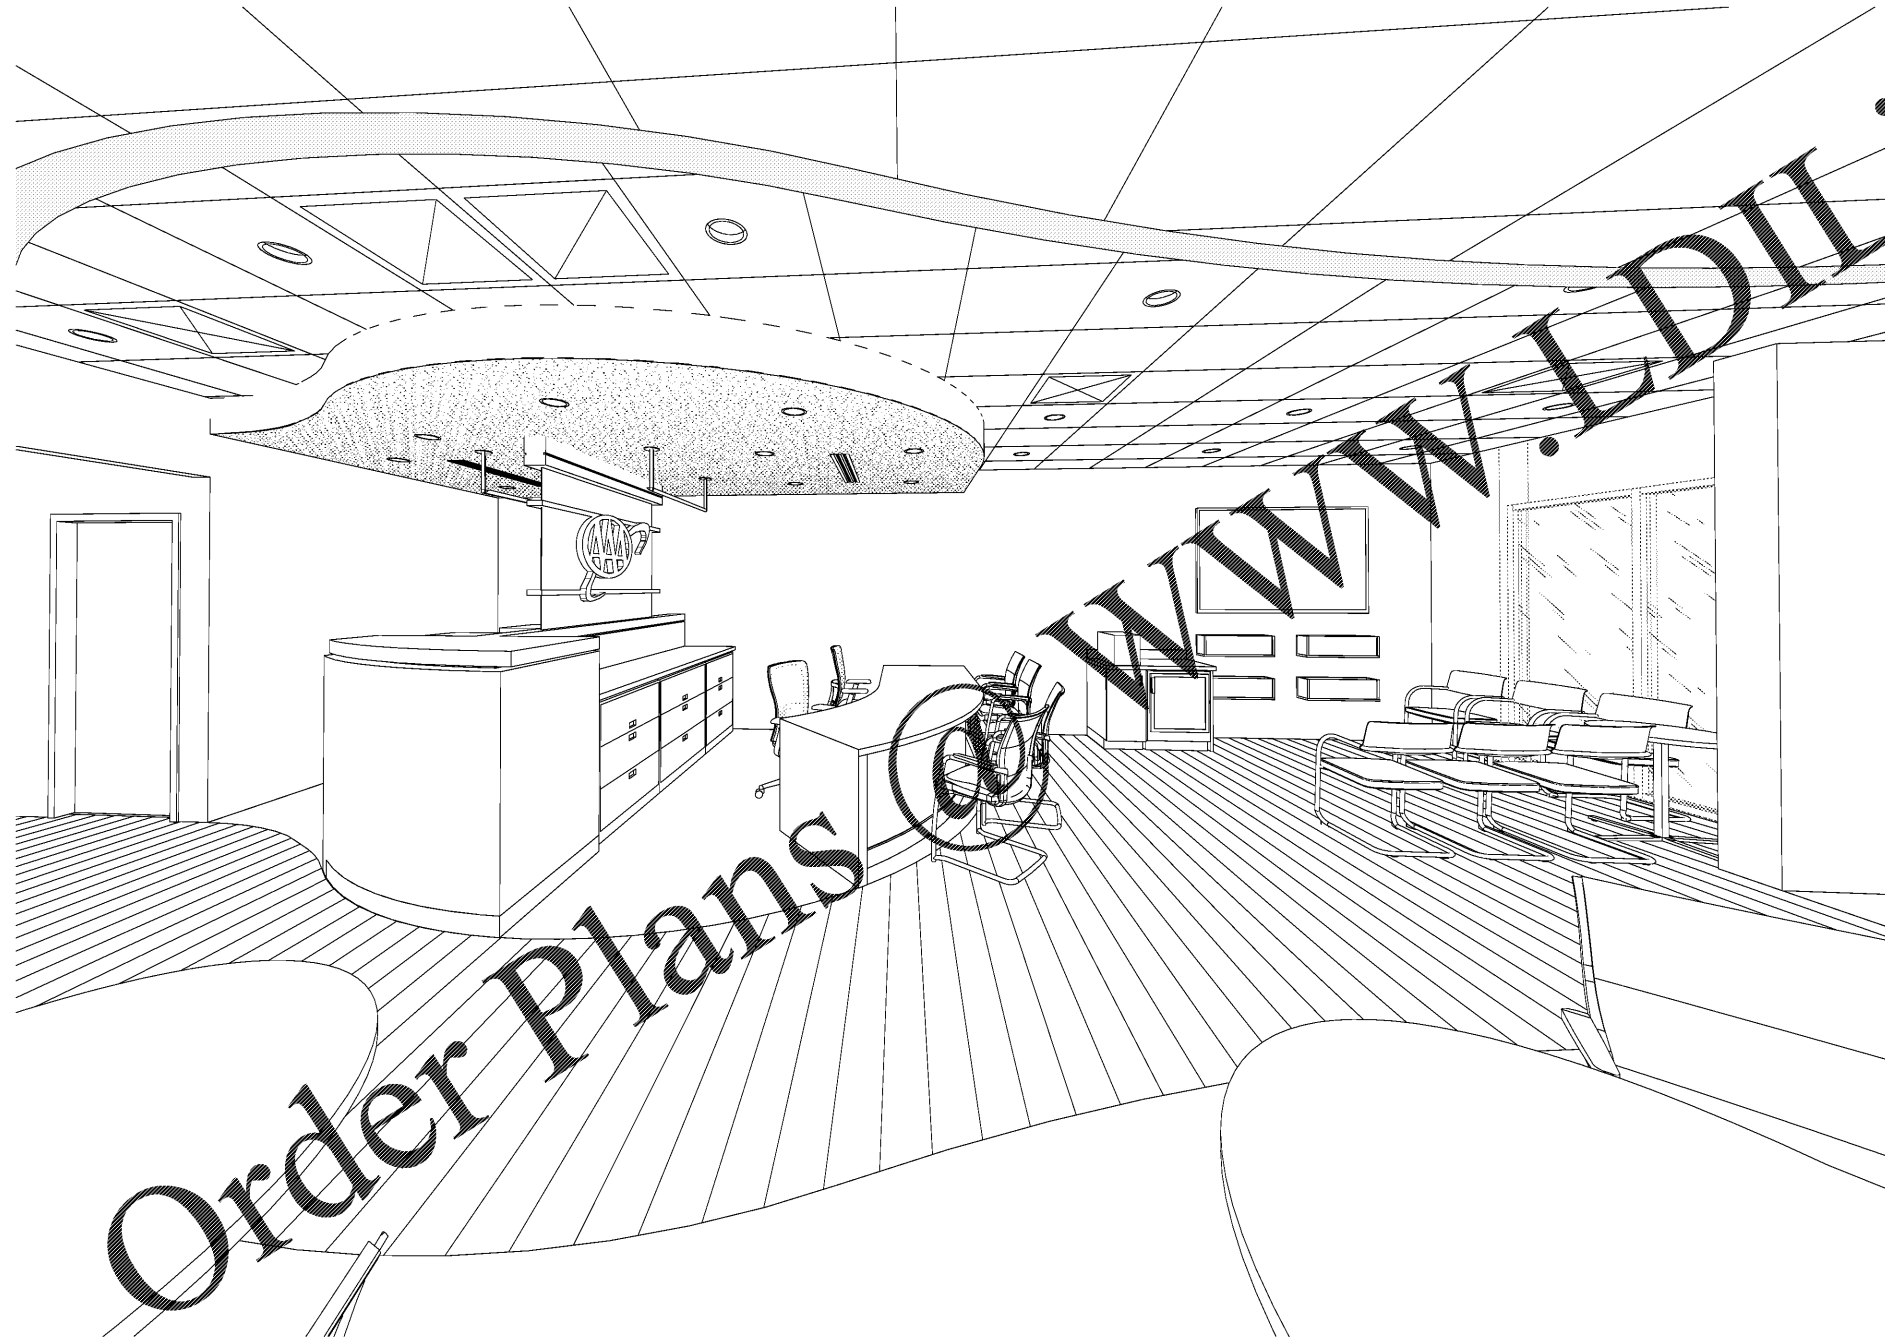

Order Plans @

DRAWING INDEX

GENERAL	
G-000	COVER
G-001	PROJECT INFORMATION
G-101	LIFE SAFETY PLAN
ARCHITECTURAL	
A-101	DEMOLITION PLAN
A-111	CONSTRUCTION PLAN
A-121	REFLECTED CEILING PLAN
A-141	OUTLET AND EQUIPMENT PLAN
A-151	FINISH PLAN
A-211	INTERIOR ELEVATIONS
A-231	DETAILS
A-401	ENLARGED PLANS AND SECTION
A-601	DOOR SCHEDULE AND DETAILS
PLUMBING	
P-001	LEGEND, DETAILS, SCHEDULES
P-101	FLOOR PLANS - PLUMBING
MECHANICAL	
M-001	MECHANICAL SPECIFICATIONS
M-102	MECHANICAL SCHEDULES & DETAILS
M-101	FLOOR PLAN - MECHANICAL
ELECTRICAL	
E-001	ELECTRICAL SPECIFICATIONS
E-002	ELECTRICAL SYMBOLS & SCHEDULES
E-003	LIGHTING SCHEDULES & DETAILS
E-100	DEMOLITION PLAN - ELECTRICAL
E-101	FLOOR PLAN - LIGHTING
E-201	FLOOR PLAN - POWER
E-202	FLOOR PLAN - HVAC & PLUMBING CONNECTIONS
E-301	SCHEDULES & RISERS

COLUMBUS, GA

AAA AUTO CLUB GROUP

progressive | ae

6201 Veterans Pkwy, Suite C, Columbus, GA 31909

PROGRESSIVE ARCHITECTURE ENGINEERS, P.C.
330 South Tryon St., Suite 500 - Charlotte, NC 28202 - Tel: 704.751.8500 | www.progressiveae.com

If this document is used without the signature of the professional engineer, it is not valid. The user assumes all liability for the use of this document. The user agrees to hold the professional engineer harmless for any claims, damages, or expenses that may be incurred by the user as a result of the use of this document.

ISSUANCE

ISSUED FOR CONSTRUCTION
2019/11/13

REVISIONS

NO.	DATE	DESCRIPTION
-----	------	-------------

FILE NUMBER	79890016
PROJECT MANAGER	JE
PROFESSIONAL	GWJ
DRAWN BY	ME
CHECKED BY	MB

COVER
G-000