
 


CONYERS, GA 30012
 DB 4779 PG 266
 PB 34 PG 183
 PARCEL 054001017J

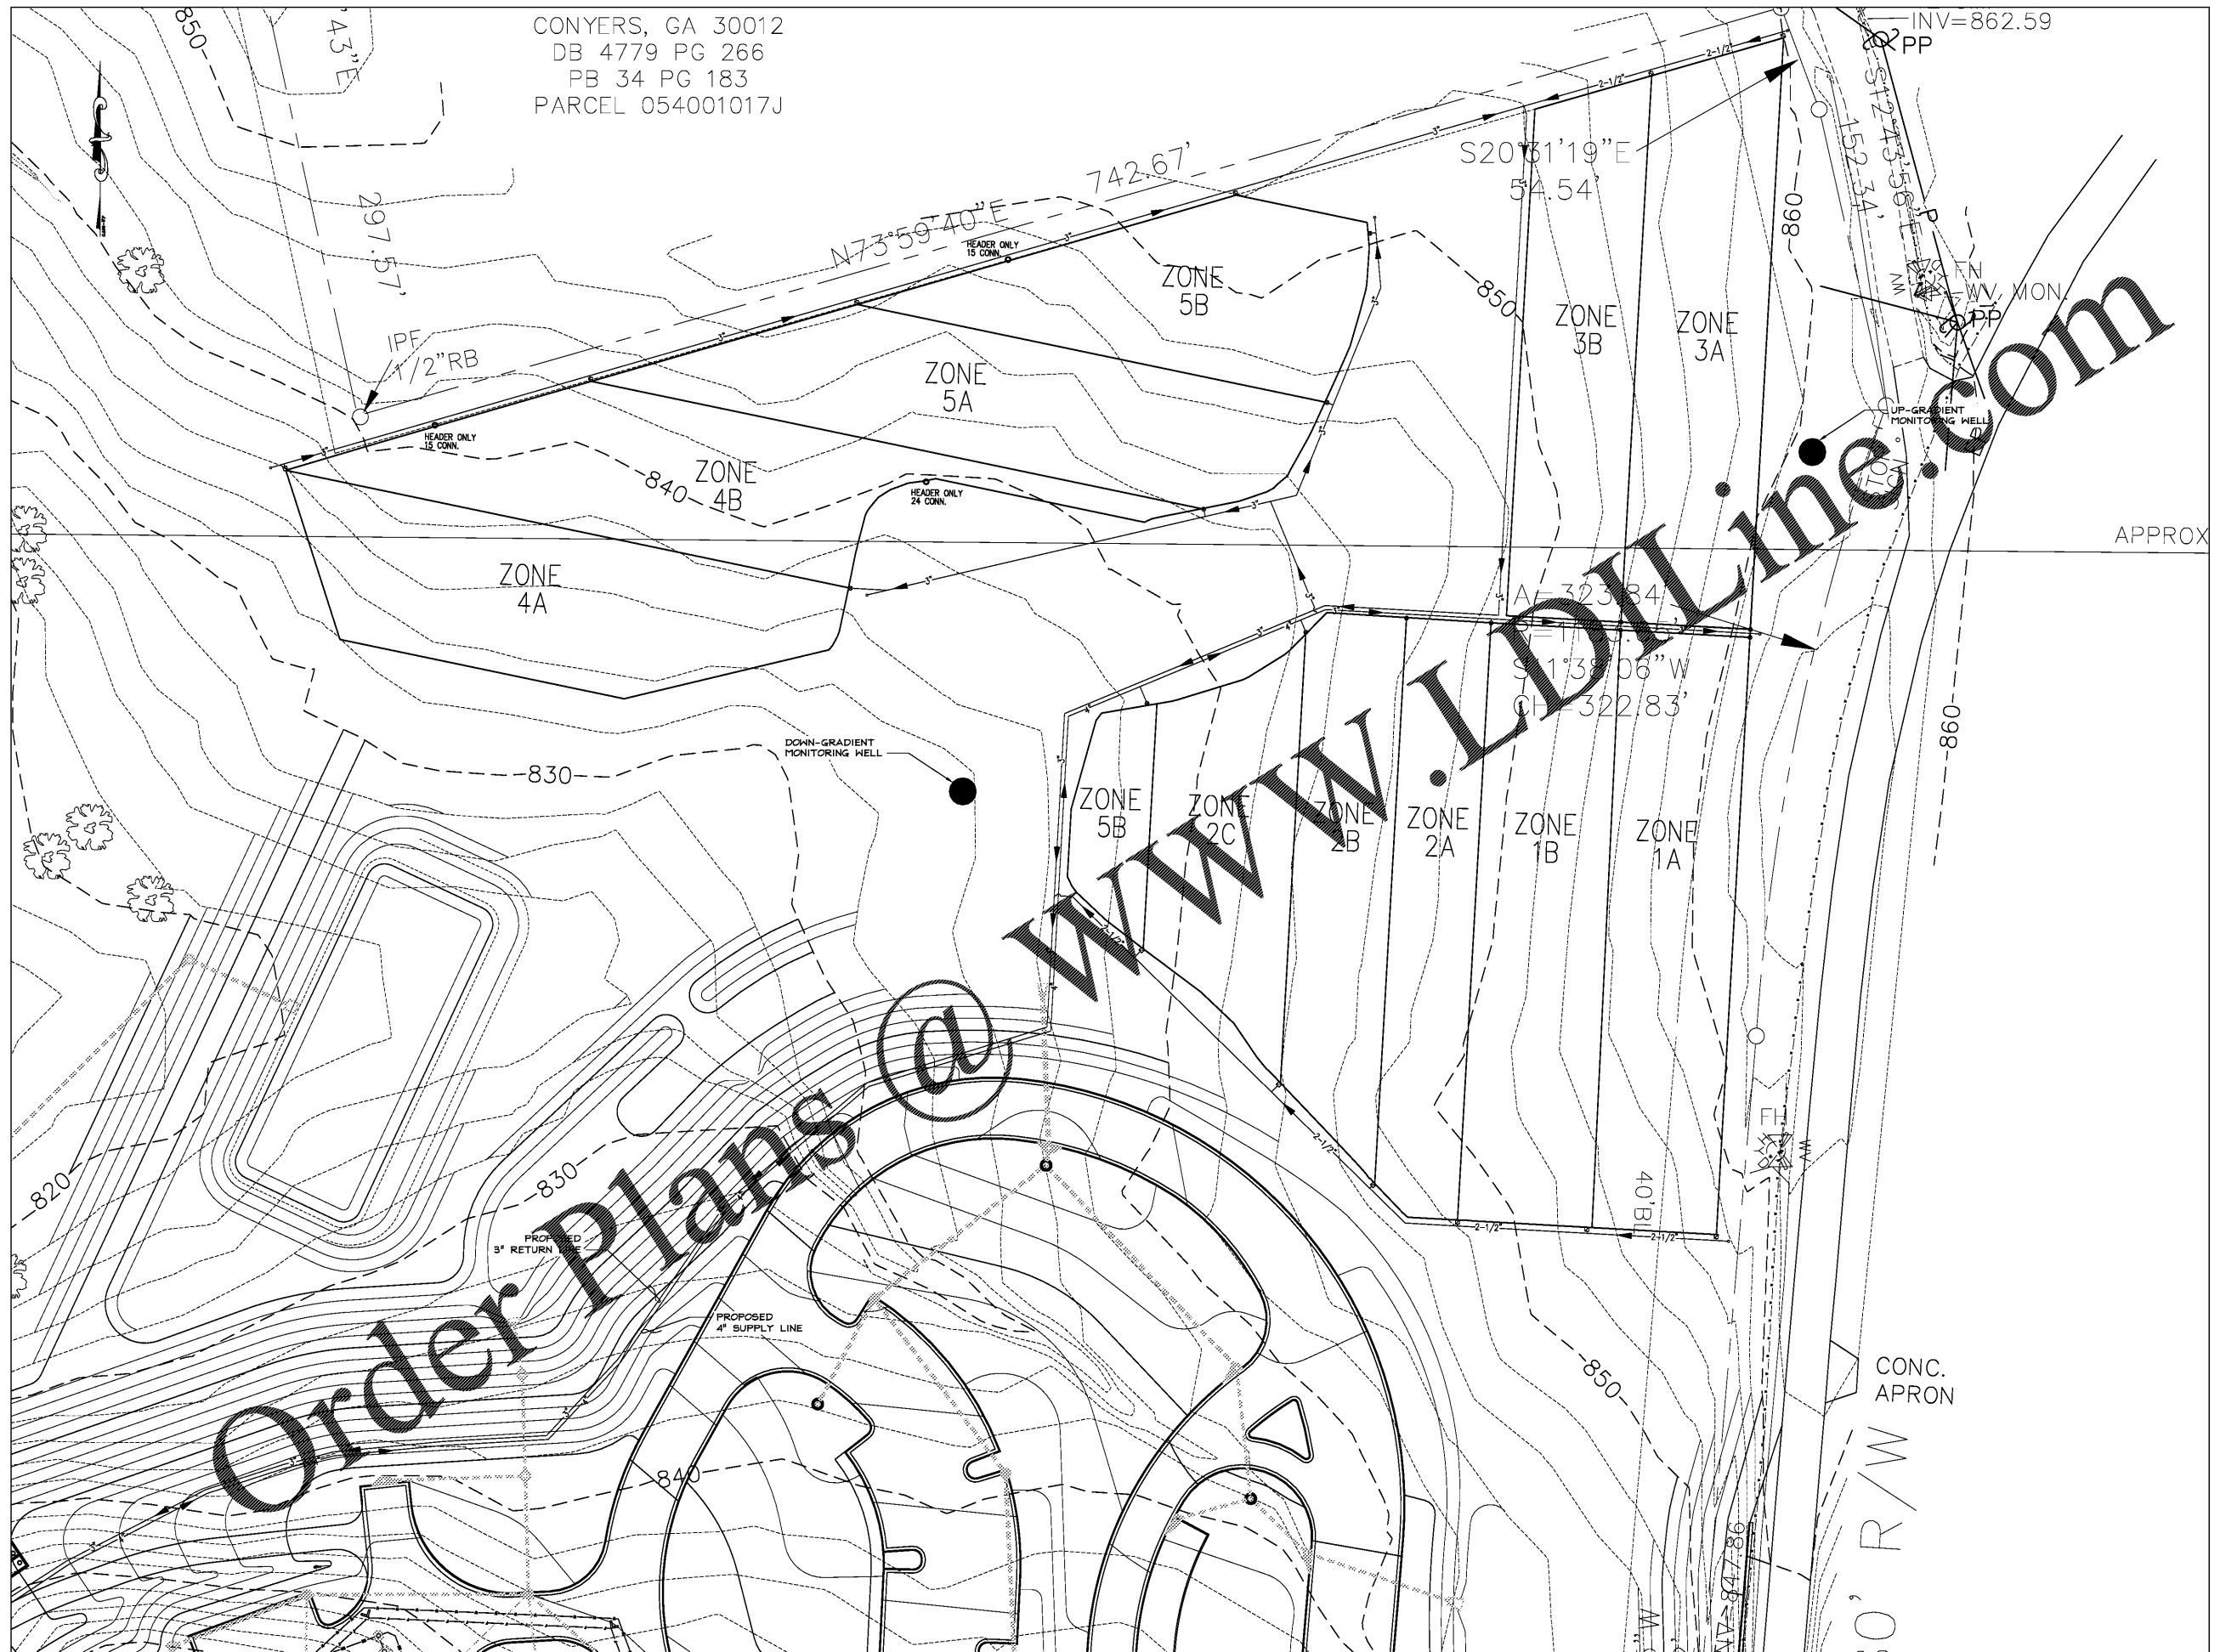

Order Plans @

WWW.LDLINE.COM



LAS LAYOUT

REVISIONS / PRINTED		
REV NO.	DATE	REMARKS
1	08/27/19	DDC PRELIMINARY
2	08/27/19	SITE PACKAGE
3	08/16/19	DDC CHECK SET

One Piedmont Center, Suite 303 3565 Piedmont Road Atlanta, Georgia 30305

Carter & Sloop
 CONSULTING ENGINEERS
 MACON ATHENS CANTON MOUNTAIN
 1031 STONERIDGE PARKWAY WATKINSVILLE, GA 30677 TEL: 706.767.4111 FAX: 706.767.4546
 CA COA LICENSE # PERO10904 EXPIRES 6/30/2020

GEORGIA
 REGISTERED PROFESSIONAL ENGINEER
 No. 28428
 MARTIN C. BOYLE
 08/05/16

© COPYRIGHT 2019
 SMALLWOOD, REYNOLDS, STEWART & ASSOCIATES, INC.
 ALL RIGHTS RESERVED. NO PART OF THIS DOCUMENT MAY BE REPRODUCED OR TRANSMITTED IN ANY FORM OR BY ANY MEANS WITHOUT THE WRITTEN PERMISSION OF SMALLWOOD, REYNOLDS, STEWART & ASSOCIATES, INC.

J.H. HOUSE ELEMENTARY SCHOOL
 2971 NE HIGHWAY 20, Conyers, GA 30012

DATE: _____
 JOB NO: 218036.00
 CAS PROJ. NO: S4800.002
 SHEET NO: _____

ISSUED FOR CONSTRUCTION **C3**

Smallwood, Reynolds, Stewart & Associates, Inc. Architects