


SITE LIGHTING PLAN GENERAL NOTES

1. PROVIDE AND INSTALL ALL CONDUIT, WIRE AND DEVICES REQUIRED FOR MONUMENT SIGN. VERIFY LOCATION AND REQUIREMENTS WITH SIGN MANUFACTURER PRIOR TO ROUGH-IN.
2. PROVIDE ALL GROUNDING FOR MONUMENT SIGN PER MANUFACTURER'S AND LOCAL CODE REQUIREMENTS.
3. REFERENCE CIVIL SITE LIGHTING SHEET FOR THE FOLLOWING INFORMATION:
 - 3.1. POLE SPECIFICATIONS
 - 3.2. LIGHTING FIXTURE MOUNTING HEIGHT
 - 3.3. LIGHTING FIXTURE SPECIFICATIONS
 - 3.4. LIGHTING FIXTURE DESIGNATIONS
4. REFER TO SHEET E1 FOR BUILDING MOUNTED LIGHT FIXTURE LOCATIONS AND DESIGNATIONS

SITE LIGHTING PLAN KEY NOTES

1. REFERENCE SHEET E5 FOR CONTACTOR DIAGRAM AND PANELBOARD SCHEDULES.

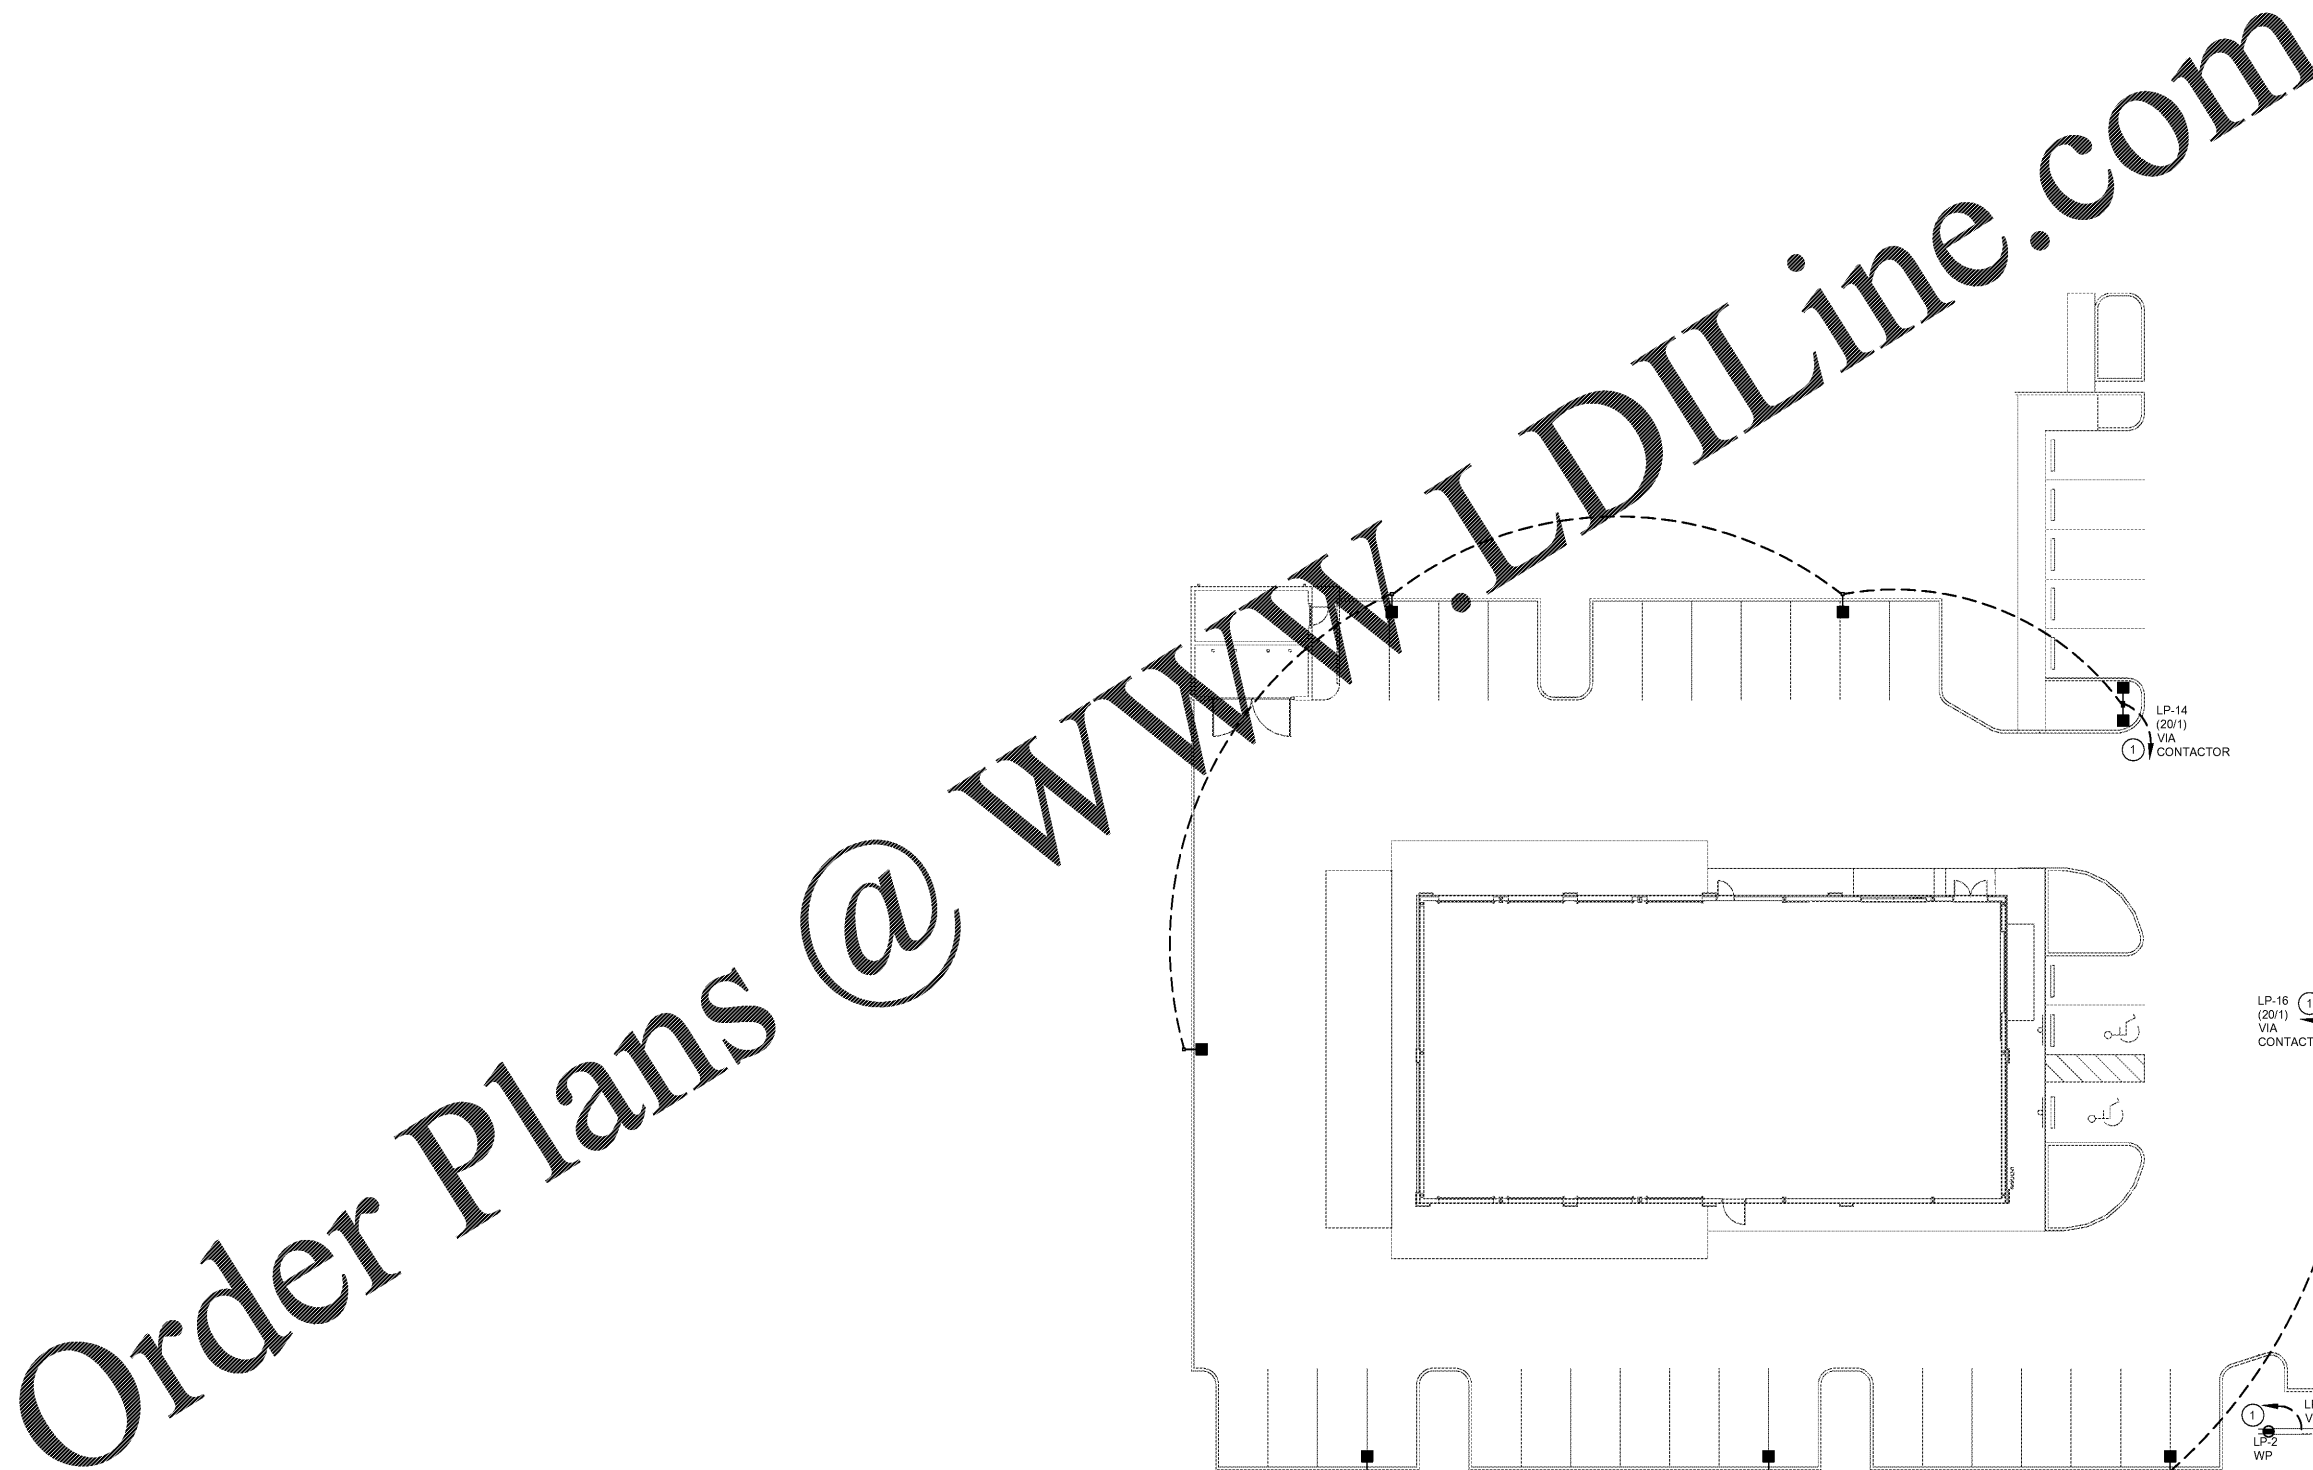


1 ELECTRICAL SITE PLAN
ESL1 SCALE: 1/16" = 1'-0"



THIS DRAWING IS THE PROPERTY OF BRIDGESTONE RETAIL OPERATIONS, LLC AND IS LOANED ON THE EXPRESS CONDITION THAT IT IS NOT TO BE USED IN ANY WAY DEPRECIATE TO THE INTERESTS OF BRIDGESTONE RETAIL OPERATIONS, LLC. IT IS TO BE RETURNED TO THE ENGINEER OF RECORD UPON COMPLETION OF THE PROJECT AND AS ADMISSION TO THE EXCLUSIVE OWNERSHIP (AND TO THE DRAWING BY BRIDGESTONE RETAIL OPERATIONS, LLC.

REPRODUCTION OF THIS DRAWING FOR ANY PURPOSES WITHOUT THE WRITTEN PERMISSION OF THE ENGINEER OF RECORD IS STRICTLY PROHIBITED. THIS DRAWING IS NOT TO BE USED FOR ANY OTHER PROJECT WITHOUT THE WRITTEN PERMISSION OF THE ENGINEER OF RECORD. ANY REUSE OF THIS DRAWING FOR ANY OTHER PROJECT WITHOUT THE WRITTEN PERMISSION OF THE ENGINEER OF RECORD IS STRICTLY PROHIBITED AND MAY BE CONSIDERED AS A VIOLATION OF THE LAW.

NEW FCAC STORE
2019 - JANUARY - SMALL I
233 S AIRLINE HWY
GONZALES, LA

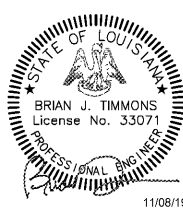

BID SET
11.18.19
TRCI

ISSUE BLOCK	
Δ	CB #1

PROPERTY NO.: 160013
6 DIGIT NO.: 902556
4 DIGIT NO.: 014W
AOR PROJECT NUMBER: 1955827
TO PERMIT: DATE: 7-30-2019
TO BID: DATE: ##-##-##

SHEET TITLE:
SITE LIGHTING PLAN

SHEET NUMBER:
ESL1