



ARCHITECTS
WM2A.COM
348 COTTON AVENUE
SUITE 500, PO BOX 890
MACON, GEORGIA 31201



CENTER PARK RESTROOMS
FACILITIES AND SHADE
PAVILION

REVISIONS		
#	DATE	DESCRIPTION

© 2019, WMA Architects/Planners, Inc.
All WMA Architects These drawings, as
instruments of service, remain the property
of the Architect. Unauthorized use or
reproduction is forbidden.

Date: 11/04/19

Drawn By: KMP/JWK

Checked By: KMP

Project Number: 2018-077

Drawing Name:
**RESTROOM FACILITY
& SHADE PAVILION
PLUMBING PLANS
- SEWER**

Drawing Number:


P1-1




169 New Street, Macon, GA 31201
(478) 741-4632 - T.E. project #19-055
www.totalengineers.com

Order Plans @ www.LDILine.com

4" WATER
REFER TO CIVIL FOR
CONTINUATION

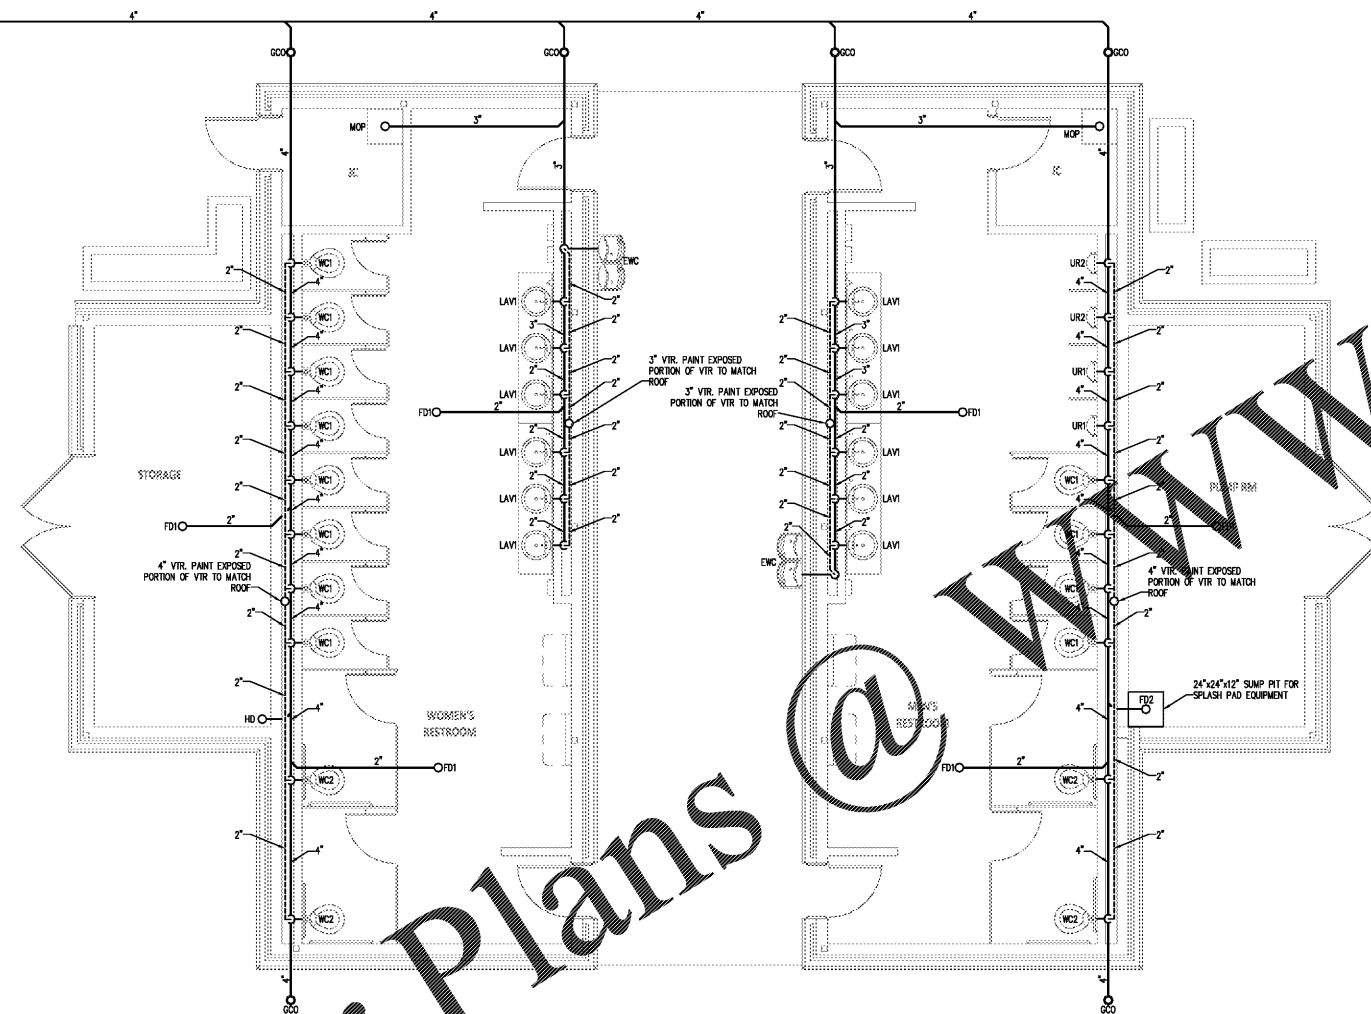

1 RESTROOM FACILITY PLUMBING PLAN - SEWER
SCALE: 1/4"=1'-0"

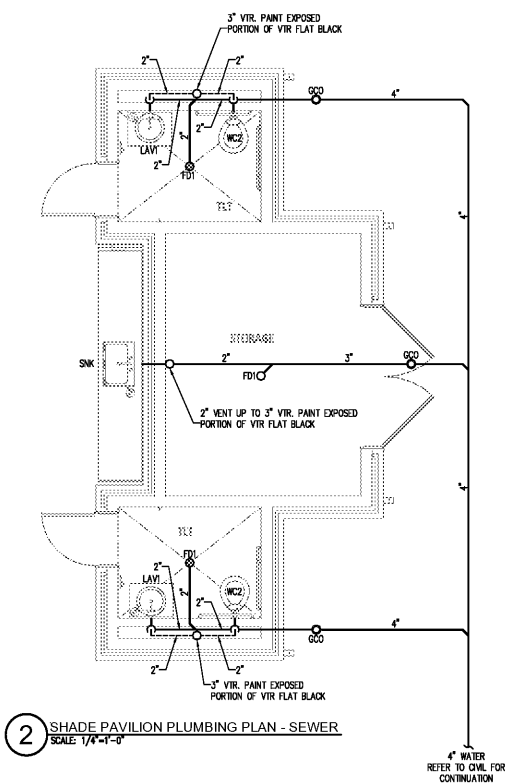

2 SHADE PAVILION PLUMBING PLAN - SEWER
SCALE: 1/4"=1'-0"

4" WATER
REFER TO CIVIL FOR
CONTINUATION