

EQUIP. LEGEND & AREA OF RESPONSIBILITY

ITEM	DESCRIPTION	MODEL	NSF	SUPPLIER	INSTALLATION	COORD./SUPERVISED	REMARKS
				OWNER CONT.	OWNER CONT.	BY CONTRACTOR	
01	GLASS DOOR MERCHANDISER	LV38-1-B	X	X	-	X	115 VOLTS, 9.2 AMPS / WITH CASTORS / NOTE 09
02	PASS-THRU COUNTER	CUSTOM	-	X	-	X	
03	SANDWICH/SALAD UNIT	SPE46-08	X	X	-	X	115 VOLTS, 8.6 AMPS / WITH INTEGRAL SHELVING #38 / NOTE 09
04	1-DR. REACH-IN REFRIGERATOR	HRI	X	X	-	X	115 VOLTS, 5.6 AMPS / WITH CASTORS / NOTE 09
05	48" WOODEN BENCH	CUSTOM	N/A	X	-	X	
06	HOOD FIRE ANSUL SUPPRESSION SYSTEM	CUSTOM	N/A	X	-	X	REF. TO HOOD DRAWINGS FIRE SUPPRESSION PERMITTED/ INSTALLED BY CAPTIVE AIRE WITH (2) 18" DRAIN BOARDS, (2) 8" SIDE SPLASHES.
07	S.S. 3-COMPARTMENT SINK 96"L	CUSTOM	X	X	-	X	VERIFY W/ LOCAL JURISDICTIONS FOR DRAIN BOARD & BOWL SIZE.
08	MOP SERVICE BASIN	MSB-2424	X	X	-	X	WITH BUILT-IN ANTI SIPHON DEVICE
09	S.S. WORK TABLE 30"D x 36"L	CUSTOM	X	X	-	X	WITH DRAWER / WITH INTEGRAL SHELVING #38 / WITH CASTORS
10	S.S. WORK TABLE 30"D x 96"L	CUSTOM	X	X	-	X	WITH UNDERSHELF / WITH INTEGRAL SHELVING #38
11	S.S. WORK TABLE 30"D x 18"L	CUSTOM	X	X	-	X	24" TALL
12	HAND SINK W/ SIDE SPLASH (R & L)	PBHS-W-KVMB-SSP-X	X	X	-	X	WITH (2) 8" HIGH SIDE SPLASHES
13	POTATO SLICER	300 SERIES	X	X	-	X	WITH SHOVEL LEVER
14	ICE MACH. W/ STORAGE BIN	KM-515MAH	X	X	-	X	110 VOLTS, 15 AMPS / S.B. MODEL, B-300 / WITH 6" HIGH LEGS
14A	ICE MACH. FILTER	CUSTOM	X	X	-	X	SUPPLIED BY EQUIPMENT VENDOR
15	TANKLESS WATER HEATER	1991-DV	X	X	-	X	REFER TO PLUMBING PLANS FOR SPECIFICATIONS
16	SWING GATE	CUSTOM	-	X	-	X	
17	NOT USED		-	-	-	-	
18	SOLSTICE SUPREME GAS FRYER	SSH75	X	X	-	X	105,000 BTU, 75 LBS (OIL CAPACITY) / WITH 6" CASTORS
19	NOT USED		-	-	-	-	
20	COOKING & HOLDING TIMER	U160DK7503	X	X	-	X	
21	SOLSTICE SUPREME FILTER	SF5H75	X	X	-	X	120 VOLTS, 6.2 AMPS / ITEM IS AN INTEGRAL PART OF THE FRYERS
22	STEAM TABLE PAN RACK & COVER	1509/PRC 12	X	X	-	X	QUANTITY: 02 / NOT INDICATED ON PLAN
23	NOT USED		-	-	-	-	
24	NOT USED		-	-	-	-	
25	24" x 30" TABLE & BASE	CUSTOM	N/A	X	-	X	
26A	30" x 42" TABLE & BASE	CUSTOM	N/A	X	-	X	
26B	ACCESSIBLE 30" x 42" TABLE & BASE	CUSTOM	N/A	X	-	X	
27	WOOD CHAIR	6305P	N/A	X	-	X	
28	TEA DISPENSER	BIB	X	X	-	X	120 VOLTS, 60HZ, 25-125 PSI
28A	NOT USED		-	-	-	-	
29	SLIM-JIM TRASH RECEPTACLE	8323G4	X	X	-	X	
30	SANITARY NAPKIN RECEPTACLE	1102	X	X	-	X	
31	TRASH RECEPTACLE	MODEL VARIES	X	X	-	X	
32	BEVERAGE / CONDIMENT'S COUNTER	CUSTOM	N/A	X	-	X	PROVIDED OWNER AND INSTALLED BY CONTRACTOR
33	SHORTENING SHUTTLE	SS-611-T	X	X	-	X	ITEM NUMBER NOT INDICATED ON EQUIPMENT PLAN
34	FREESTYLE DISPENSER	COCA COLA	X	X	-	X	115 VOLTS, 20 AMPS / GROUNDED DUPLEX OUTLET
34A	FREESTYLE DISPENSER FILTER	COCA COLA	X	X	-	X	PROVIDED BY COCA COLA
35	CARBONATOR	N/A	X	X	-	X	SUPPLIED BY COCA COLA PRODUCTS
36	BIB FLEX RACK SYSTEM	44239	X	X	-	X	WITH 6" HIGH LEGS
37	CO2 SYSTEM	CARBO-MIZER 450	N/A	X	-	X	
38	SOLID SHELVES	CUSTOM	X	X	-	X	2 ROWS INTEGRAL W/ #03 & 10. REFER TO EQ 2 FOR HEIGHT
39	DRY STORAGE SHELVING	EG01.00	X	X	-	X	REFER TO EQUIPMENT PLAN FOR SIZES AND NUMBER OF TIERS
40	DUNNAGE RACK (PRODUCE STAND)	DR362012	X	X	-	X	
41	SCULLERY SHELVING (2 ROWS)	EG01.00	X	X	-	X	2 ROWS OF 18" x 48" (TOP), 2 ROWS OF 18" x 36" (BOTTOM)
42	12" O.D. TYPE 1 EXHAUST HOOD	NO SERIES	X	X	-	X	NOTES 05, 06, 07 - VERIFY TYPE, SIZE & SERIES AGAINST HOOD DRAWINGS
43	S.S. WORK TABLE 48" (FRY TABLE)	CUSTOM	X	X	-	X	
44	BROOM & MOP RACK	40731	X	X	-	X	
45	FIRE EXTINGUISHER	REFER NOTE 03	N/A	-	-	X	CLASS: K (AT HOOD), CLASS: 2A10BC (STANDARD)
46	POINT-OF-SALE SYSTEM	RZ-X750	N/A	X	-	X	
47	SMARTRACK 9U WALL-MOUNT RACK	SRW9U	X	X	-	X	NOTE 11
48	POINT-OF-SALE EQUIPMENT	N/A	X	-	-	X	WALL MOUNTED MANAGER STATION
49	SAFE & STAND	P060413-03	N/A	X	-	X	MOUNTED ON BASE AS REQUIRED / COORDINATE TYPE WITH OWNER
50	STEREO (AMP.) RECEIVER	MODEL VARIES	N/A	X	-	X	PROVIDED AND INSTALLED BY OWNER
51	SATELLITE RECEIVER	MODEL VARIES	N/A	X	-	X	PROVIDED AND INSTALLED BY OWNER
52	LOW WALL CAP	CUSTOM	-	-	-	-	PROVIDED OWNER AND INSTALLED BY CONTRACTOR
53	1/2 PAN X 4	#5124	N/A	X	-	X	
54	POS COUNTER	CUSTOM	N/A	X	-	X	PROVIDED OWNER AND INSTALLED BY CONTRACTOR
55	POS SHROUD	CUSTOM	N/A	X	-	X	PROVIDED OWNER AND INSTALLED BY CONTRACTOR
56	STAINLESS STEEL FLEX HOSE	CUSTOM	X	X	-	X	
57	EXTERIOR BUILDING SIGNAGE WINGSTOP	CUSTOM	N/A	X	-	X	PROVIDED AND INSTALLED BY THE SIGN VENDOR
58	T.V. WALL BRACKET & STAND	MODEL VARIES	N/A	X	-	X	
59A	HAND SOAP DISPENSER	S4025	N/A	X	-	X	
59B	HAND SANITIZER DISPENSER	S4025	N/A	X	-	X	
60A	ELECTRIC HAND DRYER	M17ACS-LIL	N/A	X	-	X	
60B	PAPER TOWEL DISPENSER	T1290WS	N/A	X	-	X	
61	S.S. FRAMED MIRROR	B-165-2436	N/A	X	-	X	SIZE: 24" x 36", WITH S.S. CHANNEL FRAME
62	36" x 1 1/2" GRAB BAR	B-6106	N/A	X	-	X	
63	42" x 1 1/2" GRAB BAR	B-6106	N/A	X	-	X	
64	TOILET PAPER DISPENSER	B735020	N/A	X	-	X	
65	GREASE INTERCEPTOR	MODEL VARIES	N/A	X	-	X	REFER PLUMBING DRAWINGS FOR SPECIFICATIONS
66	NOT USED		-	-	-	-	
67	WALL MOUNTED MIXING FAUCET	CUSTOM	X	X	-	X	
68	60" x 18" WIRE WALL SHELVING	METRO	X	X	-	X	2 ROWS, REFER SHEET EQ 2 FOR HEIGHT
69	COOLER DUNNAGE RACK	DR362012	X	X	-	X	REFER TO EQUIPMENT PLAN FOR SIZES & MOUNTING HEIGHTS
70	COOLER SHELVING	EG01.00	X	X	-	X	9 TIERS HIGH, REFER TO EQUIPMENT PLAN FOR SIZES
71	WALK-IN COOLER	CUSTOM	X	X	-	X	NOTE 09 / WSPROTO-1 / WSPROTO-2 / WSPROTO-3
72	STOREFRONT VINYL GRAPHICS	CUSTOM	N/A	X	-	X	
73	KNIFE HOLDER	2918P	X	X	-	X	
74	TO-GO RACK	CUSTOM	X	X	-	X	18x36, 4 TIER WITH SOLID SHELVES AND 6" CASTERS
75	TICKET RAIL	X	X	-	-	X	
76	HIGH CHAIR	CHH-104	N/A	X	-	X	
77	S.S. 2-COMPARTMENT SINK 60"L	CUSTOM	X	X	-	X	WITH (1) 18" DRAIN BOARDS, (2) 8" SIDE SPLASHES WITH OPTIONAL LID COVERS.
78	DRY STORAGE WIRE SHELVING	EG01.00	X	X	-	X	VERIFY W/ LOCAL JURISDICTIONS FOR DRAIN BOARD & BOWL SIZE.
79	COMMERCIAL MOP BUCKET	7580-88	N/A	X	-	X	REFER TO EQUIPMENT PLAN FOR SIZE
80A	24" OFFICE BAR STOOL	4202P	N/A	X	-	X	ITEM NOT INDICATED ON EQUIPMENT PLAN
80B	NOT USED		-	-	-	-	
81	CONDIMENT DISPENSER	CUSTOM	X	X	-	X	
82	PAPER TOWEL HOLDER	CUSTOM	X	X	-	X	1/2" DIA X 1/2" LONG PER THE DESIGNED 1/2" METAL PIPE, W/ 1" CAP AND 1" FLANGE
83	NOT USED		-	-	-	-	
84	REACH-IN FREEZER	HFI	X	X	-	X	
85	S.S. WORK TABLE 30"W x 26"D X 30" H	CUSTOM	X	X	-	X	WITH UNDERSHELF
86	S.S. STAND	SK2731U	X	X	-	X	W/ 4 WHEELS
87	CONVECTION OVEN	E31D4	X	X	-	X	208V, 14 AMPS, NEMA 6-15P CORDSET FITTED / NOTE 10
88	NOT USED		-	-	-	-	
89	NOT USED		-	-	-	-	
90	NOT USED		-	-	-	-	
91	VERTICAL GRAB BAR	B-6106	N/A	X	-	X	
92	MANAGER'S DESK	CUSTOM	X	X	-	X	COORDINATE WITH EQUIPMENT MANUFACTURER
93	NOT USED		-	-	-	-	
94	NOT USED		-	-	-	-	
95	NOT USED		-	-	-	-	
96	NOT USED	DD50	X	X	-	X	115 VOLTS, 4 AMPS / 1 1/2" DRAIN LINE / WITH 6" CASTORS
97	NACHO CHEESE DISPENSER	GEHLS	N/A	X	-	X	PROVIDED BY CHEESE DISPENSER COMPANY
98	STAINLESS STEEL CORNER GUARD	N/A	X	X	-	X	
99	STAINLESS STEEL END CAP	N/A	X	X	-	X	
100	FREEZER SHELVING	EG01.00	X	X	-	X	FF1836G 4 TIERS HIGH, FG063G POSTS

- EQUIPMENT LEGEND NOTES:
- FLAT PANEL TV DISPLAY WALL MOUNTING BRACKET & MONITOR CABLE CONNECTION TO BE DETERMINED BY OWNER, CONTRACTOR TO COORDINATE ITEM WITH OWNER FOR INSTALLATION.
 - THE OWNER SHALL PROVIDE WALL MOUNTED DISPLAY ITEMS. THESE ITEMS ARE TO BE INSTALLED BY THE CONTRACTOR. THE CONTRACTOR SHALL COORDINATE AND SCHEDULE THE DELIVERY AND INSTALLATION OF ALL DECOR ITEMS WITH THE OWNER. REFER TO A3.1
 - THE CONTRACTOR SHALL VERIFY WITH ALL LOCAL AGENCIES QUANTITY AND LOCATION OF ALL FIRE EXTINGUISHERS.
 - ALL KITCHEN EQUIPMENT SHALL MEET THE REQUIREMENTS OF THE NATIONAL SANITATION FOUNDATION (NSF).
 - THE EXHAUST HOOD, EXHAUST FAN, EXHAUST DUCT, EXHAUST DUCT FIRE WRAP AND MAKE-UP AIR FAN SHALL BE SUPPLIED BY THE OWNER AND INSTALLED BY THE CONTRACTOR. THE MAKE-UP AIR DUCT SHALL BE SUPPLIED AND INSTALLED BY THE CONTRACTOR.
 - THE EXHAUST HOOD FIRE SUPPRESSION SYSTEM SHALL BE SUPPLIED AND INSTALLED BY THE OWNER. THE CONTRACTOR SHALL SUPPLY AND INSTALL THE EMERGENCY GAS SHUT-OFF VALVE FOR THE EXHAUST HOOD FIRE SUPPRESSION SYSTEM.
 - THE CONTRACTOR SHALL COORDINATE AND SCHEDULE THE DELIVERY OF ALL KITCHEN EQUIPMENT WITH THE EQUIPMENT VENDOR.
 - THE CONTRACTOR SHALL MAKE ALL FINAL ELECTRICAL CONNECTIONS REQUIRED FOR THE OWNER PROVIDED SIGNAGE.
 - ALL SPECIFIED REFRIGERATION UNITS SHALL BE SELF-CONTAINED AND SELF-EVAPORATING.
 - NO GREASE LADEN FOODS SHALL BE PREPARED IN THE CONVECTION OVEN (ITEM #87), IT IS USED FOR BAKING ROLLS ONLY.
 - CONTACT SMARTRACK 9U WALL-MOUNT RACK SUPPLIER FOR ADDITIONAL INFORMATION: CHRIS IANNUZZI OF IT SAVVY (630) 396-6315

EQUIP. PLAN NOTES

- ALL SWITCHES, COVER PLATES, AND PLUGS SHALL BE 'WHITE'
 - TELEPHONE SERVICE SHALL BE (3) THREE LINES OF SERVICE AS FOLLOWS:
 - LINE 1 SHALL BE PRIMARY TELEPHONE LINE
 - LINE 2 SHALL BE FOR ROLL-OVER TELEPHONE LINE AND FAX LINE.
 - LINE 3 SHALL BE FAX AND DATA LINE.
 - THE GENERAL CONTRACTOR SHALL PROVIDE THE MOUNTING OF TRANSFORMERS AND FINAL ELECTRICAL CONNECTION OF THE OWNER PROVIDED AND INSTALLED INTERIOR AND EXTERIOR BUILDING SIGNAGE. ALL SIGNS SHALL BE ON INDIVIDUAL CIRCUITS WITH DEDICATED GROUNDS.
 - THE FLOOR SINK UNDER THE 3-COMPARTMENT SINK IS USED FOR THE PLUMBING HOSE BIB.
 - COOKING AREA PROTECTION SYSTEM SHALL BE SUBMITTED FOR PLAN REVIEW UNDER A SEPARATE PLAN CHECK AND PERMIT
- NOTE: EXTERIOR SIGNAGE SHALL BE SUBMITTED UNDER A SEPARATE PLAN CHECK REVIEW AND PERMIT PROCESS.


EQUIP. PLAN LEGEND

- ◇ PROVIDE DEDICATED CIRCUIT AND GROUND 12'-0" A.F.F. ABOVE SOFFIT FOR LED SIGNS - TYPICAL - REFER TO ELECTRICAL DRAWINGS FOR ADDITIONAL INFORMATION
- ◇ PROVIDE DEDICATED CIRCUIT AND GROUND WITH CIRCUIT TIMER FOR EXTERIOR BUILDING SIGN - TYPICAL - VERIFY LOCATION WITH SIGN VENDOR - REFER TO ELECTRICAL DRAWINGS FOR ADDITIONAL INFORMATION
- ◇ REMOTE ANSUL PULL STATION - VERIFY LOCATION WITH LOCAL FIRE MARSHAL
- ◇ GAS SERVICE CONNECTION - REFER TO MECHANICAL DRAWINGS FOR ADDITIONAL INFORMATION
- ◇ 6" P.V.C. BEVERAGE CONDUIT RUN IN CEILING WITH 6" 90's AND 6" P.V.C. IN PARTITIONS - REFER TO DETAIL 7/EQ2 FOR ADD. INFO
- ◇ SOLID SURFACE WALL CAP BY MILLWORK VENDOR, REFER TO 2/A5.0

WALK-IN COOLER/FREEZER SPECIFICATIONS

COMPONENT	DESCRIPTION
INSULATION:	FOAMED IN PLACE POLYURETHANE INSULATION WITH 1 URETHANE FOAM INSULATION WITH 25% FLAME SPREAD RATING OF LESS THAN 25% AND SMOKE DENSITY OF LESS THAN 10% (WGBE) TESTED IN ACCORDANCE TO A.S.T.M. (U.L. 723)
FLOOR:	FLOOR AND CEILING PANELS: 4" THICK HIGH DENSITY POLYURETHANE PRE-FABRICATED FRAME - N.S.F. FLOOR FINISH: #10 SMOOTH ALUMINUM
DOORS:	(1) 34" x 78" FLUSH-IN FITTING COOLER DOOR (1) 30" x 72" FLUSH-IN FITTING FREEZER DOOR

- INSTALLATION INSTRUCTIONS FOR THE WALK-IN COOLER/FREEZER SHALL BE ON THE JOBSITE FOR THE LOCAL BUILDING OFFICIAL.
- PROVIDE CP 25WB+ FIRE BARRIER SEALANT CAULK OR FB-3000 W/T FIRE BARRIER SEALANT FOR ANY PENETRATIONS INTO THE INSULATED PANELS

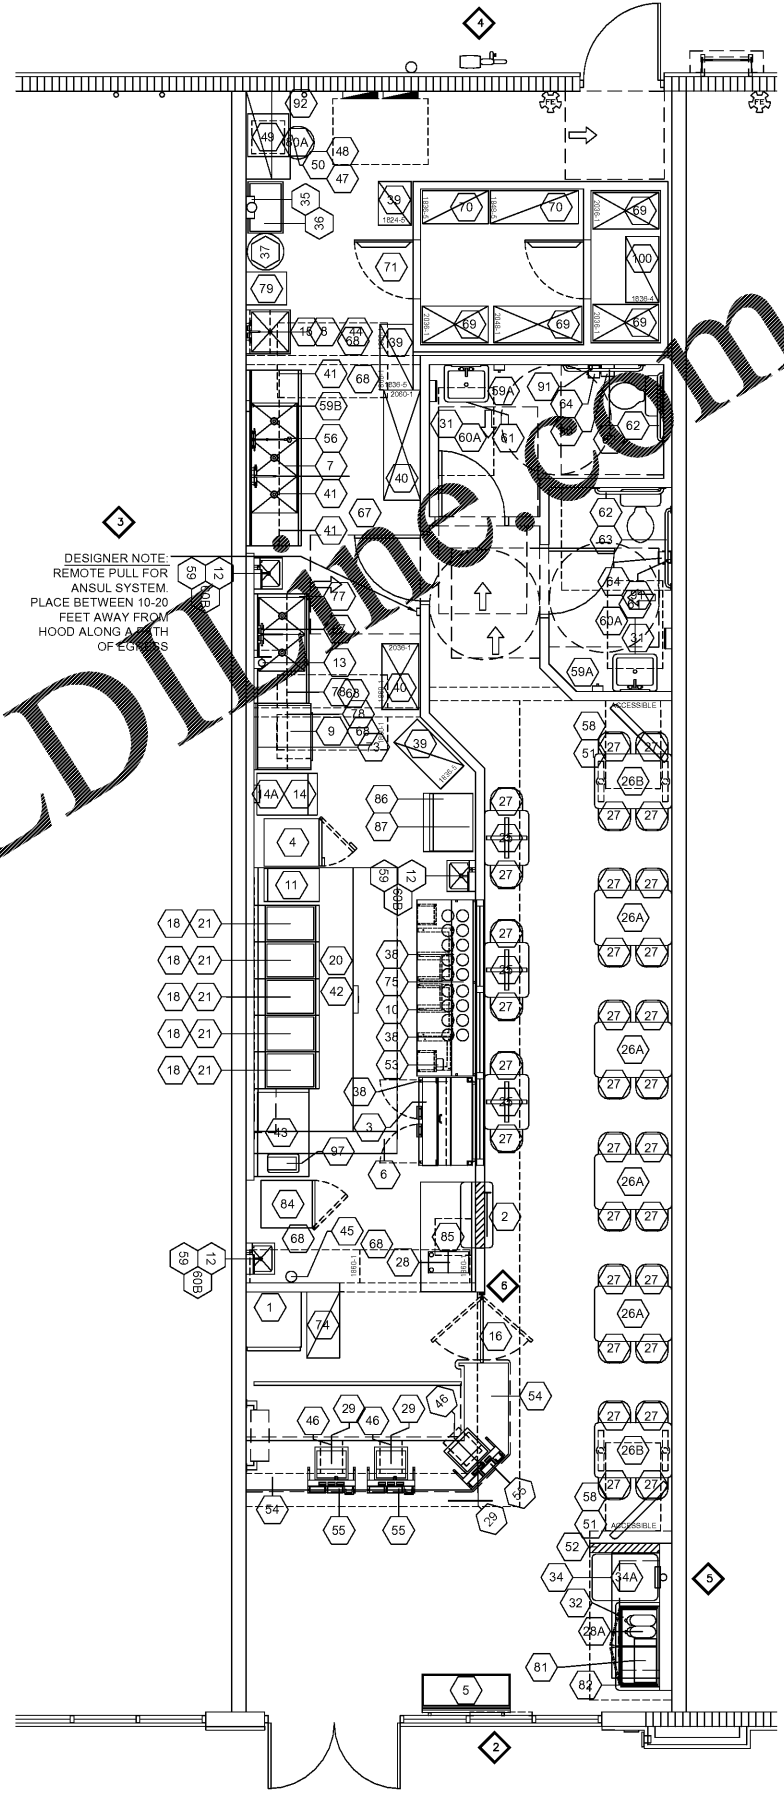

1 EQUIPMENT PLAN
EQ1 SCALE: 1/4" = 1'-0"

ALL DOCUMENTS ARE TO BE BUILT AND BID BASED ON THE MOST STRINGENT CODES. G.C. TO VERIFY THAT ALL CONSTRUCTION IS BUILT TO CODE AND THAT BIDS PROVIDED INCLUDE THE MOST RECENT CODE PER THE MUNICIPALITY. FAILURE TO DO SO WILL RESULT IN THE RELIEF OF LIABILITY OF THE OWNER, ARCHITECT, ENGINEER, AND DESIGNER. DRAWINGS ARE PROVIDED AS REFERENCE AND NOT ALL CONDITIONS ARE DETAILED. IF THERE ARE ANY DISCREPANCIES IN THE PLANS AND THE FIELD CONDITIONS THE CONTRACTOR MUST NOTIFY THE ARCHITECT OR ENGINEER OF RECORD. FAILURE TO DO SO WILL RESULT IN A DENIAL OF CHANGE ORDER REQUEST.



WARNER ARCHITECTURAL ASSOCIATES
 109 ANDERSON STREET SE, SUITE 105
 MARIETTA, GA 30060
 PH: 678.290.9200
 EMAIL: INFO@WARNERARCHASSOC.COM

WING-STOP
 10125 ULMERTON RD.
 LARGO, FL 33771
 STORE # V050

DRAWN BY: RDL
 CHECKED BY: WLW
 DATE:
 PROJECT: WS1813
 REVISION:
 REVISION:

EQUIPMENT PLAN
 DRAWING NUMBER
EQ1