

ROCKLEDGE FLATS

OHM ADVISORS



Consultants
OHM ADVISORS
DESIGN ARCHITECT
209 10TH AVENUE SOUTH, SUITE 116
NASHVILLE, TN 37203

CUHACI & PETERSON
ARCHITECT IN RECORD
1925 PROSPECT AVENUE
ORLANDO, FL 32814

BRAND INTERIOR DESIGN
INTERIOR DESIGNER
NASHVILLE, TN 34747

BERRY ENGINEERS LLC
CIVIL ENGINEER
3555 KEITH STREET NW, SUITE 109
CLEVELAND, TN 37312

EMC STRUCTURAL ENGINEERS
STRUCTURAL ENGINEER
4525 TROUSDALE DRIVE
NASHVILLE, TN 37204-4513


QDG ENGINEERING
MEP AND FIRE PROTECTION
6901 LENOX VILLAGE DRIVE, SUITE 108
NASHVILLE, TN 37211

PREVOST STAMPER IRRIGATION
IRRIGATION CONSULTANT
414 ARBOR CIRCLE
CELEBRATION, FL 34747


Rev	Date	Issued for

Date	NOVEMBER 15, 2019
Designed By	JYP
Drawn By	JYP
Approved / Checked By	EML
Project Number	219086


Sheet	
Project Phase	GMP PRICING SET
Sheet Title	HARDSCAPE DETAILS
Sheet Number	L3-3-03

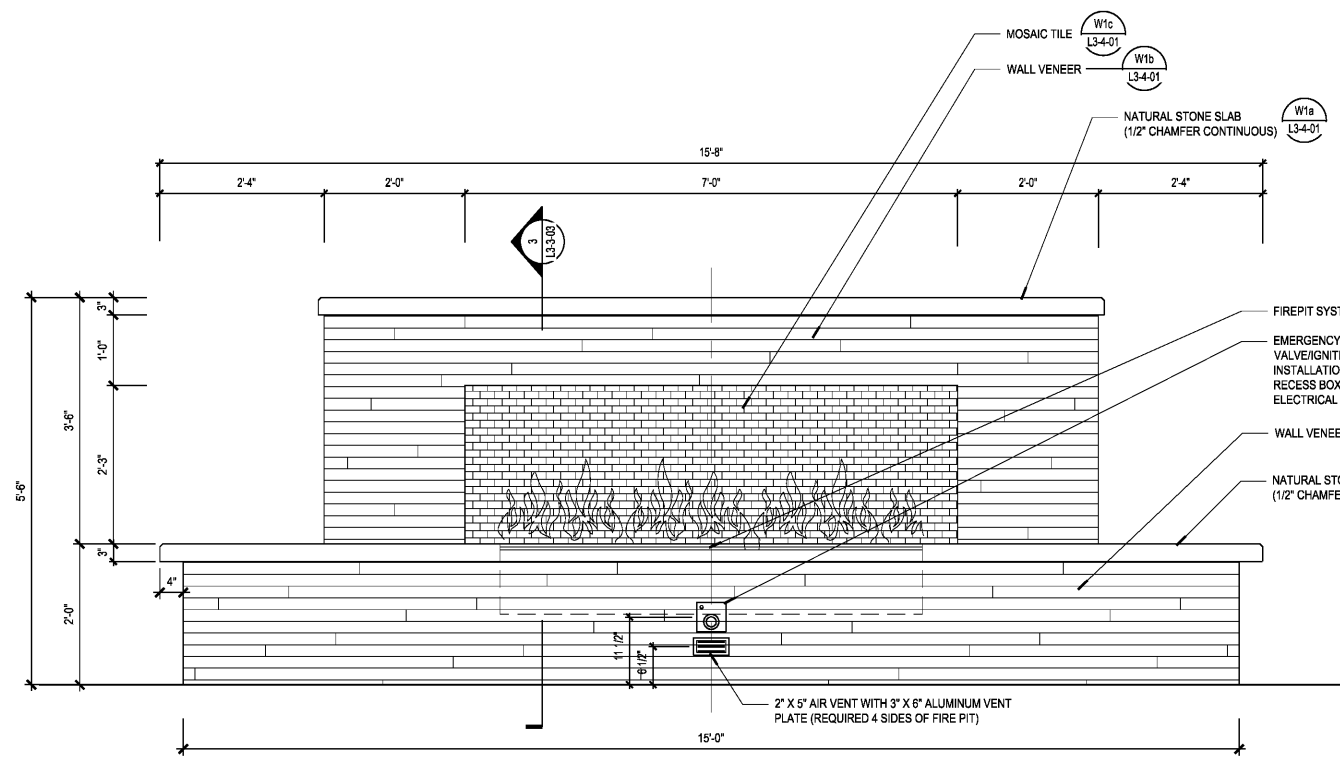


1 FIREPLACE FRONT ELEVATION SCALE: 1" = 1'-0"

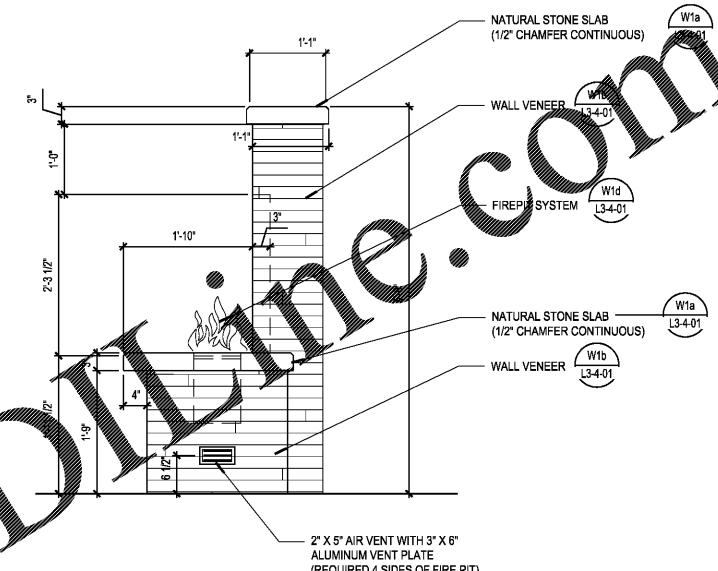


2 FIREPLACE SIDE ELEVATION SCALE: 1" = 1'-0"

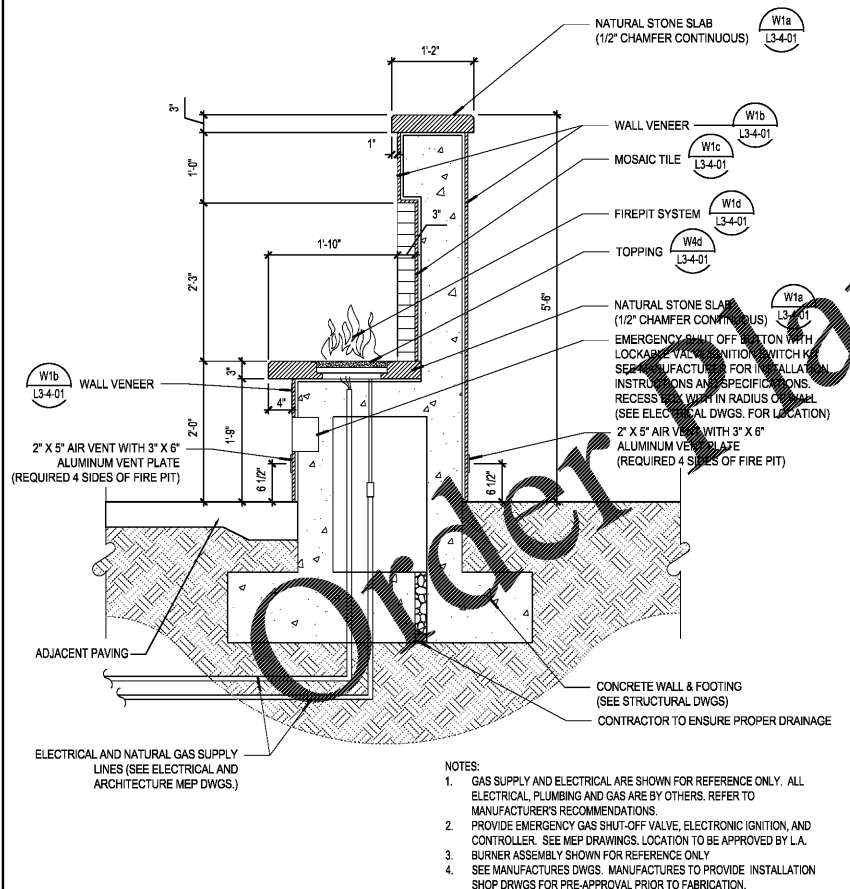

3 FIREPLACE SECTION SCALE: 1" = 1'-0"

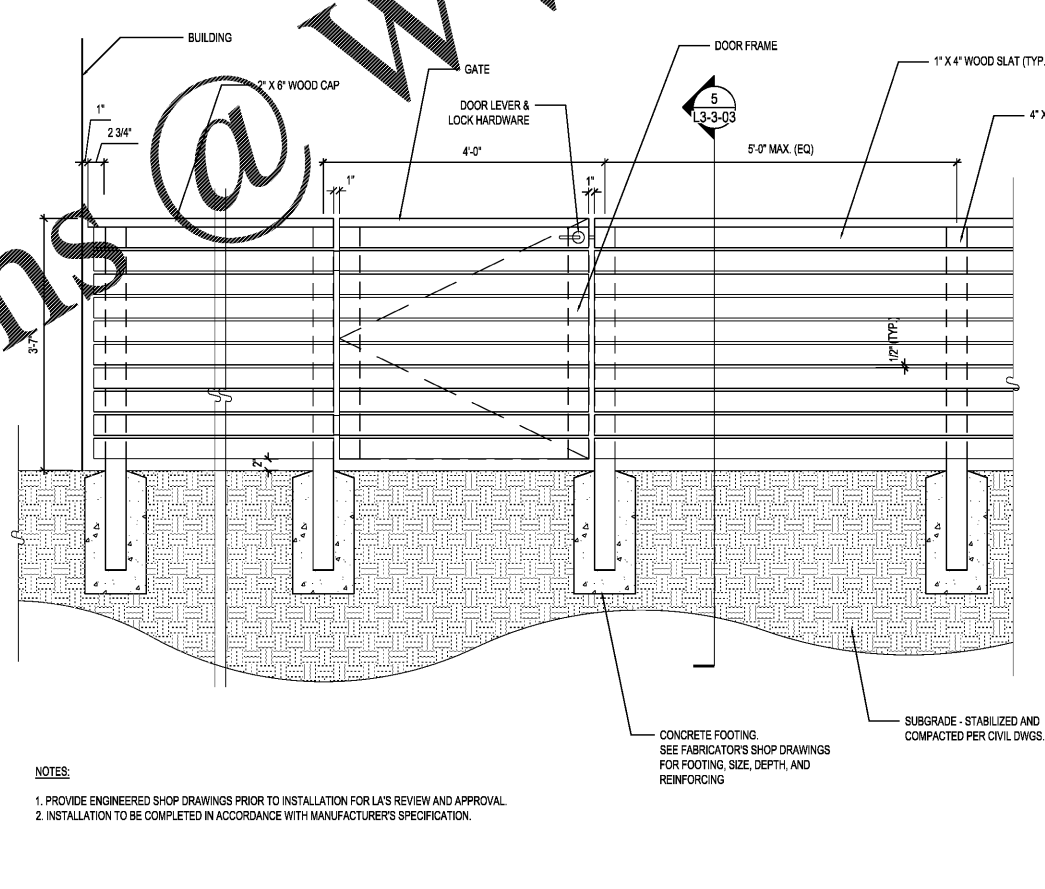

4 F2 - WOOD FENCE & GATE ELEVATION SCALE: 1" = 1'-0"

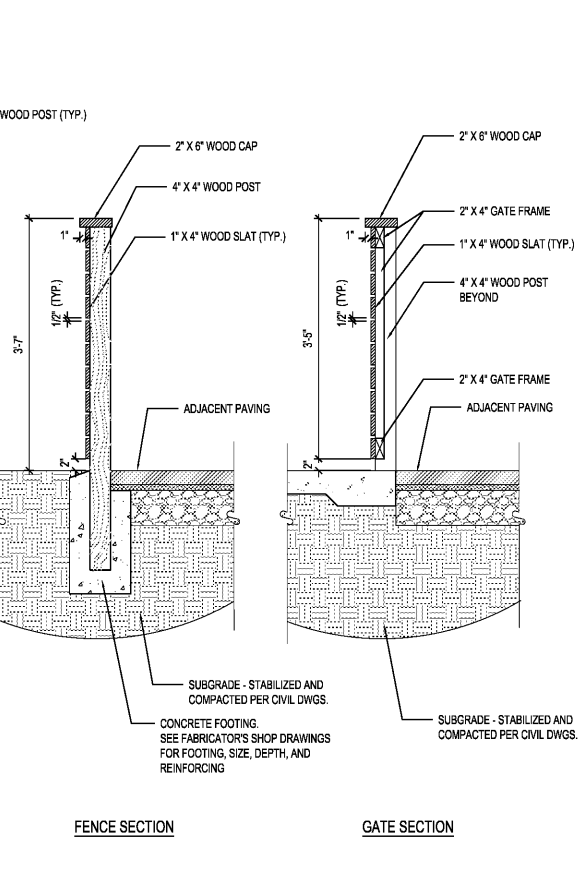

5 F2 - WOOD FENCE & GATE SECTION SCALE: 1" = 1'-0"

- NOTES:
- GAS SUPPLY AND ELECTRICAL ARE SHOWN FOR REFERENCE ONLY. ALL ELECTRICAL, PLUMBING AND GAS ARE BY OTHERS. REFER TO MANUFACTURER'S RECOMMENDATIONS.
 - PROVIDE EMERGENCY GAS SHUT-OFF VALVE, ELECTRONIC IGNITION, AND CONTROLLER. SEE MEP DRAWINGS. LOCATION TO BE APPROVED BY L.A. BURNER ASSEMBLY SHOWN FOR REFERENCE ONLY.
 - SEE MANUFACTURER'S DWGS. MANUFACTURER TO PROVIDE INSTALLATION SHOP DRWGS FOR PRE-APPROVAL PRIOR TO FABRICATION.

- NOTES:
- PROVIDE ENGINEERED SHOP DRAWINGS PRIOR TO INSTALLATION FOR LA'S REVIEW AND APPROVAL.
 - INSTALLATION TO BE COMPLETED IN ACCORDANCE WITH MANUFACTURER'S SPECIFICATION.

Drawing name: G:\Projects\ELU219086\Rockledge\Flats\EDSA\Acc005-CADD\L3-3-03 Nov 15, 2019 3:07pm by: jank

WWW.LDLINE.COM

Order Plans