


Order Plans @

www.LDILine.com

1 MECHANICAL ROOF PLAN
3/32" = 1'-0"

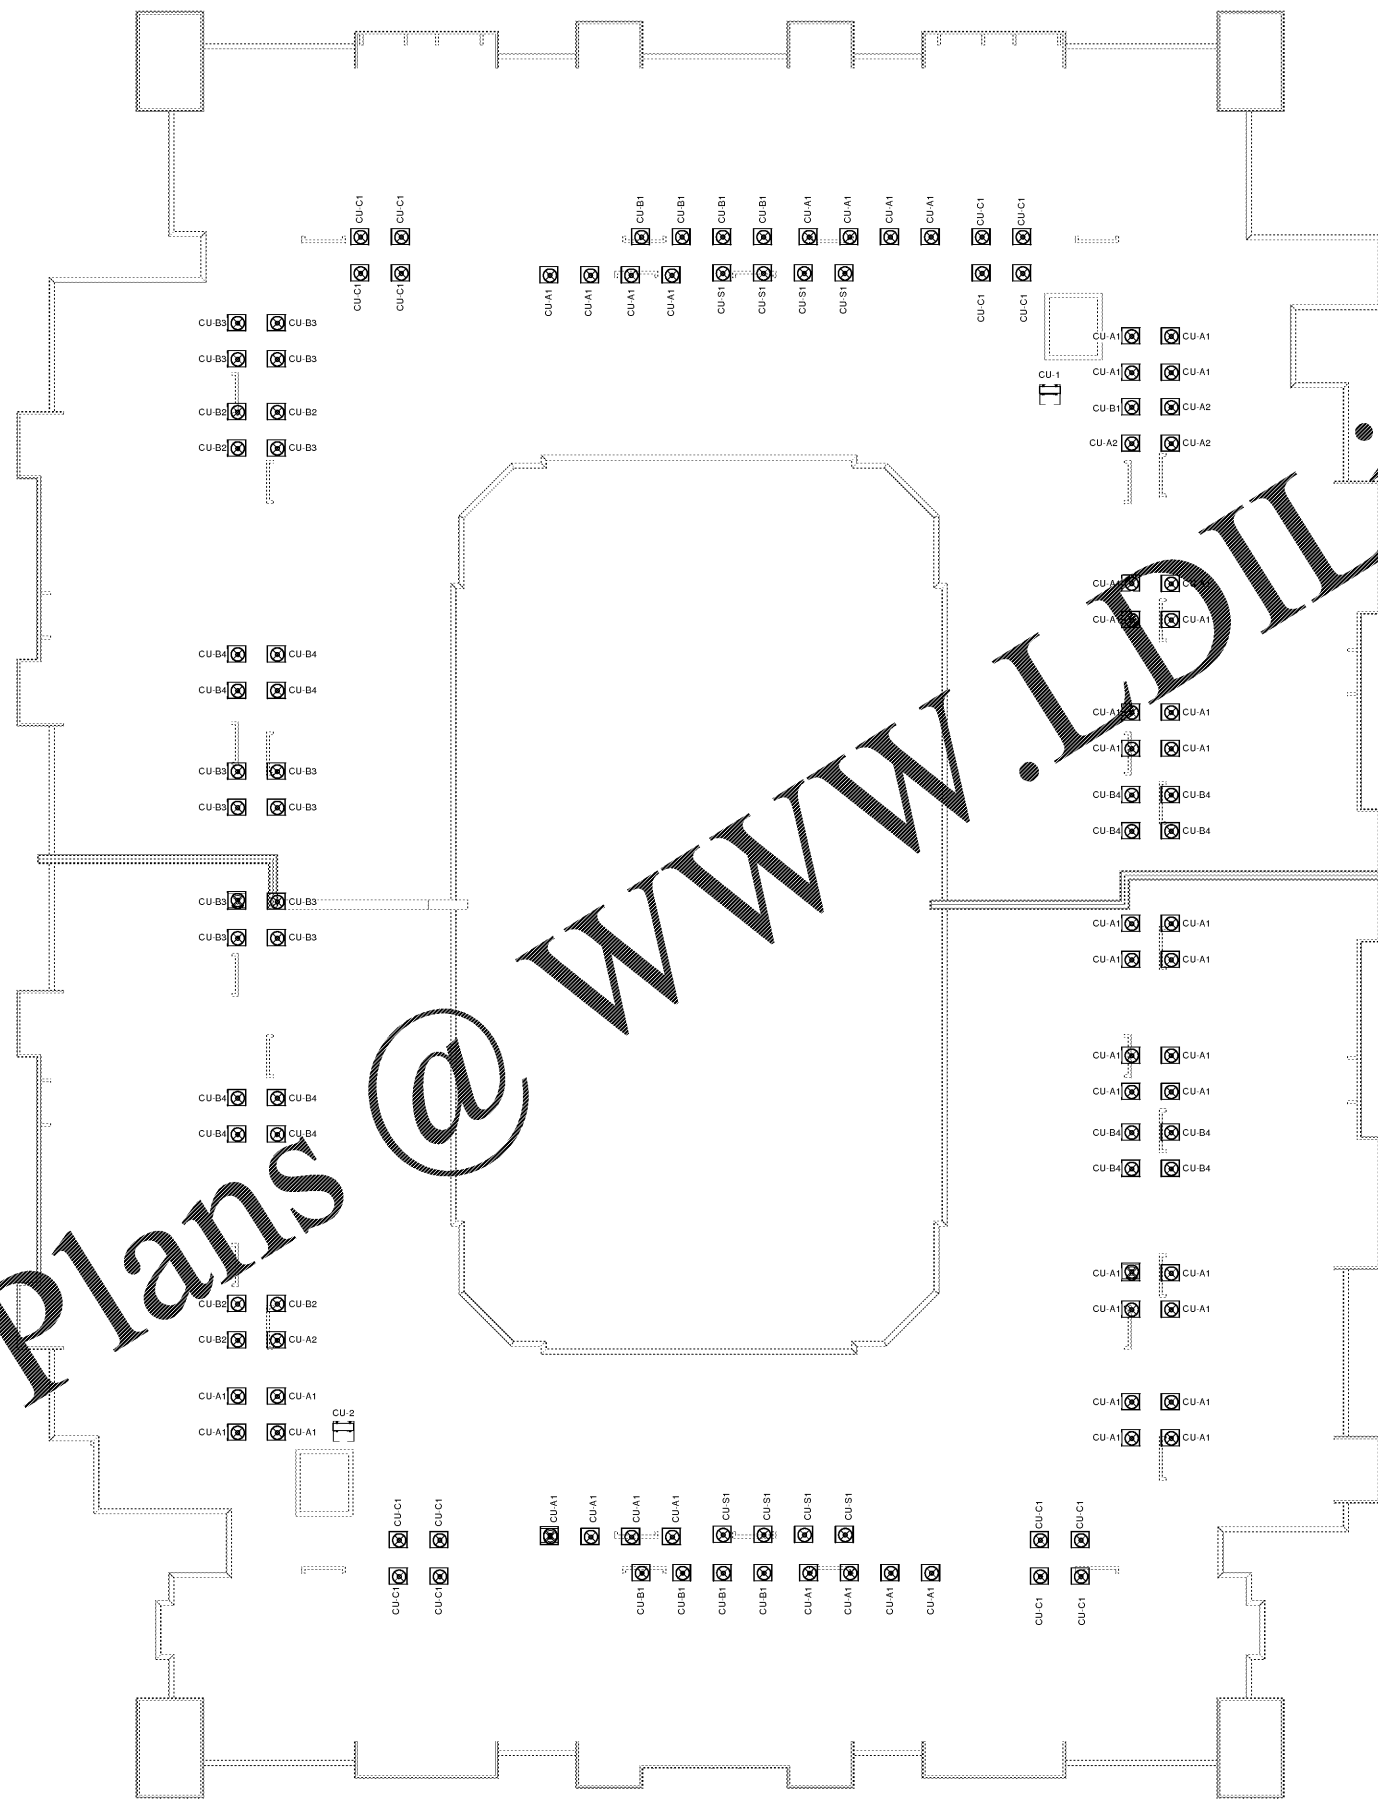

Revision Schedule	
No.	Date

PROJECT NO.
054-15010

DATE
20/01/16

DESIGNER
[Signature]

CHECKED
[Signature]


PROJECT NAME
ROCKLEDGE MULTI-FAMILY

CLIENT NAME
[Blank]

PROJECT ADDRESS
220 Baron Boulevard
Rockledge, FL 32955

SHEET TITLE
MECHANICAL ROOF PLAN

NOV 03, 2015

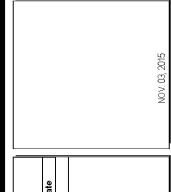

1925 Prospect Ave.
Orlando, FL 32814
P (407) 661-9100
F (407) 661-9101
www.r.p.e.com

Rockledge Multi-Family
220 Baron Boulevard
Rockledge, FL 32955
MECHANICAL ROOF PLAN

M105

GMP PRICING SET