



Order Plans @ [www.LDILine.com](http://www.LDILine.com)

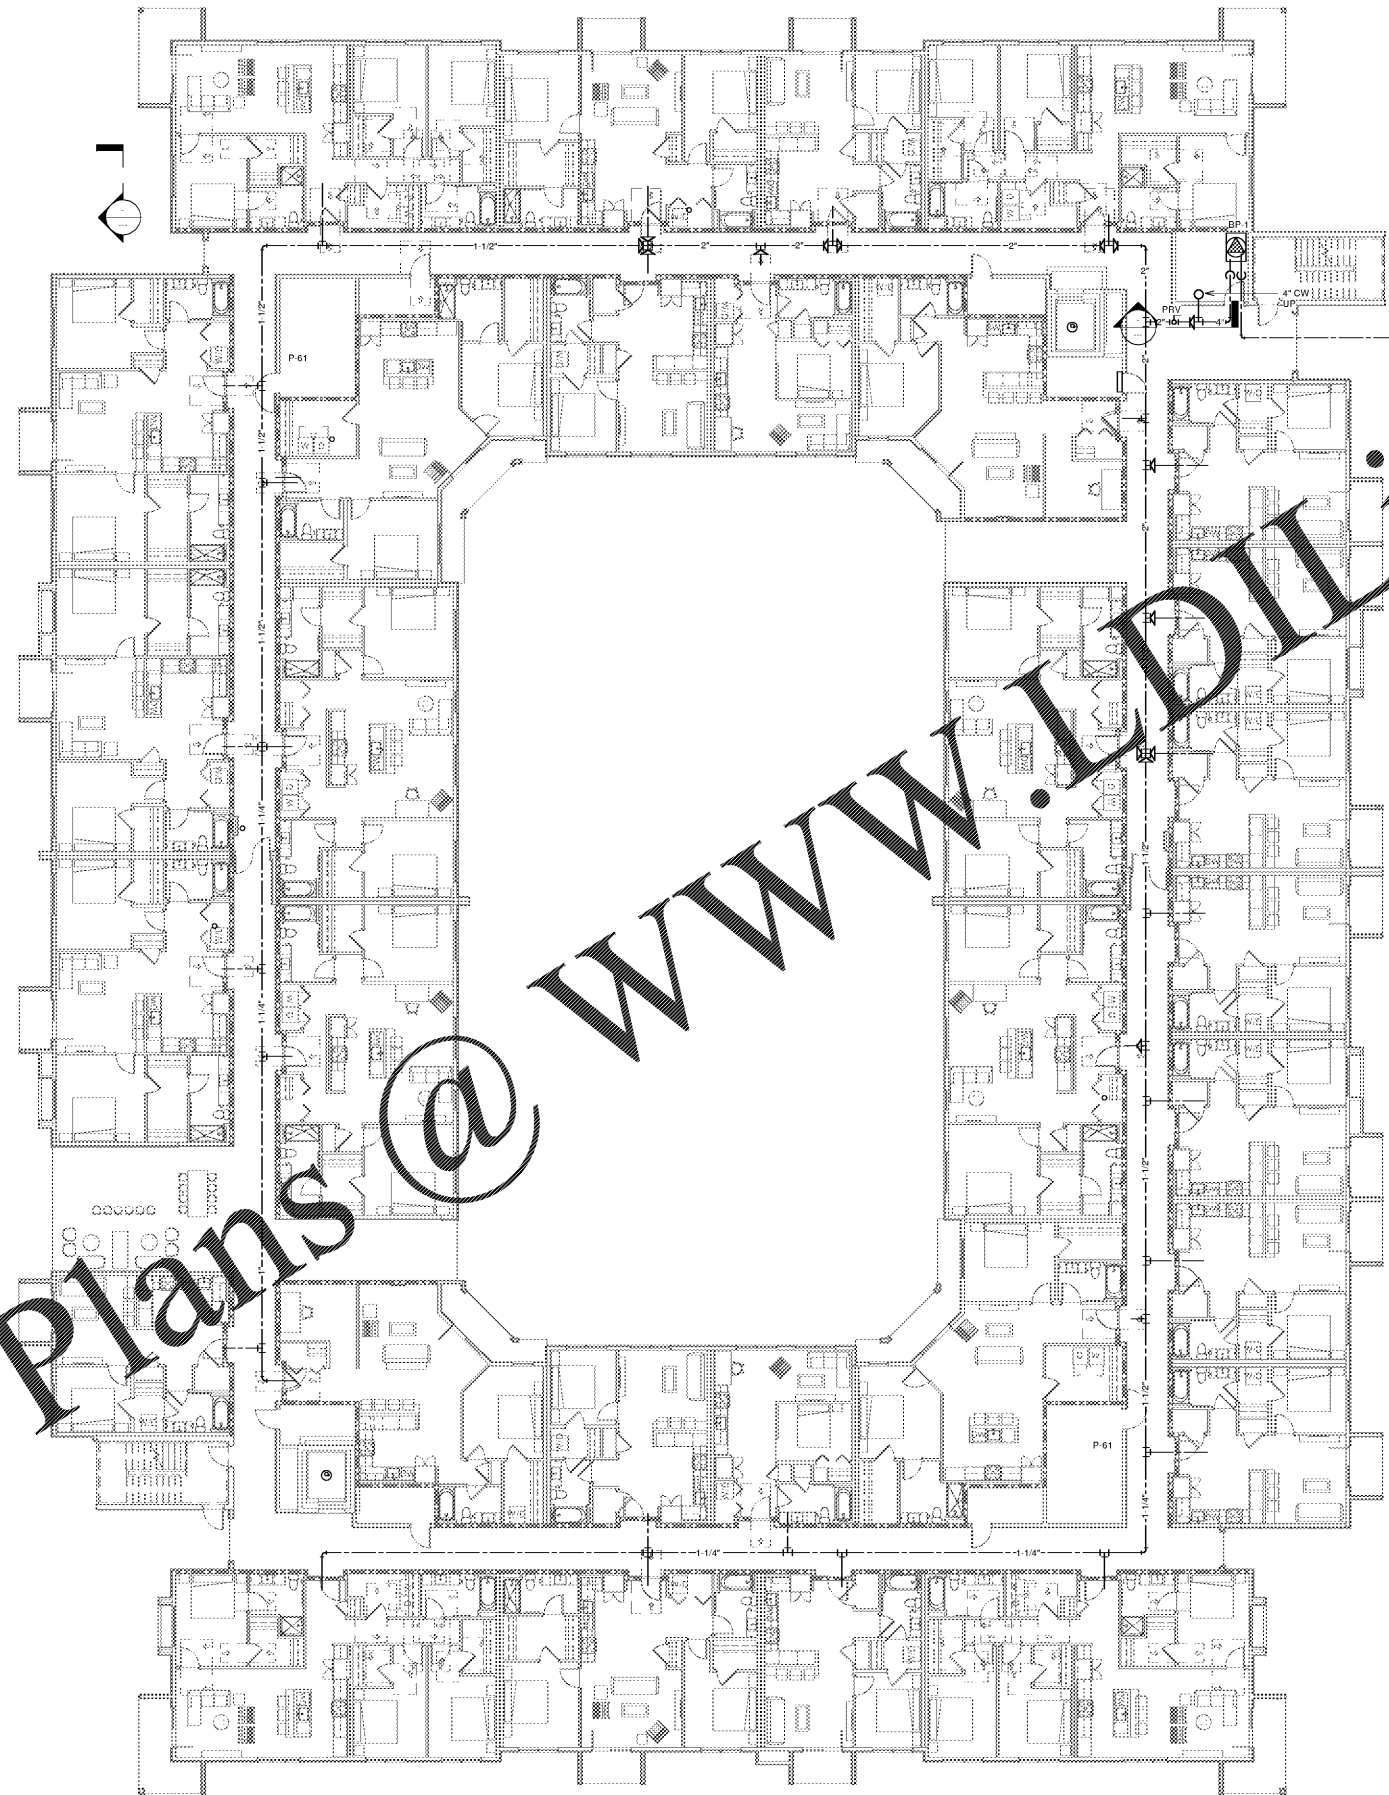

GENERAL NOTES:  
 a. SEE ENLARGED FLOOR PLANS FOR PIPING LOCATED IN UNITS.

1 WATER FLOOR 1  
 3/32" = 1'-0"

1925 Prospect Ave.  
 Orlando, FL 32814  
 P (407) 661-9100  
 F (407) 661-9101  
[www.r.p.e.com](http://www.r.p.e.com)

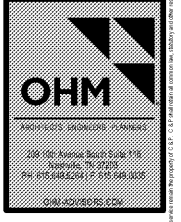

PROJECT NAME <b>ROCKLEDGE MULTI-FAMILY</b> 220 Baron Boulevard Rockledge, FL 32955	CLIENT NAME
---	-------------

SHEET TITLE <b>PLUMBING FIRST FLOOR WATER PIPING</b>
---

Revision Schedule	
No.	Description

PROJECT NO. 0540150010	CHECKED
DATE 20/04/16	CHECKER
DRAWN RUP	

P101

GMP PRICING SET