


Order Plans @ www.DIline.com

① WATER FLOOR 2
3/32" = 1'-0"

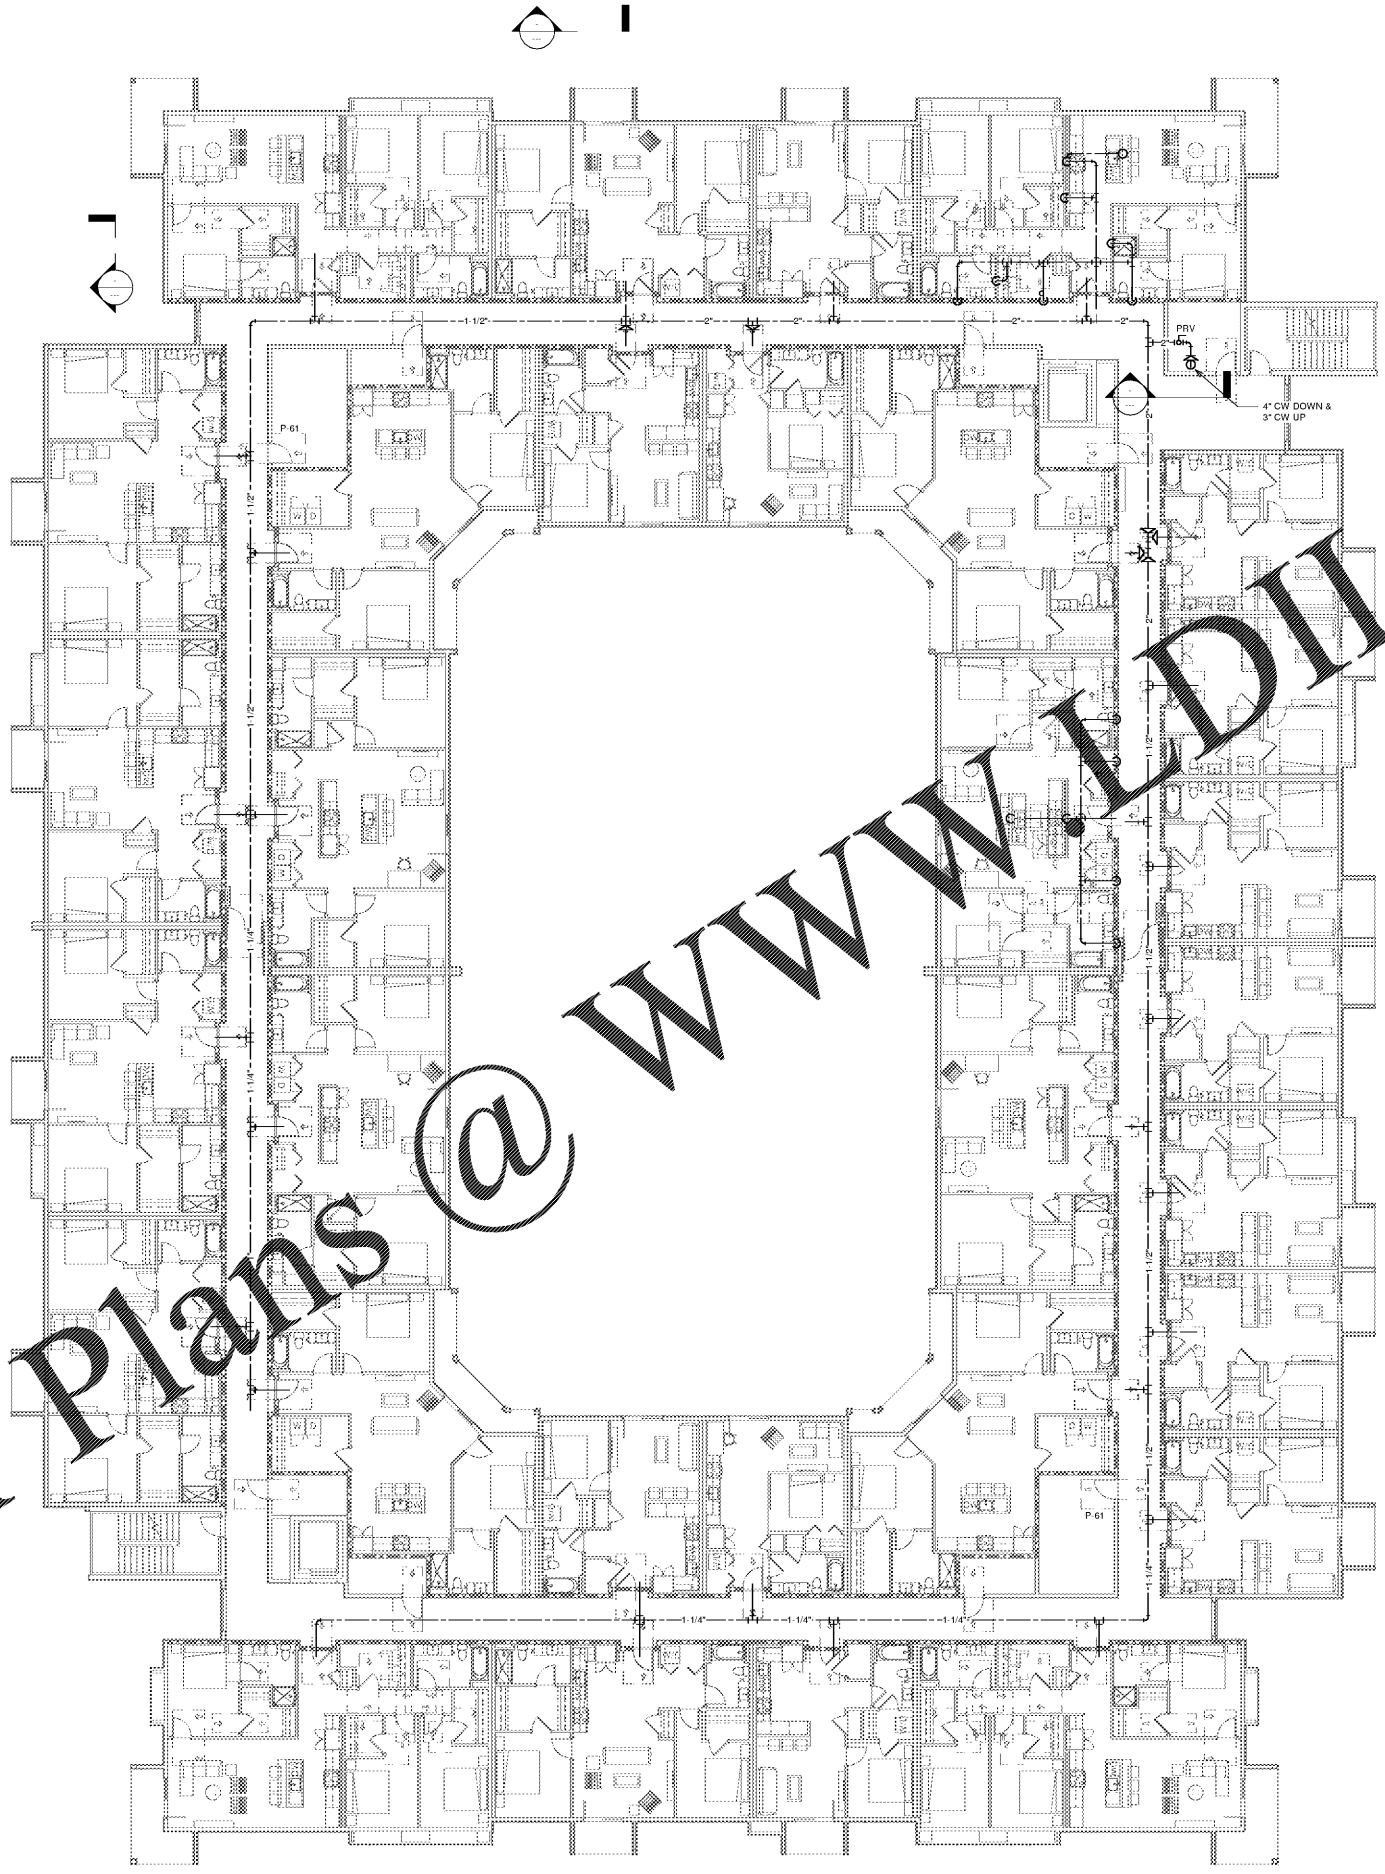

GENERAL NOTES:
a. SEE ENLARGED FLOOR PLANS FOR PIPING LOCATED IN UNITS.



P102

Revision Schedule	
No.	Description

PROJECT NO. 0540150010	DATE 20/04/16	DRAWN RJA	CHECKED
---------------------------	------------------	--------------	-------------

NOV 02, 2015

PROJECT NAME
ROCKLEDGE MULTI-FAMILY
220 Baron Boulevard
Rockledge, FL 32955

CLIENT NAME

PLUMBING SECOND FLOOR WATER PIPING



Cubacci & Peterson
Architects Engineers Planners

1925 Prospect Ave.
Orlando, FL 32814
P (407) 661-9100
F (407) 661-9101
www.c-p.com

GMP PRICING SET