


Order Plans @ [www.LDILine.com](http://www.LDILine.com)

1 WATER FLOOR 3  
3/32" = 1'-0"

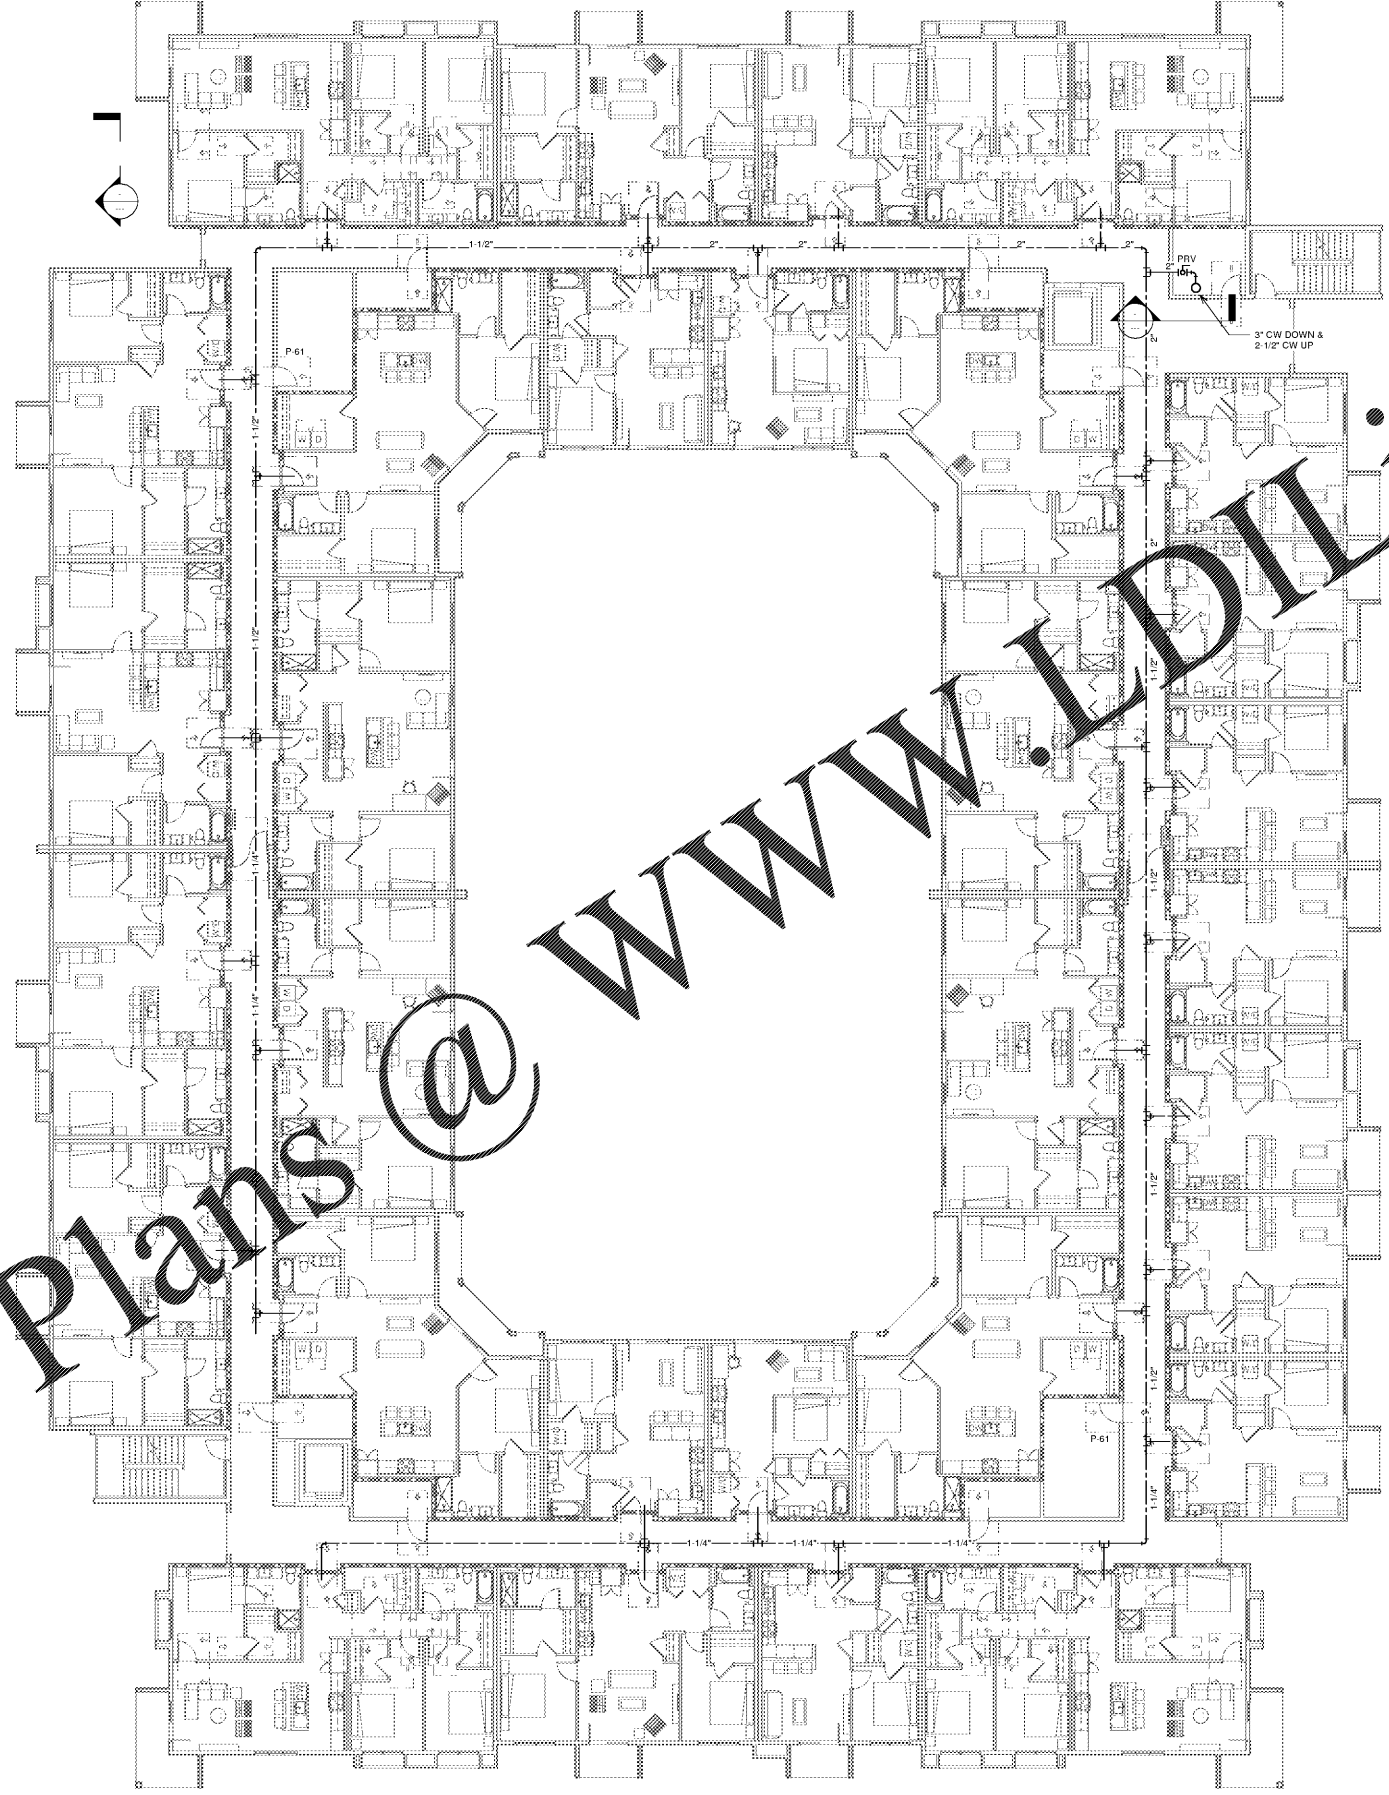

GENERAL NOTES:  
a. SEE ENLARGED FLOOR PLANS FOR PIPING LOCATED IN UNITS.

| Revision Schedule |             |
|-------------------|-------------|
| No.               | Description |
|                   |             |
|                   |             |

PROJECT NO. 0540150010

DATE 20/04/16

DRAWN [Signature]

CHECKED [Signature]

NOV 03, 2015


|   |             |
|---|-------------|
| PROJECT NAME<br><b>ROCKLEDGE MULTI-FAMILY</b><br>220 Baron Boulevard<br>Rockledge, FL 32955 | CLIENT NAME |
| SHEET TITLE<br><b>PLUMBING THIRD FLOOR WATER PIPING</b>                                     |             |

PROJECT NO. 0540150010

CLIENT NAME

PROJECT NAME  
**ROCKLEDGE MULTI-FAMILY**  
220 Baron Boulevard  
Rockledge, FL 32955

SHEET TITLE  
**PLUMBING THIRD FLOOR WATER PIPING**

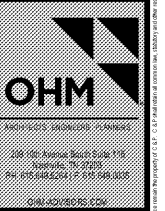

**Colucci & Peterson**  
Architects Engineers Planners  
www.c.p.a.com

1925 Prospect Ave.  
Orlando, FL 32814  
P (407) 661-9100  
F (407) 661-9101