


Order Plans @ [www.LDILine.com](http://www.LDILine.com)

① WATER FLOOR 4  
3/32" = 1'-0"

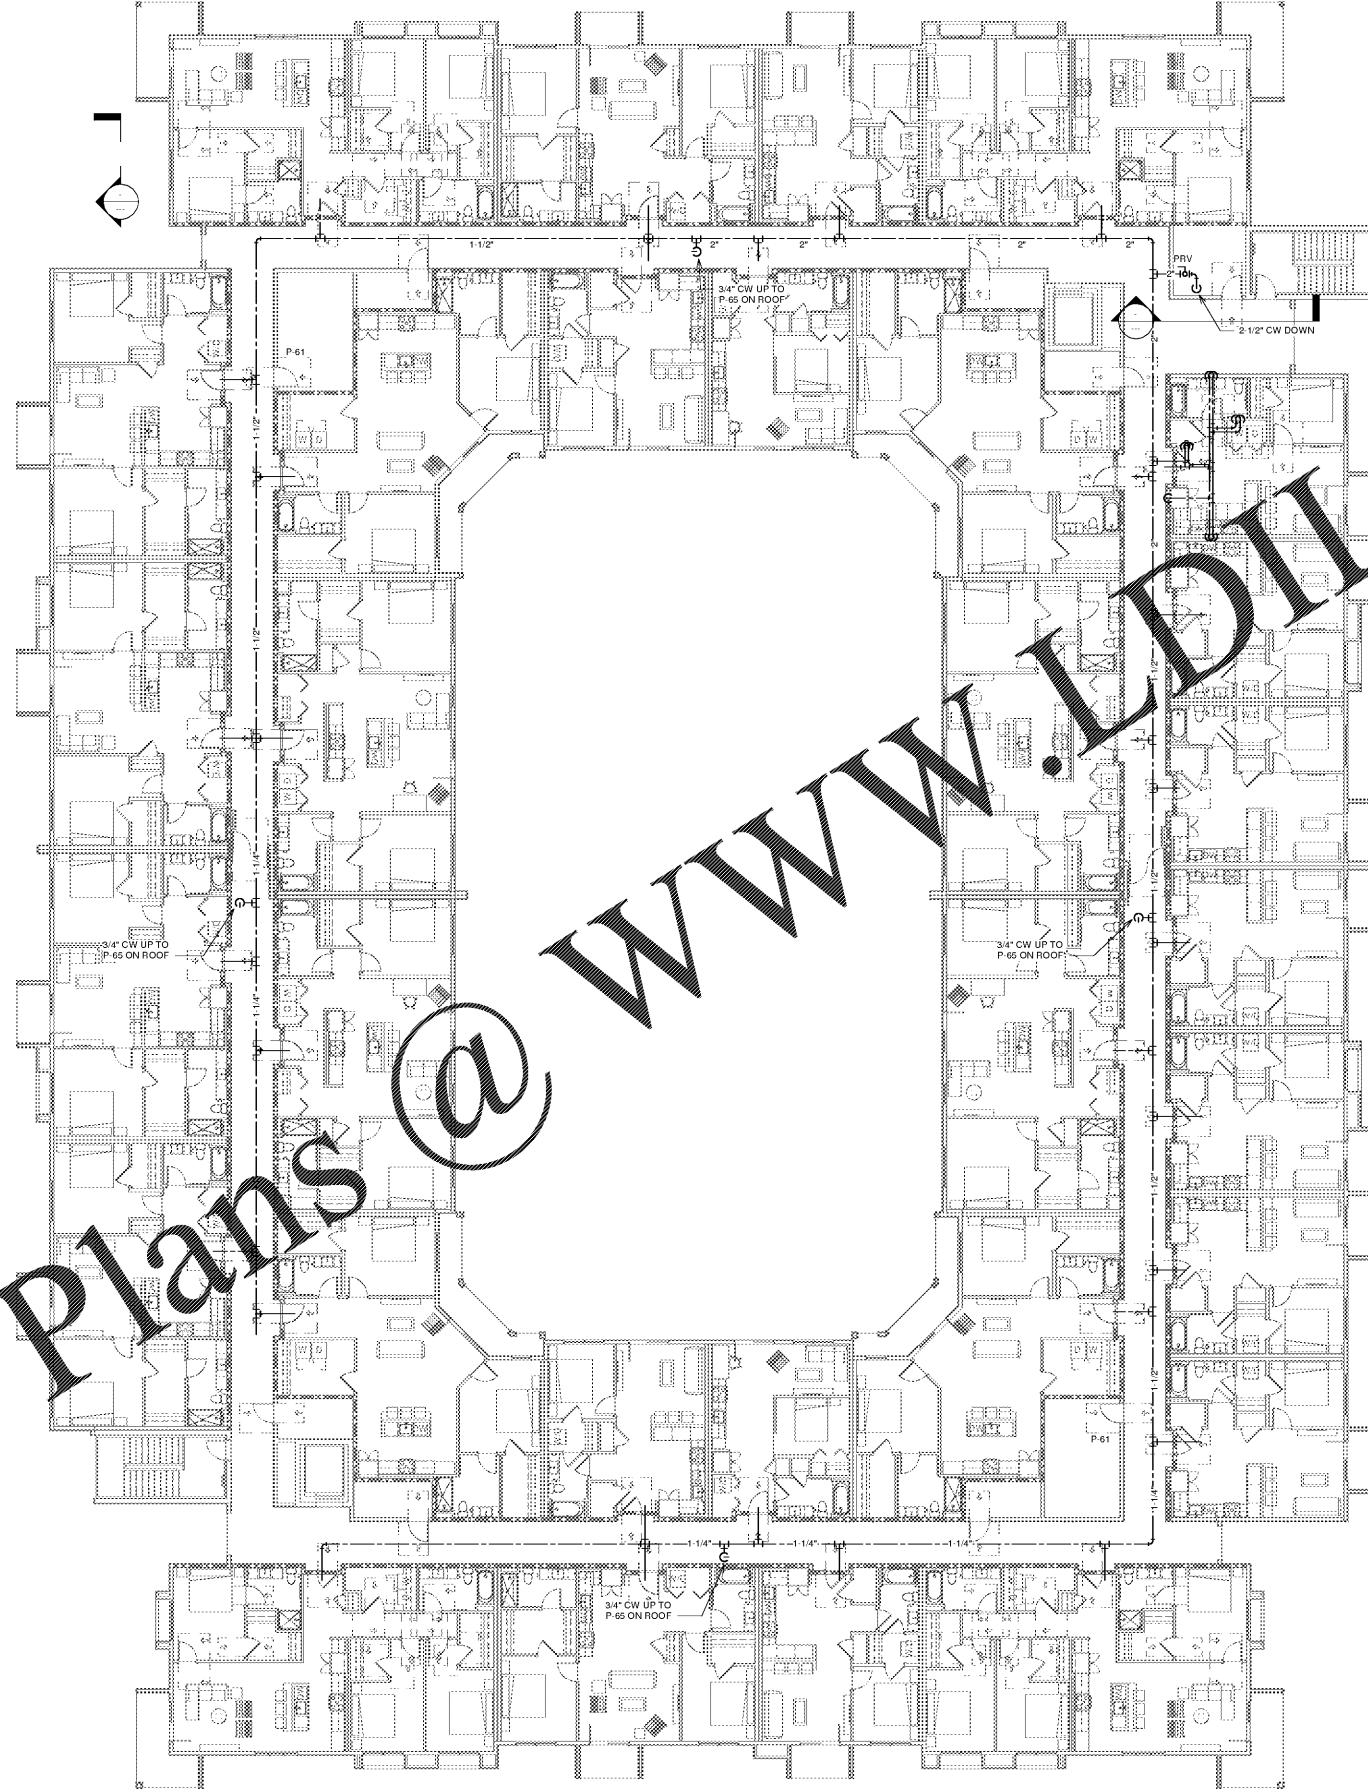

GENERAL NOTES:  
a. SEE ENLARGED FLOOR PLANS FOR PIPING LOCATED IN UNITS.



Revision Schedule	
No.	Description

PROJECT NO. 0540150010

DATE 20/04/16

DRAWN [Signature]

CHECKED [Signature]

NOV 02, 2015

PROJECT NAME <b>ROCKLEDGE MULTI-FAMILY</b> 220 Baron Boulevard Rockledge, FL 32955	CLIENT NAME
---	-------------

SHEET TITLE <b>PLUMBING FOURTH FLOOR WATER PIPING</b>	CLIENT NAME
--	-------------

PROJECT NAME <b>ROCKLEDGE MULTI-FAMILY</b> 220 Baron Boulevard Rockledge, FL 32955	CLIENT NAME
---	-------------



**Cabalaci & Peterson**  
Architects Engineers Planners

1925 Prospect Ave.  
Orlando, FL 32814  
P (407) 661-9100  
F (407) 661-9101  
[www.c-p.com](http://www.c-p.com)