



Order Plans @ www.LDILine.com

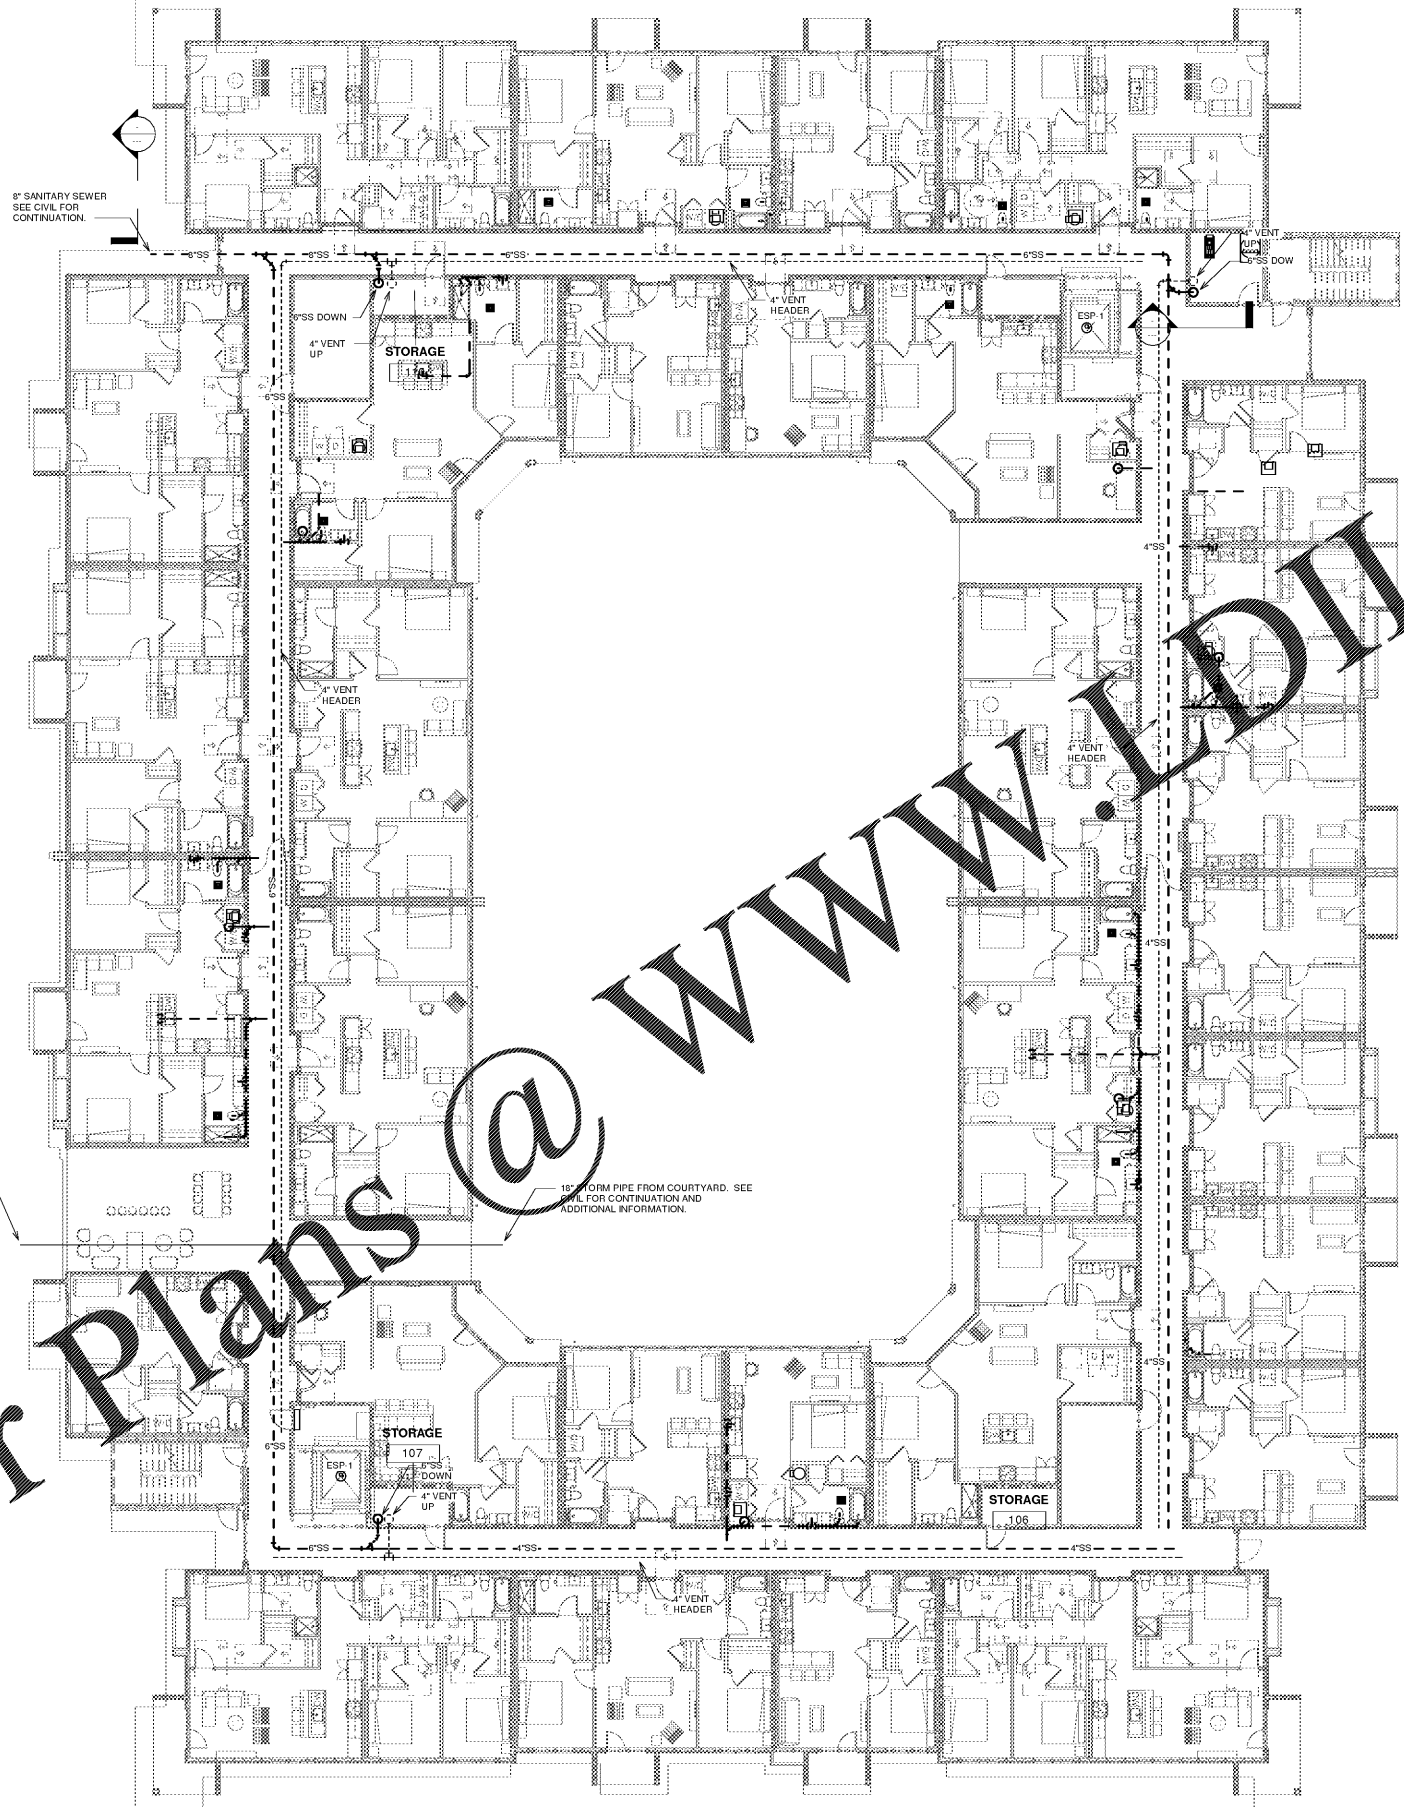

GENERAL NOTES:
 a. SEE ENLARGED FLOOR PLANS FOR PIPING LOCATED IN UNITS.

1 SANITARY SEWER FLOOR 1
 3/32" = 1'-0"

1925 Prospect Ave.
 Orlando, FL 32814
 P (407) 661-9100
 F (407) 661-9101
www.c-p.com

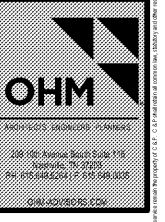

CLIENT NAME
 ROCKLEDGE MULTI-FAMILY
 220 Baron Boulevard
 Rockledge, FL 32955

PROJECT NAME
 ROCKLEDGE MULTI-FAMILY
 220 Baron Boulevard
 Rockledge, FL 32955

Revision Schedule	
No.	Description

PROJECT NO.
 0540150010
 DATE
 20/04/16
 DRAWN
 DATE
 CHECKED
 CHECKER

P201

GMP PRICING SET

NOV 03, 2015

PLUMBING FIRST FLOOR WASTE PIPING

CLIENT NAME

Vertical text on the right margin containing project and company information.