



Order Plans @ www.LDILine.com

① SANITARY SEWER FLOOR 3
3/32" = 1'-0"

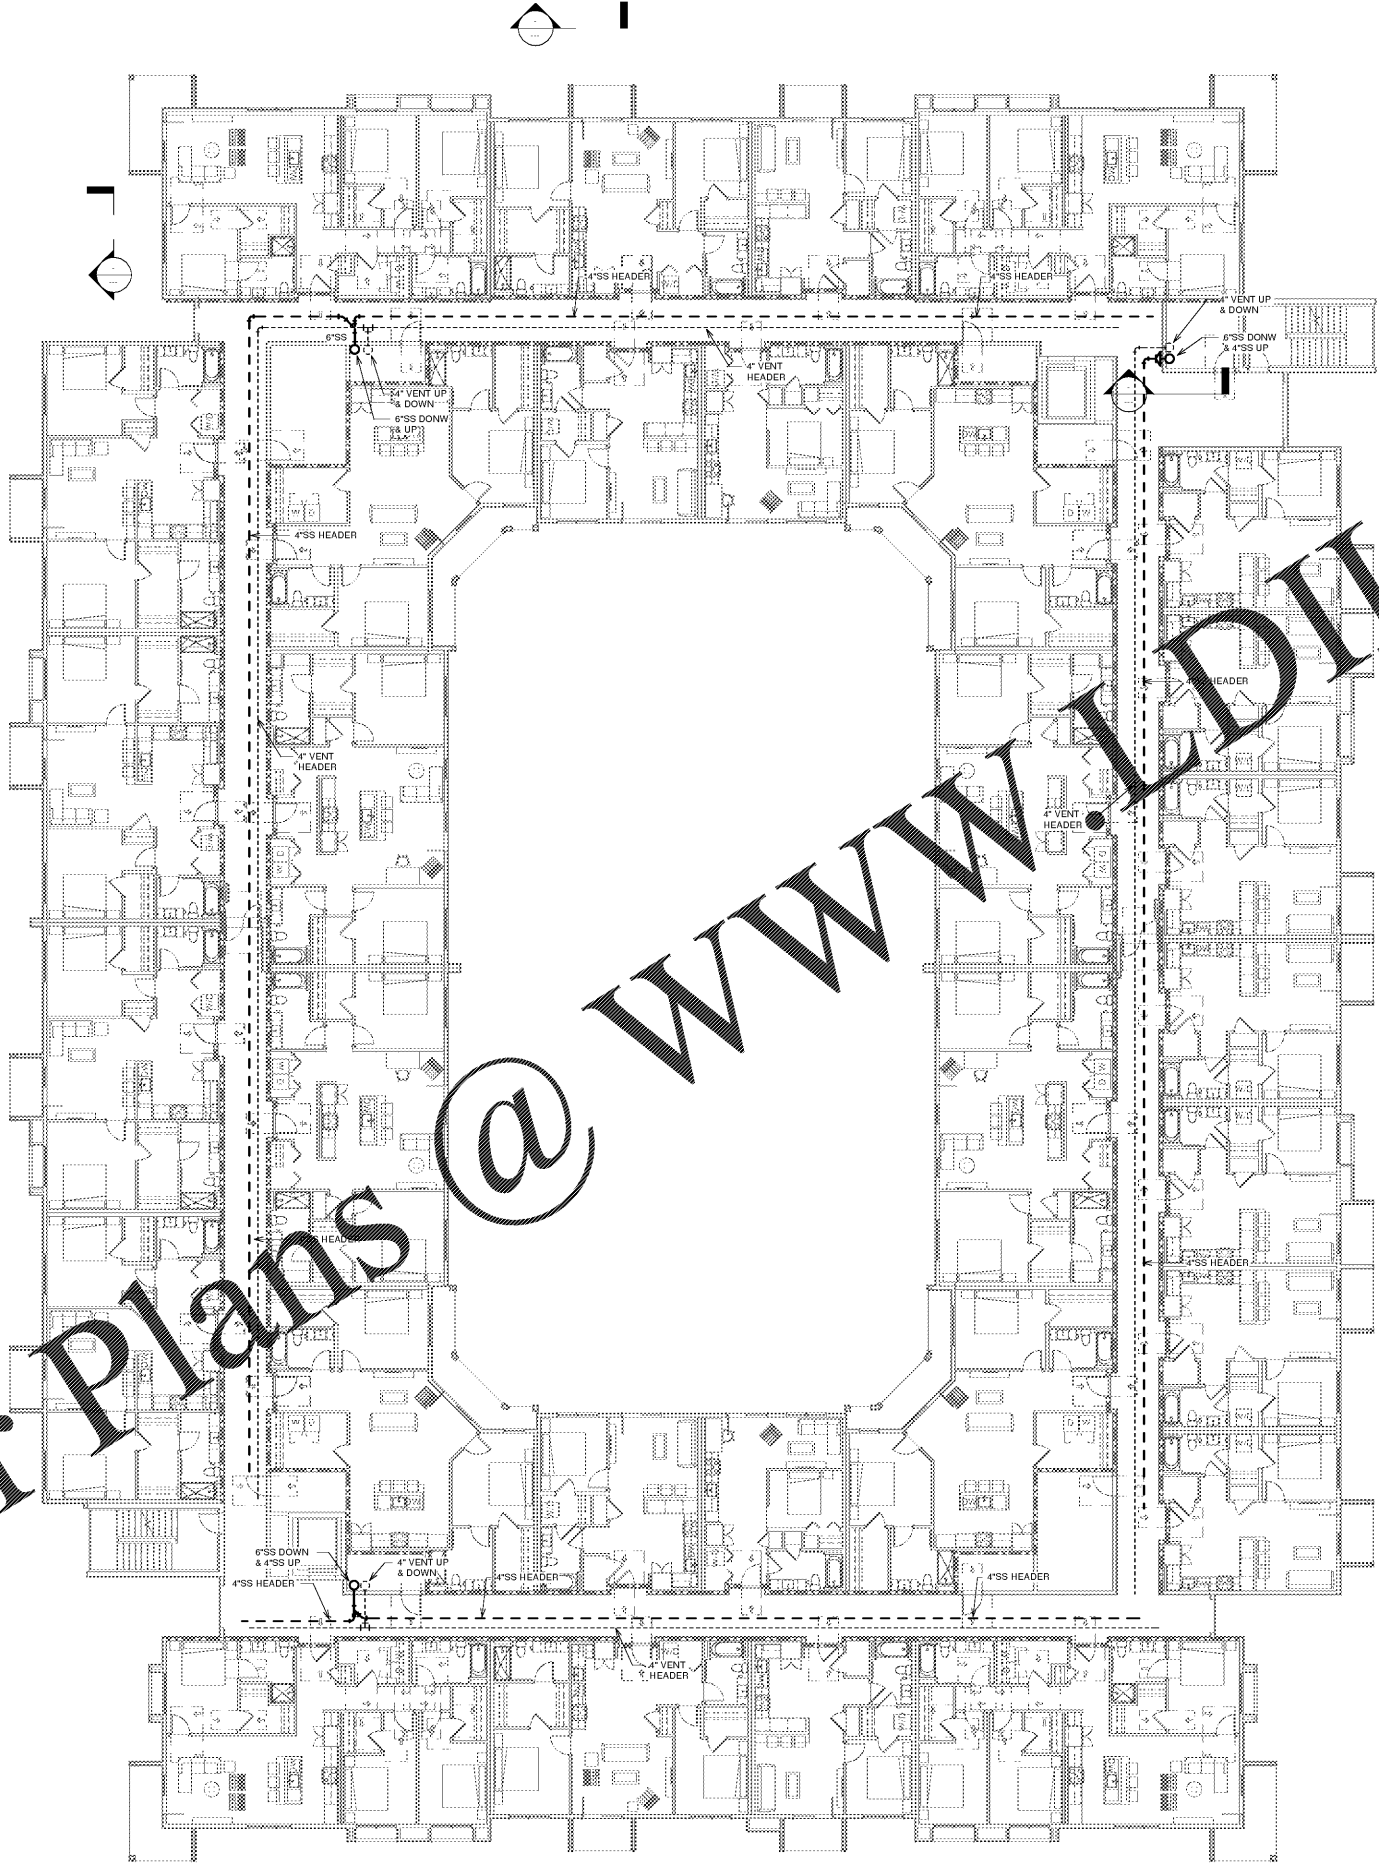

GENERAL NOTES:
a. SEE ENLARGED FLOOR PLANS FOR PIPING LOCATED IN UNITS.

1925 Prospect Ave.
Orlando, FL 32814
P (407) 661-9100
F (407) 661-9101
www.r.p.e.com

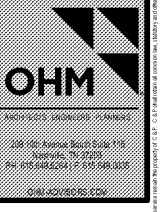

PROJECT NAME ROCKLEDGE MULTI-FAMILY 220 Baron Boulevard Rockledge, FL 32955	CLIENT NAME
SHEET TITLE PLUMBING THIRD FLOOR WASTE PIPING	

Revision Schedule	
No.	Description

PROJECT NO. 0540150010	CHECKED
DATE 20/04/16	CHECKER
DRAWN RUP	

P203

GMP PRICING SET

PROJECT NO. 0540150010 - 11/16/15
 SHEET NO. P203 - 11/16/15
 DATE PLOTTED: 11/16/15
 PLOTTER: HP DesignJet T1100PS
 USER: r.p.e.
 C:\Users\r.p.e.\Desktop\0540150010\0540150010_P203.dwg
 PLOT SCALE: 1/8" = 1'-0"
 PLOT AREA: 11.00 x 17.00
 PLOT OFFSET: 0.50 x 0.50
 PLOT ORIENTATION: Landscape
 PLOT RANGE: All
 PLOT METHOD: Plot
 PLOT DEVICE: HP DesignJet T1100PS
 PLOT STATUS: Success
 PLOT TIME: 00:00:00
 PLOT DATE: 11/16/15 10:00:00 AM
 PLOT USER: r.p.e.