


Order Plans @ [www.LDILine.com](http://www.LDILine.com)

① SANITARY SEWER FLOOR 4  
3/32" = 1'-0"

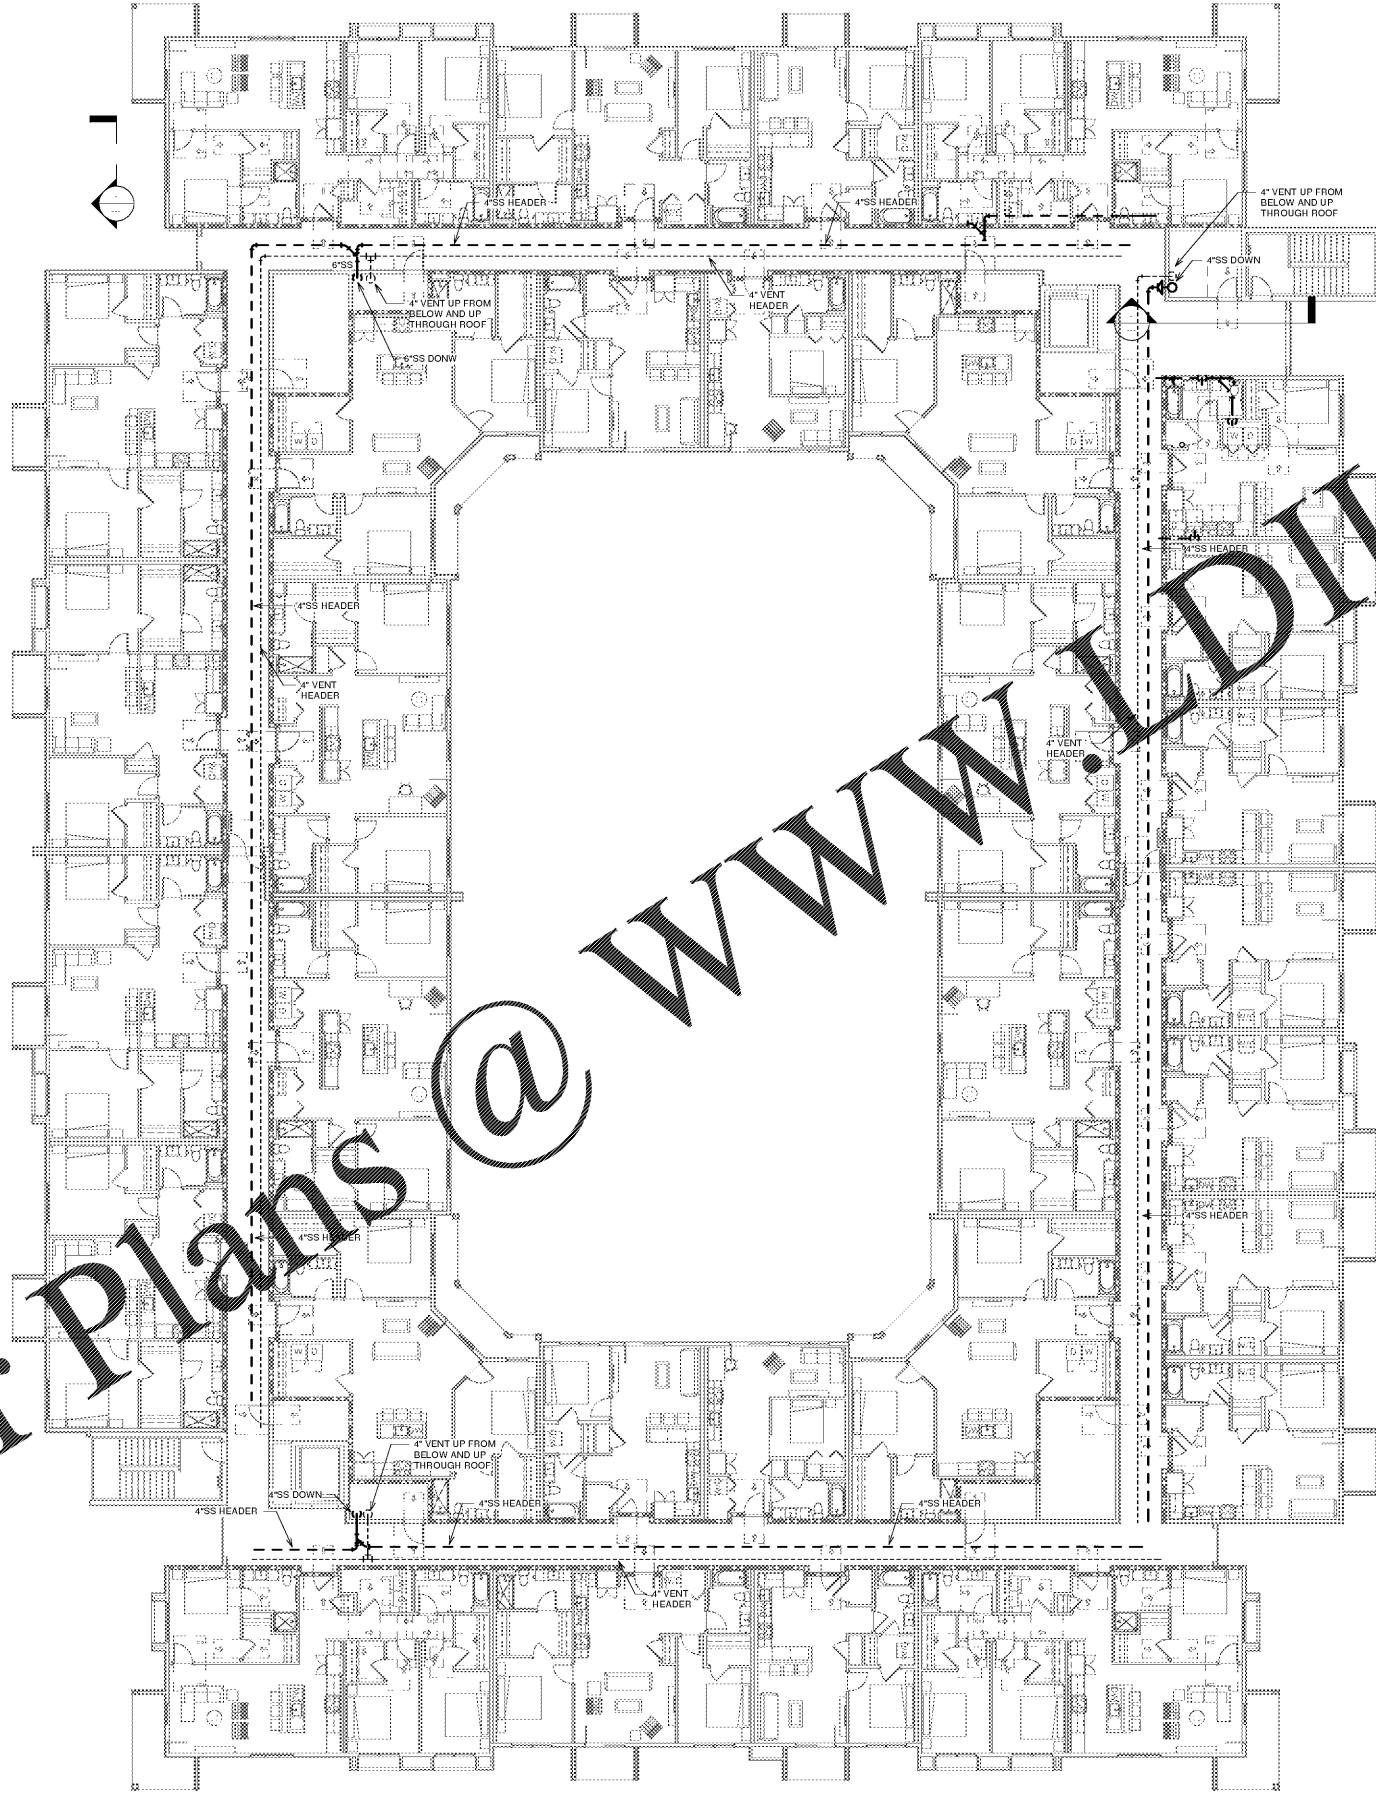

GENERAL NOTES:  
a. SEE ENLARGED FLOOR PLANS FOR PIPING LOCATED IN UNITS.



**Calacaci & Peterson**  
Architects Engineers Planners

1925 Prospect Ave.  
Orlando, FL 32814  
P (407) 661-9100  
F (407) 661-9101  
[www.c&p.com](http://www.c&p.com)

PROJECT NAME <b>ROCKLEDGE MULTI-FAMILY</b> 220 Baron Boulevard Rockledge, FL 32955	CLIENT NAME
SHEET TITLE <b>PLUMBING FOURTH FLOOR WASTE PIPING</b>	

NOV 02, 2015

Revision Schedule		
No.	Description	Date

PROJECT NO. 0540150010	CHECKED 
DATE 20/04/15	CHECKER 
DRAWN 	

P204

GMP PRICING SET