



① UNIT PLAN - A1A-BEDROOM SS
1/4" = 1'-0"

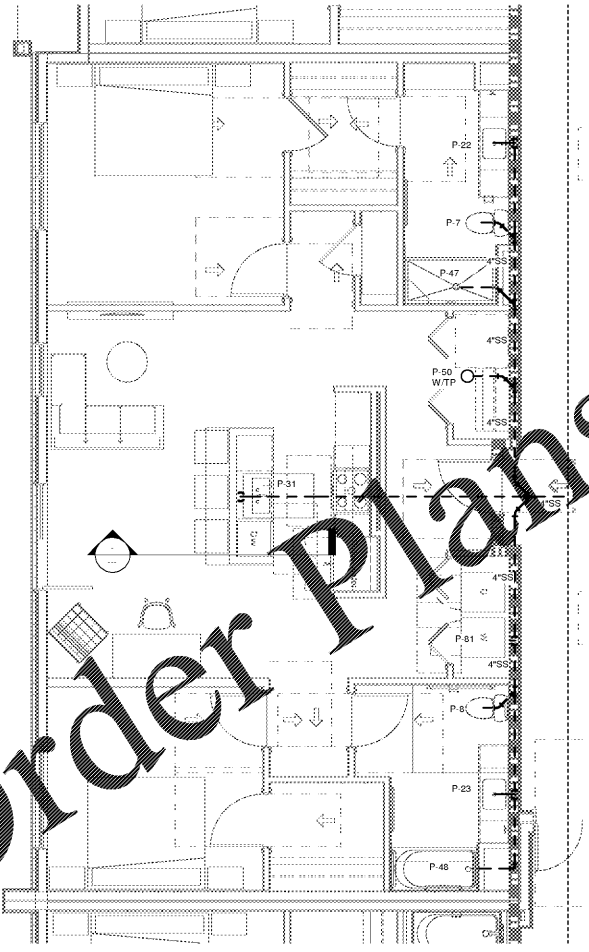

② UNIT PLAN - B4A-BEDROOM SS
1/4" = 1'-0"

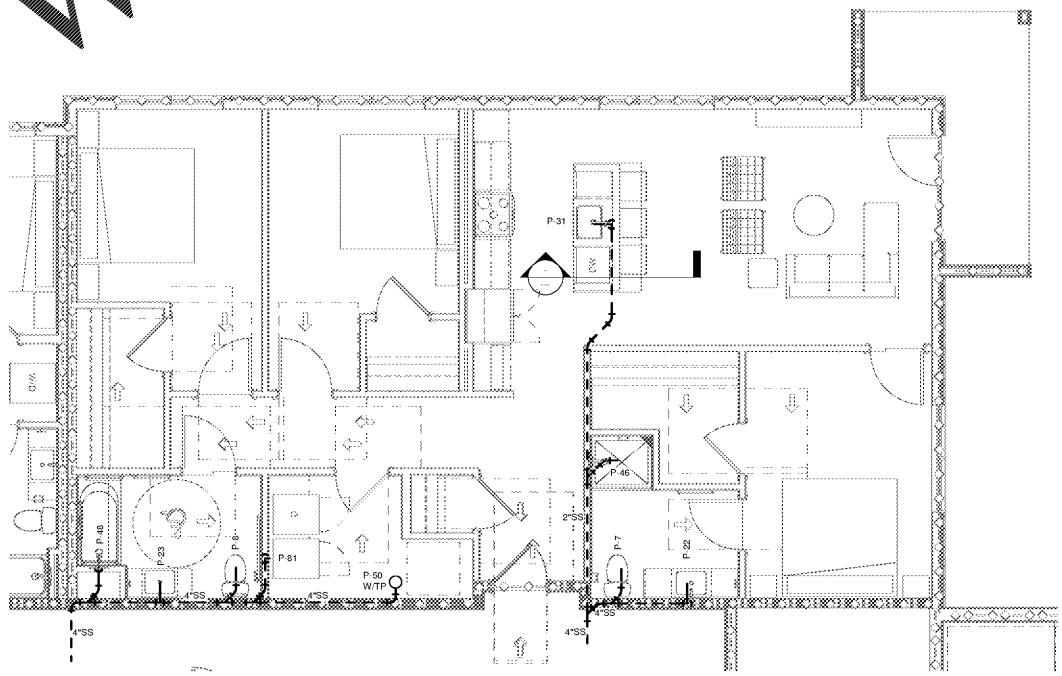


③ UNIT PLAN - C1A-BEDROOM SS
1/4" = 1'-0"

GENERAL NOTES:
a. SANITARY SEWER MAIN LEAVING UNITS SHALL CONNECT TO WASTE HEADER LOCATED IN CORRIDOR. SEE OVER ALL FLOOR PLAN FOR ADDITIONAL INFORMATION.

Order Plans @ www.LDILine.com

1925 Prospect Ave.
Orlando, FL 32814
P (407) 661-9100
F (407) 661-9101
www.r.p.com

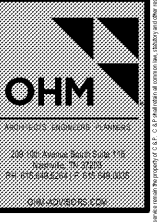

IDENTIFY
CLIENT NAME

PROJECT NAME
ROCKLEDGE MULTI-FAMILY
220 Baron Boulevard
Rockledge, FL 32955

SHEET TITLE
PLUMBING ENLARGED PLANS

Revision Schedule	
No.	Description

PROJECT NO.
0540150010

DATE
20/04/16

DESIGNER
[Signature]

CHECKED
[Signature]

GMP PRICING SET