


1 POWER PLAN B - 1ST FLOOR
1/8" = 1'-0"

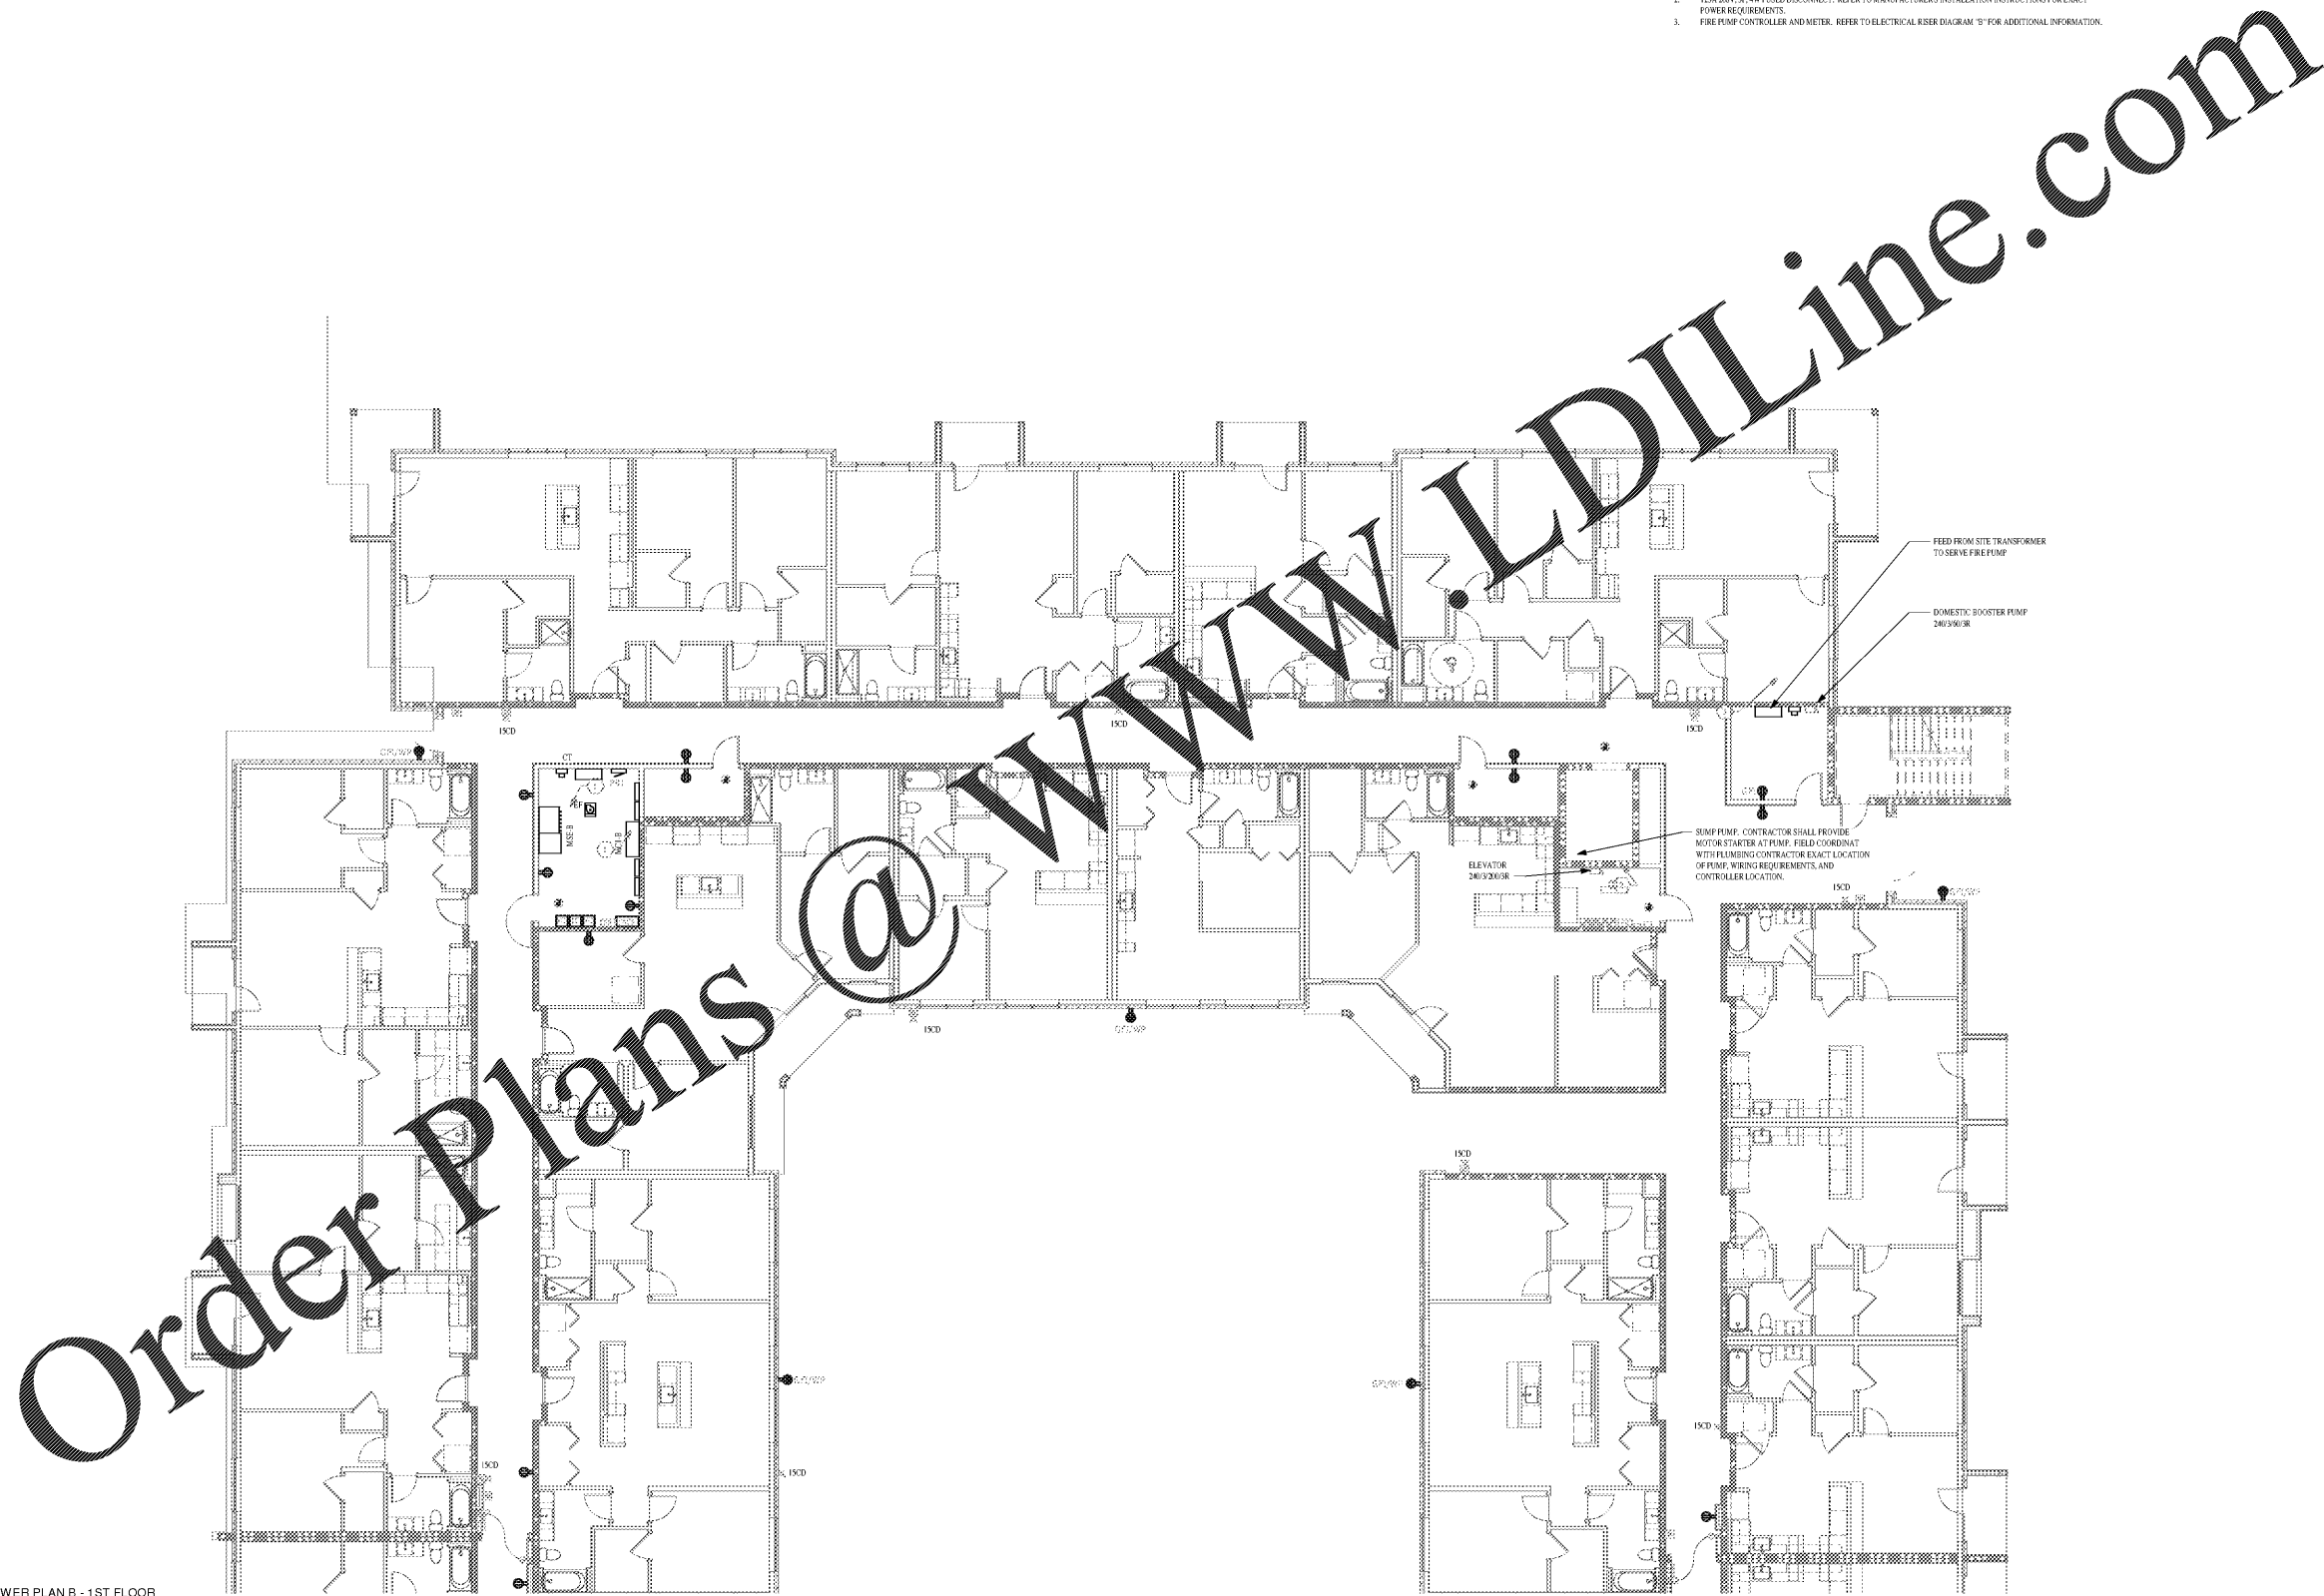

KEYNOTES

1. REFER TO ELECTRICAL RISER DIAGRAM 'D' FOR ADDITIONAL INFORMATION.
2. 125A-200V, 3Ø, 4W FEED DISCONNECT. REFER TO MANUFACTURER'S INSTALLATION INSTRUCTIONS FOR EXACT POWER REQUIREMENTS.
3. FIRE PUMP CONTROLLER AND METER. REFER TO ELECTRICAL RISER DIAGRAM 'D' FOR ADDITIONAL INFORMATION.

1925 Prospect Ave.
Orlando, FL 32814
P (407) 661-9100
F (407) 661-9101
www.r.p.e.com



ARCHITECTS ENGINEERS PLANNERS
2001 W. Colonial Blvd. Suite 200
Orlando, FL 32805
407-661-9100
407-661-9101
www.r.p.e.com

PROJECT NO. 0540150010		CLIENT NAME ROCKLEDGE MULTI-FAMILY	
DATE 20/04/10		PROJECT NAME 220 Baron Boulevard Rockledge, FL 32955	
DRAWN [Signature]		SHEET TITLE FIRST FLOOR POWER PLAN B	
CHECKED [Signature]		NOV 03, 2015	
Revision Schedule		Revision Schedule	
No.	Description	Date	Date

E102B

GMP PRICING SET