


Order Plans @ www.LDILine.com

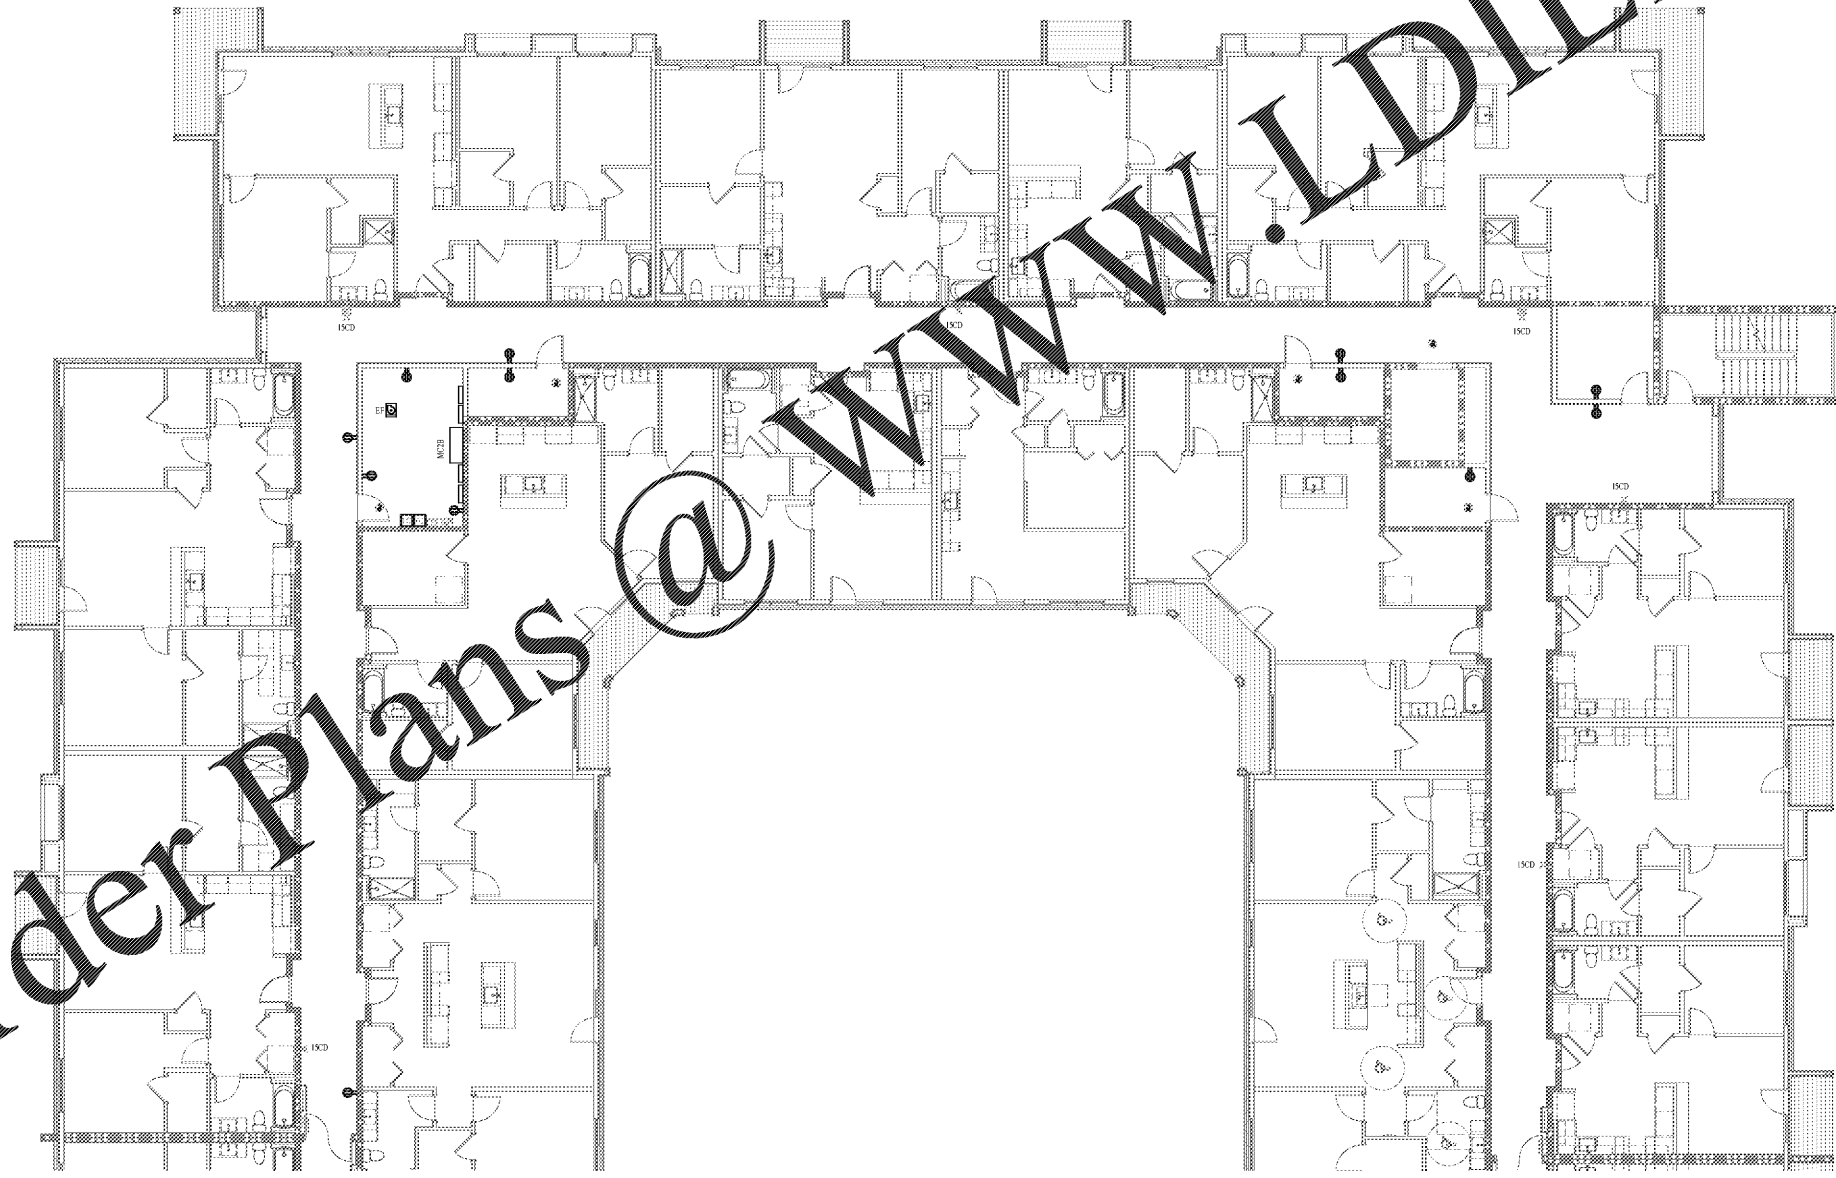

POWER PLAN B - 2ND FLOOR
1/8" = 1'-0"

Revision Schedule	
No.	Description

PROJECT NO. 054015000	DATE 20/04/10	DRAWN AUFAR	CHECKED
--------------------------	------------------	----------------	-------------

NOV 03, 2015

E202B

PROJECT NAME
ROCKLEDGE MULTI-FAMILY
220 Baron Boulevard
Rockledge, FL 32955

CLIENT NAME

CLIENT NAME



1925 Prospect Ave.
Orlando, FL 32814
P (407) 661-9100
F (407) 661-9101
www.culaci.com

GMP PRICING SET