


Order Plans @ www.LDILine.com

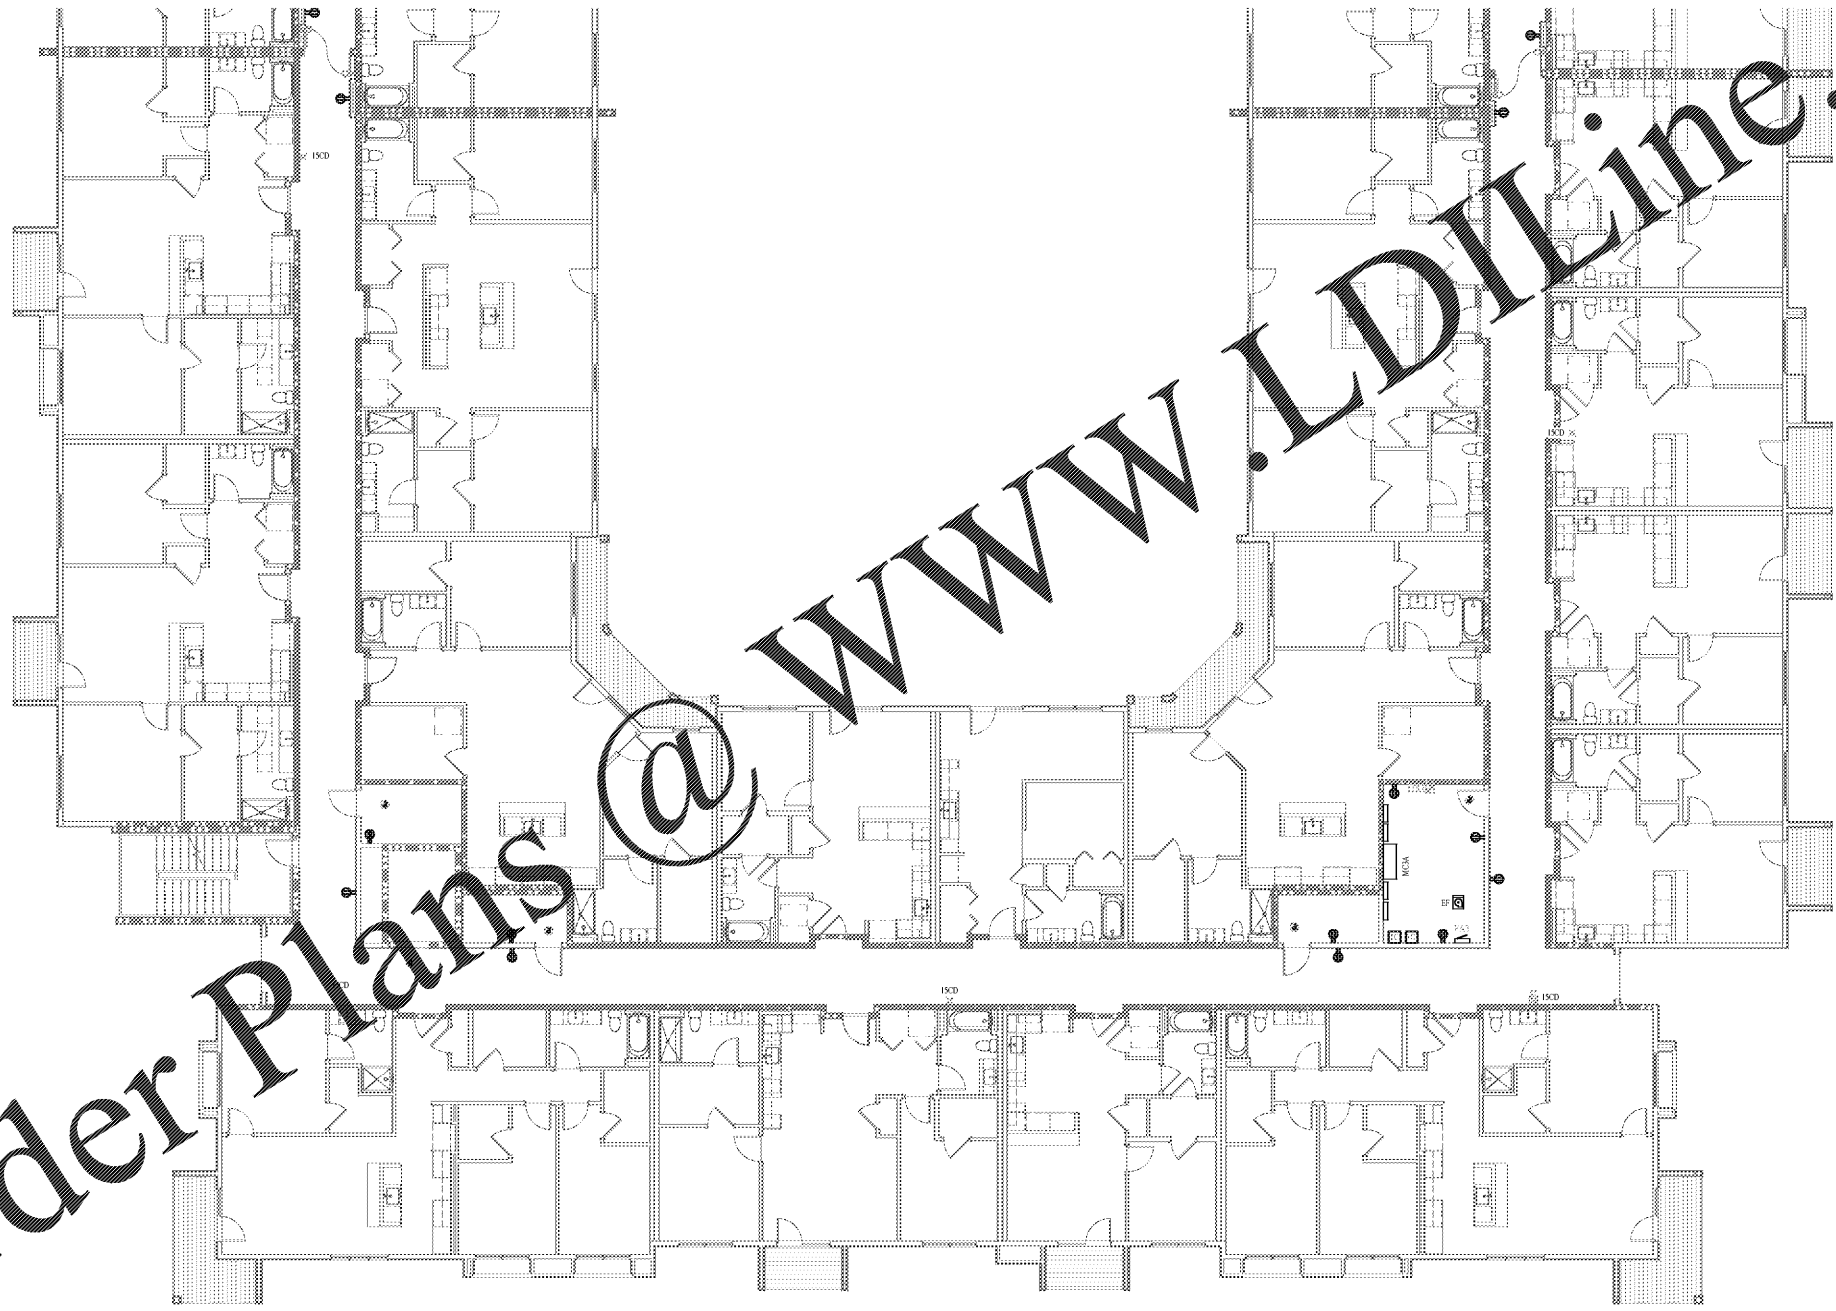

① POWER PLAN A - 3RD FLOOR
1/8" = 1'-0"

Revision Schedule	
No.	Description

PROJECT NO. 0540150010	DATE 20/04/10	DESIGNER [Signature]	CHECKED [Signature]
---------------------------	------------------	-------------------------	------------------------

NOV 03, 2015

E302A

PROJECT NAME
ROCKLEDGE MULTI-FAMILY
220 Baron Boulevard
Rockledge, FL 32955

SHEET TITLE
THIRD FLOOR POWER PLAN A

CLIENT NAME



1925 Prospect Ave.
Orlando, FL 32814
P (407) 661-9100
F (407) 661-9101
www.c-p.com

GMP PRICING SET