


1 POWER PLAN A - 4TH FLOOR
1/8" = 1'-0"

Order Plans @ WWW.LDILINE.COM

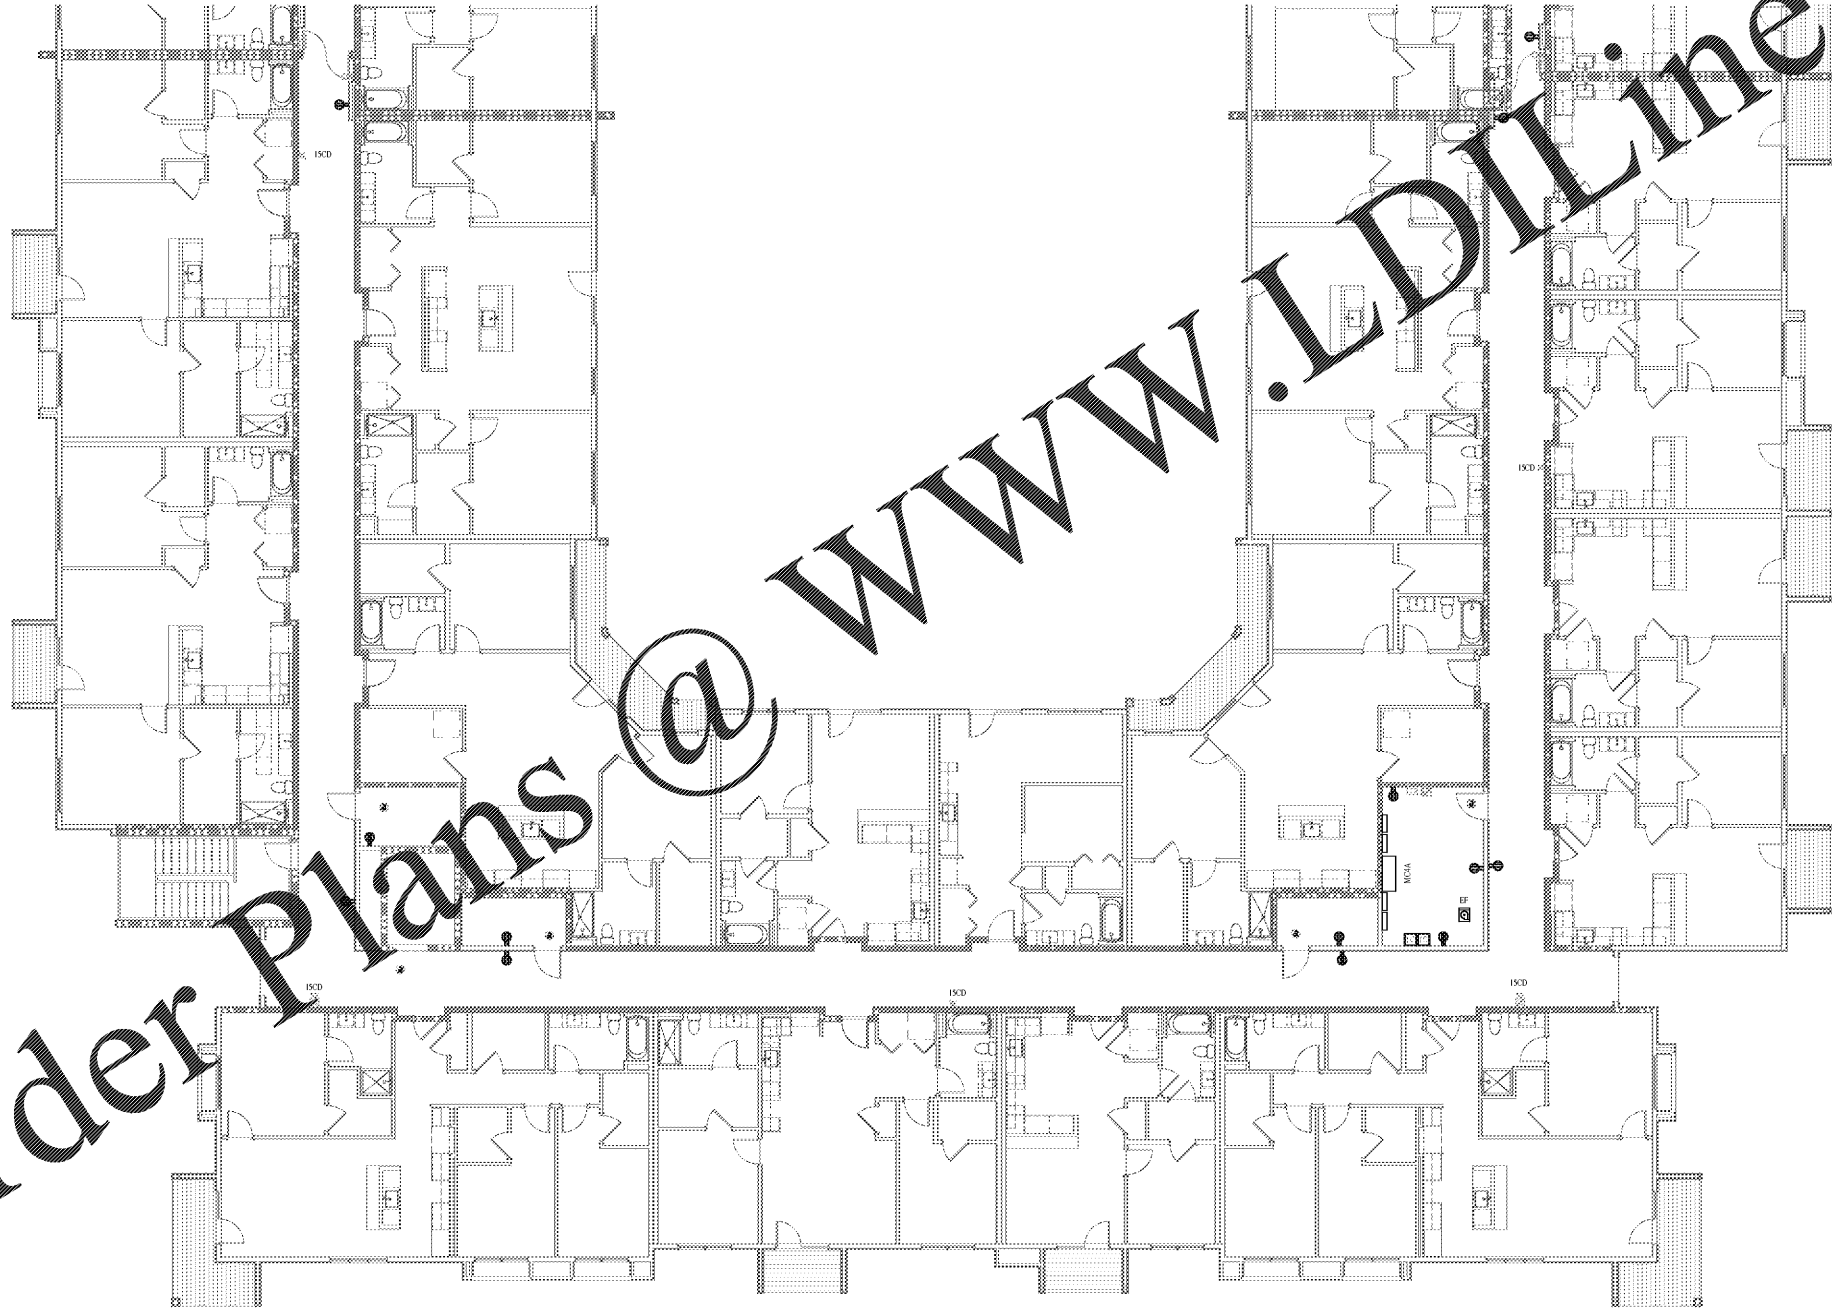

Revision Schedule	
No.	Date

PROJECT NO.
054-15010
DATE
20/01/10
DRAWN
RUF
CHECKED

PROJECT NAME
ROCKLEDGE MULTI-FAMILY
220 Baron Boulevard
Rockledge, FL 32955

CLIENT NAME

SHEET TITLE
FOURTH FLOOR POWER PLAN A

E402A

NOV 03, 2015
GMP PRICING SET



1925 Prospect Ave.
Orlando, FL 32814
P (407) 661-9100
F (407) 661-9101
www.c&p.com