


Order Plans @ www.LDILine.com

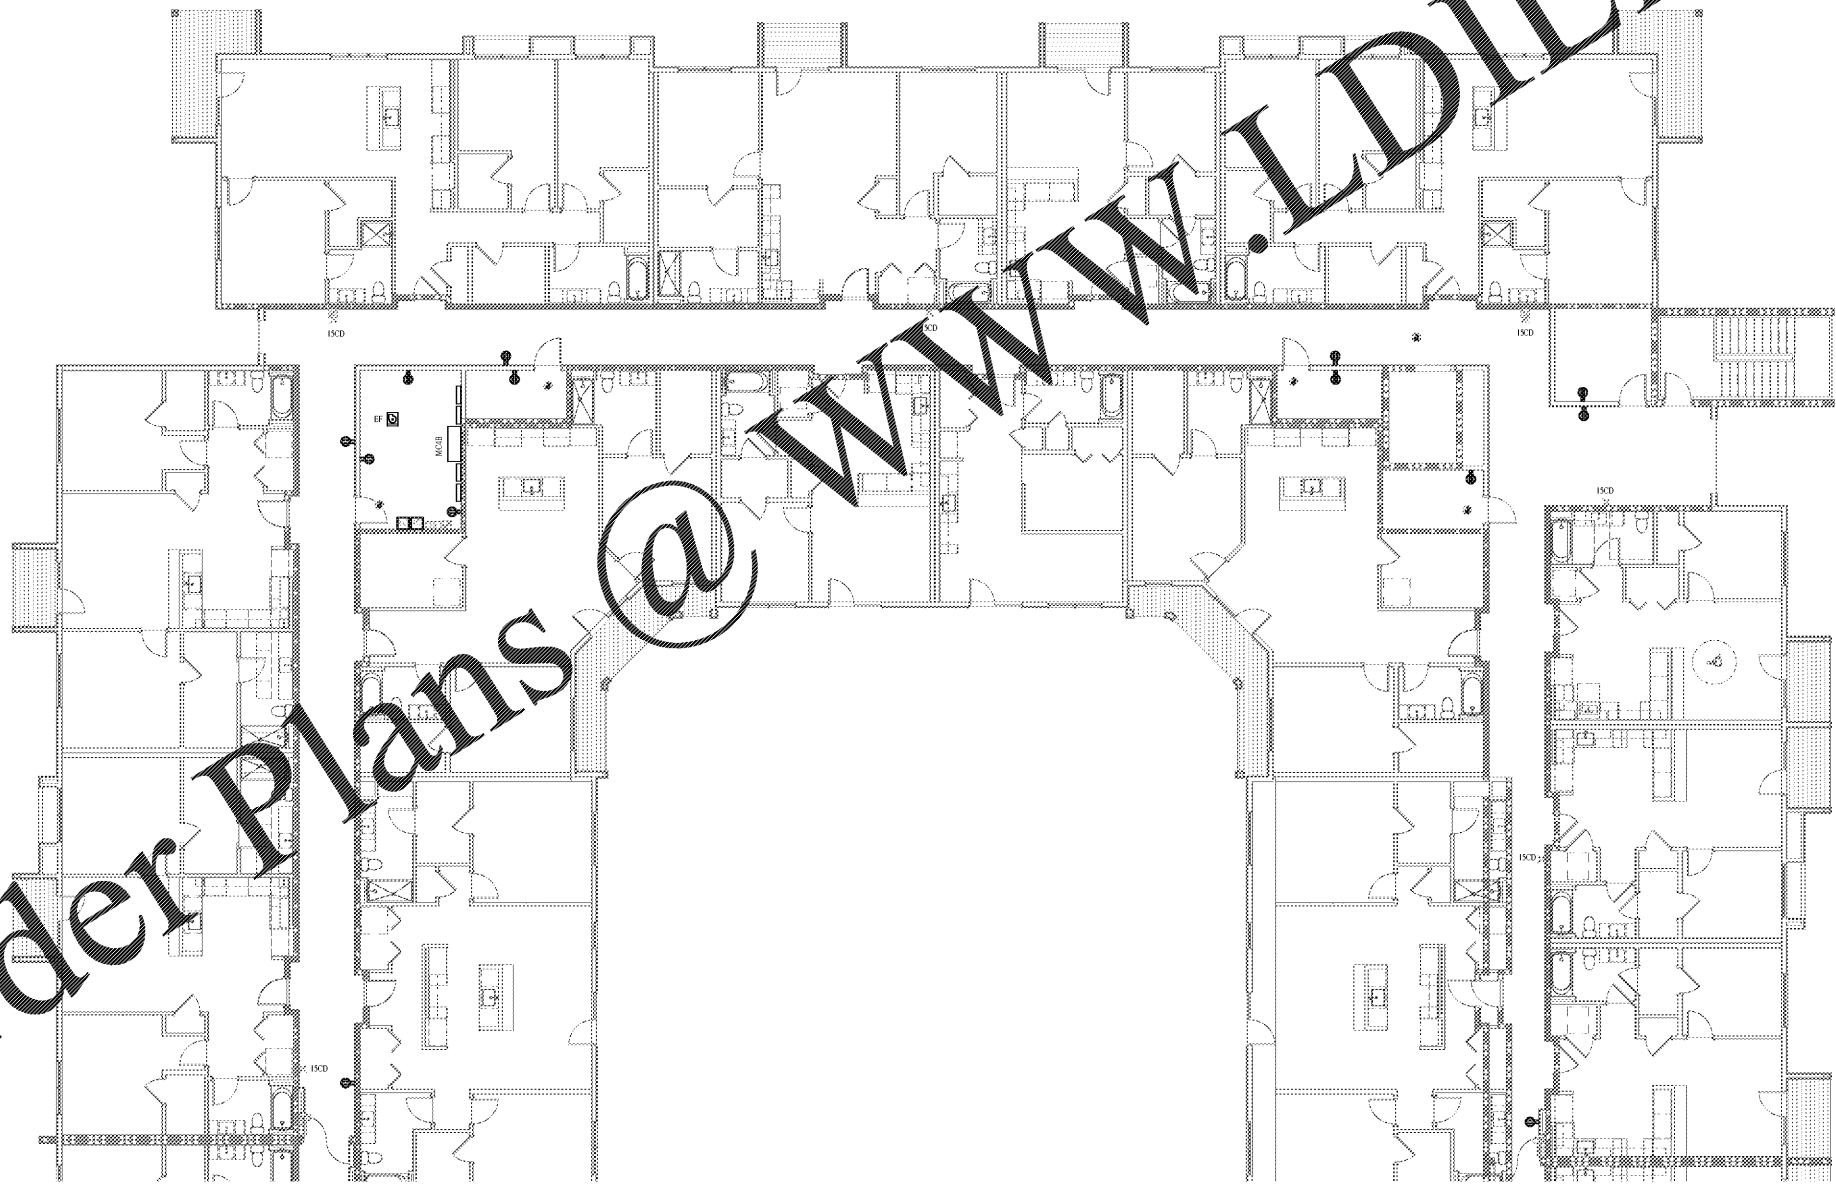

1 POWER PLAN B - 4TH FLOOR
1/8" = 1'-0"

Revision Schedule	
No.	Description

No.	Description	Date

PROJECT NO. 0540150010	DATE 20/04/10	DRAWN [Signature]	CHECKED [Signature]
---------------------------	------------------	----------------------	------------------------

PROJECT NAME ROCKLEDGE MULTI-FAMILY 220 Baron Boulevard Rockledge, FL 32955	CLIENT NAME
--	-------------

PROJECT TITLE FOURTH FLOOR POWER PLAN B	CLIENT NAME
--	-------------

PROJECT TITLE FOURTH FLOOR POWER PLAN B	CLIENT NAME
--	-------------



1925 Prospect Ave.
Orlando, FL 32814
P (407) 661-9100
F (407) 661-9101
www.c&p.com

E402B

GMP PRICING SET