



Order Plans @ WWW.LDILine.com

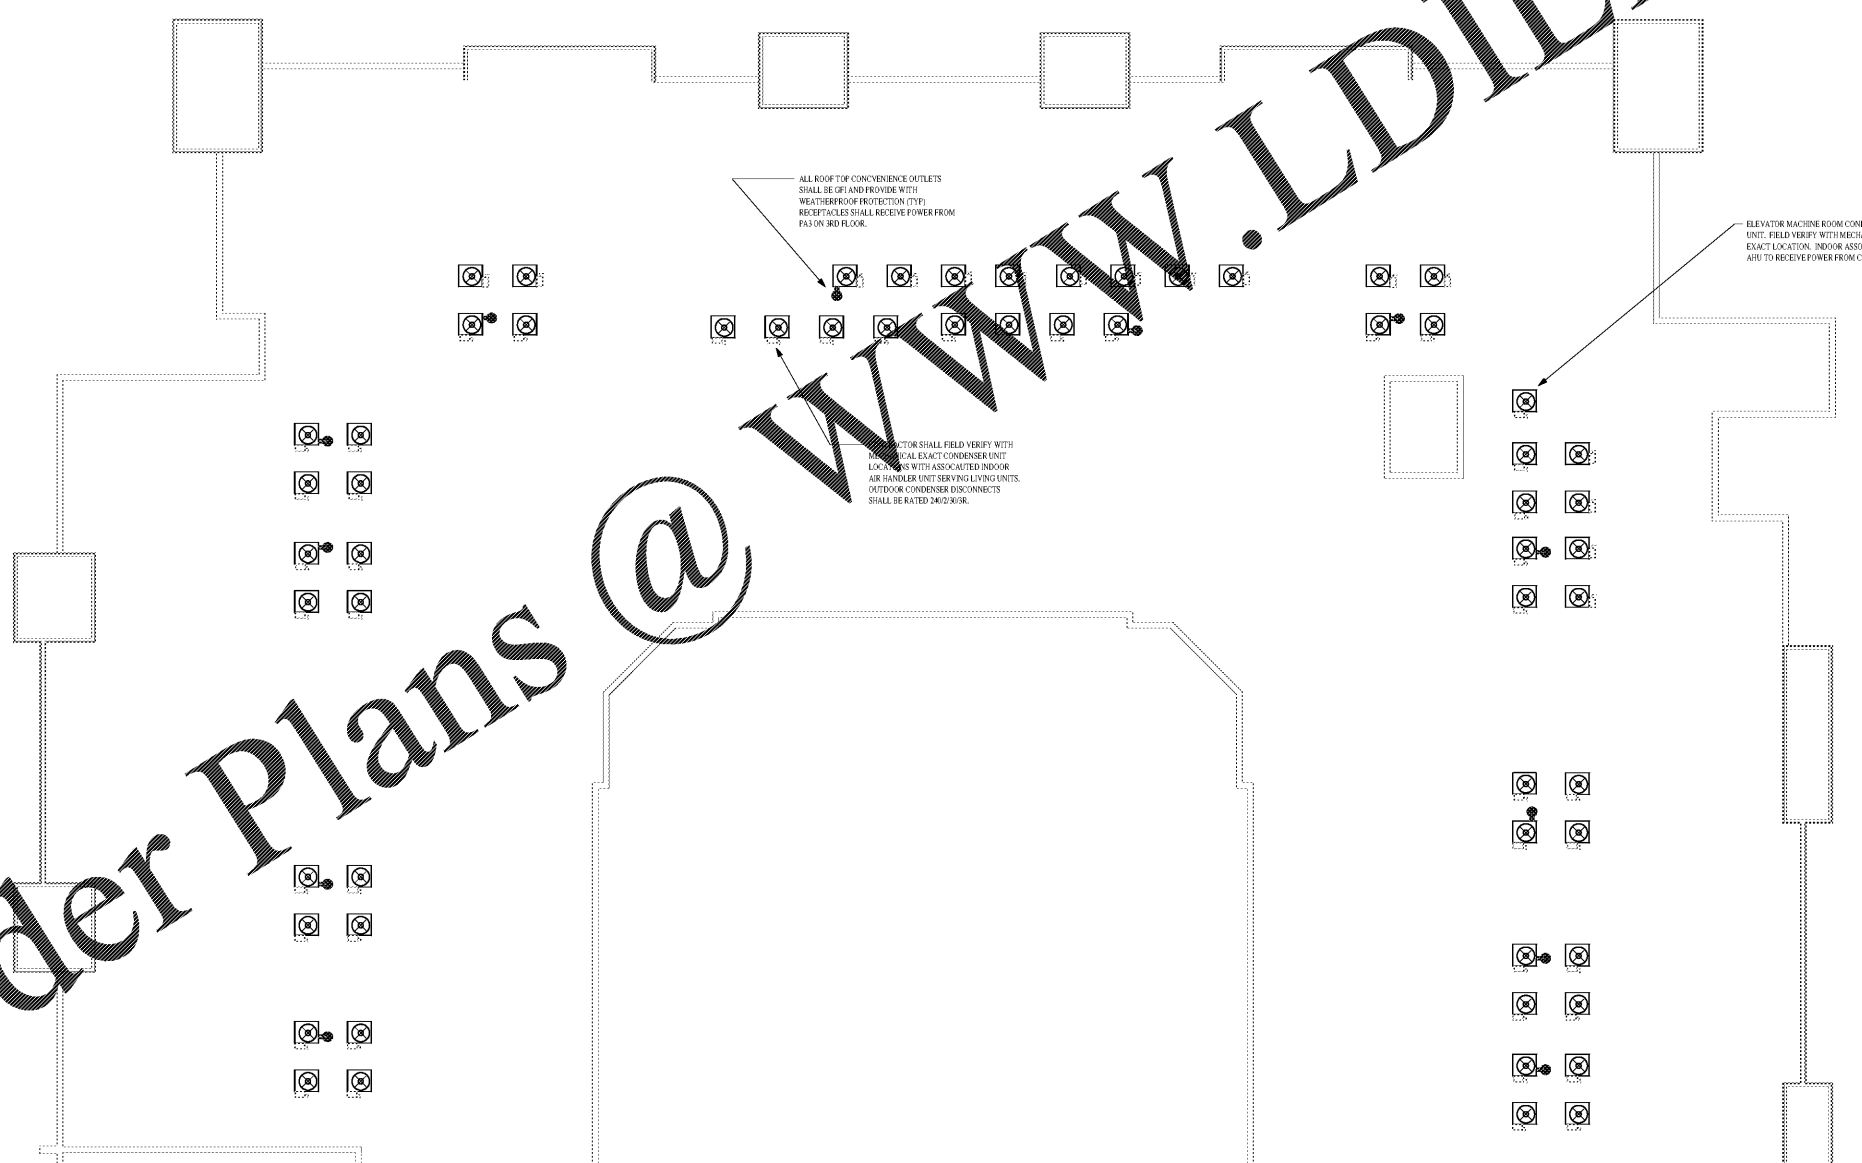

1 POWER PLAN B - ROOF
1/8" = 1'-0"

1925 Prospect Ave.
Orlando, FL 32814
P (407) 661-9100
F (407) 661-9101
www.r.p.c.com

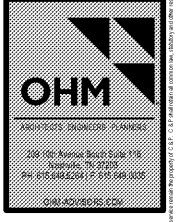

CLIENT NAME
CLIENT NAME

PROJECT NAME
ROCKLEDGE MULTI-FAMILY
220 Baron Boulevard
Rockledge, FL 32955
SHEET TITLE
ROOF PLAN B
NOV 03, 2015

Revision Schedule	
No.	Description

PROJECT NO. 0540150010	DATE 20/04/10	DRAWN N/A	CHECKED
---------------------------	------------------	--------------	-------------

E501B

GMP PRICING SET