


Order Plans @ www.edline.com

POWER PLAN A - 1ST FLOOR
1/8" = 1'-0"

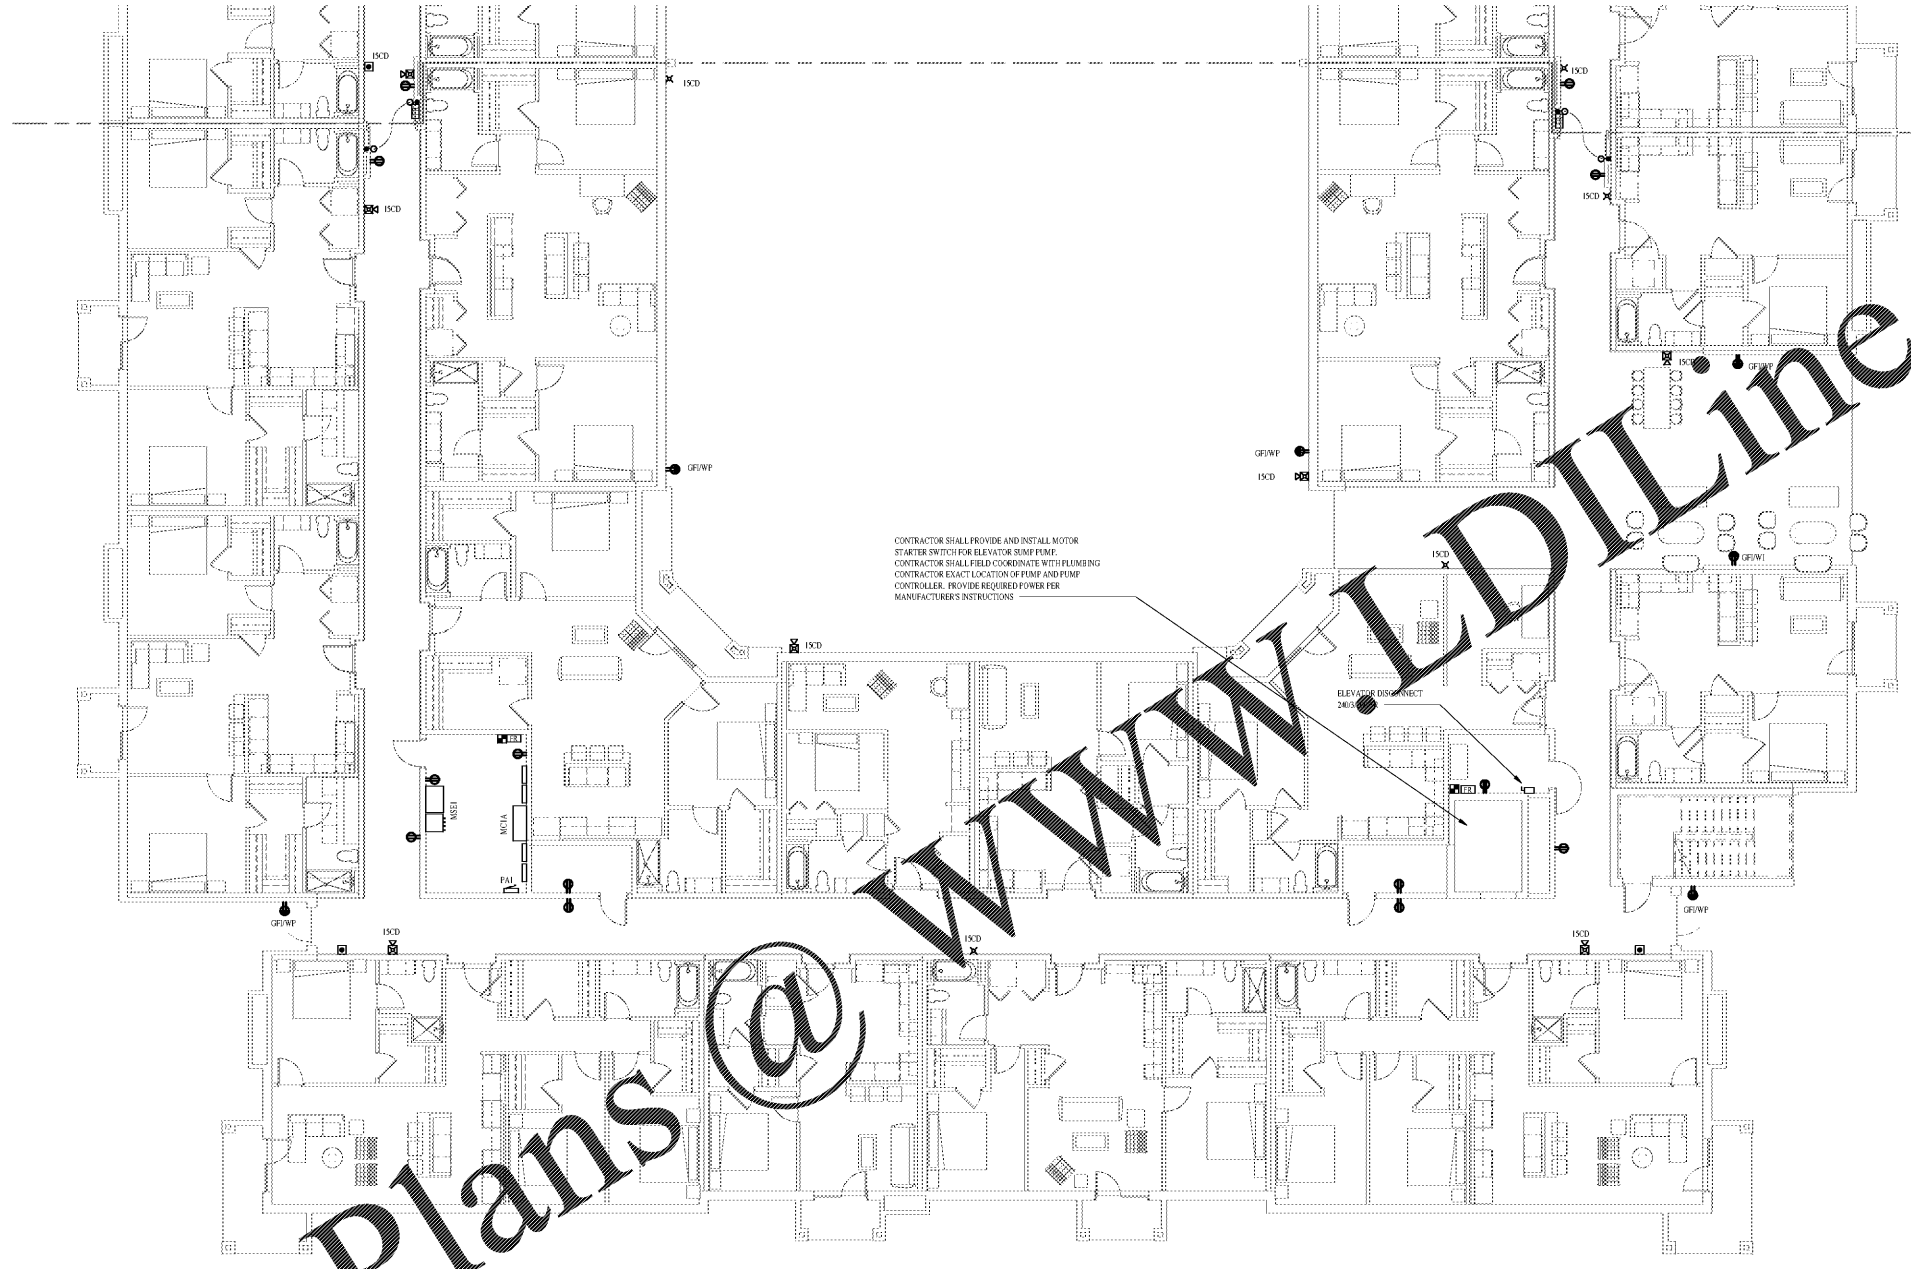

PROJECT NO. 0540150010		CLIENT NAME ROCKLEDGE MULTI-FAMILY 220 Baron Boulevard Rockledge, FL 32955							
DATE 20/04/10		PROJECT NAME ROCKLEDGE MULTI-FAMILY 220 Baron Boulevard Rockledge, FL 32955							
DRAWN BY [Name]		SHEET TITLE FIRST FLOOR POWER PLAN A							
CHECKED BY [Name]		DATE NOV 03, 2015							
REVISIONS <table border="1"> <thead> <tr> <th>No.</th> <th>Description</th> <th>Date</th> </tr> </thead> <tbody> <tr> <td> </td> <td> </td> <td> </td> </tr> </tbody> </table>		No.	Description	Date				CLIENT NAME ROCKLEDGE MULTI-FAMILY 220 Baron Boulevard Rockledge, FL 32955	
No.	Description	Date							



1925 Prospect Ave.
Orlando, FL 32814
P (407) 661-9100
F (407) 661-9101
www.c&p.com

E102A

GMP PRICING SET