


Order Plans @ WWW.DILine.com

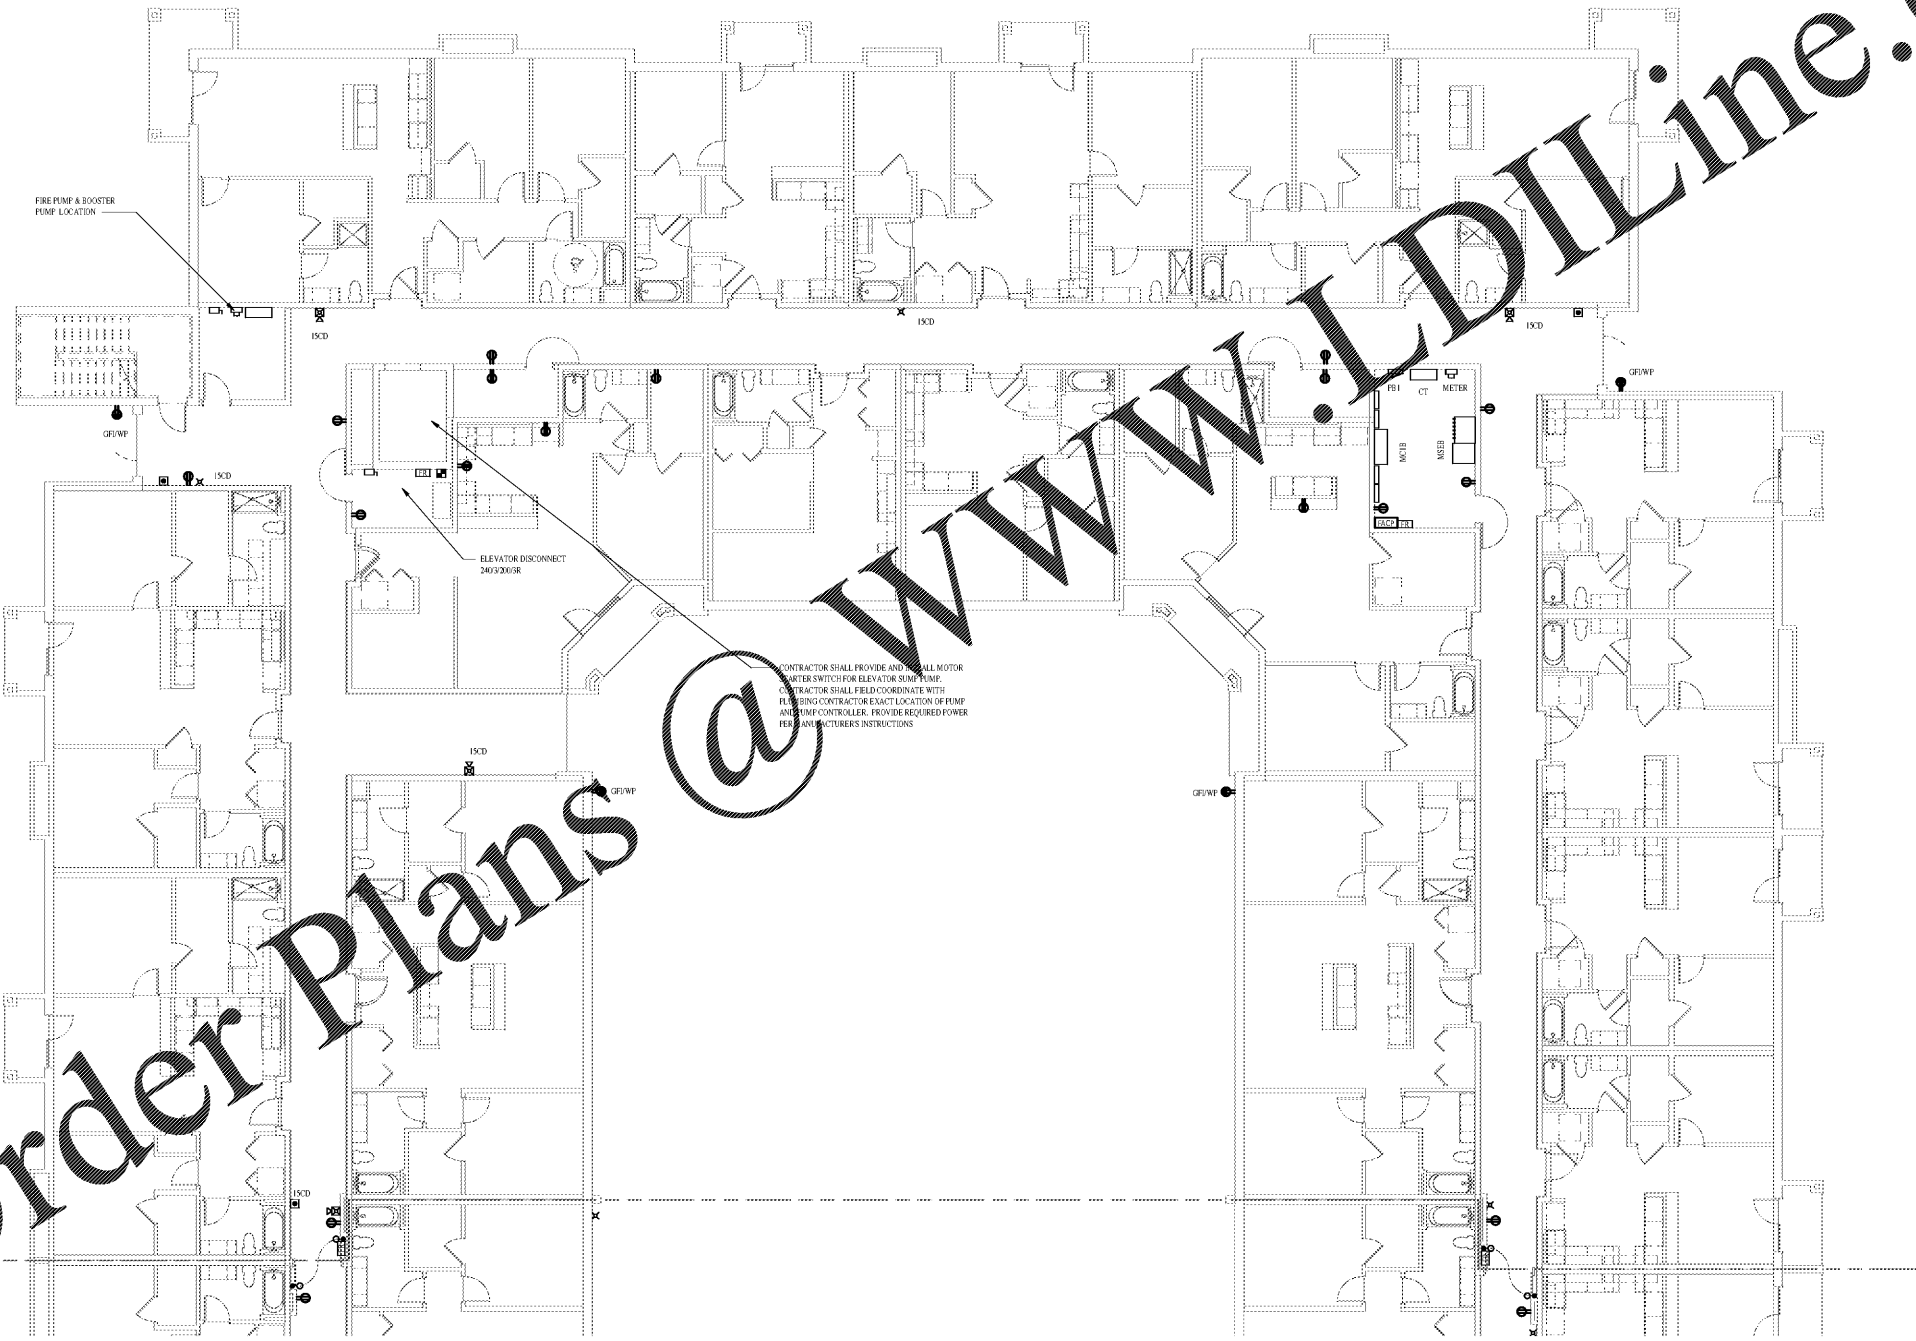

1925 Prospect Ave.
Orlando, FL 32814
P (407) 661-9100
F (407) 661-9101
www.r.p.e.com

Colucci & Peterson
Architects Engineers Planners

OHM
ORLANDO HAZARDOUS MATERIALS
2000 N. Orange Blvd. Suite 110
Orlando, FL 32809
PH: (407) 251-1100
FAX: (407) 251-1101

PROJECT NAME
ROCKLEDGE MULTI-FAMILY
220 Baron Boulevard
Rockledge, FL 32955

CLIENT NAME

SHEET TITLE
FIRST FLOOR POWER PLAN B

Revision Schedule	
No.	Description

PROJECT NO. 0540150010
DATE 20/04/10
DRAWN
CHECKED
NOV 03, 2015