


1 POWER PLAN A - 2ND FLOOR
1/8" = 1'-0"

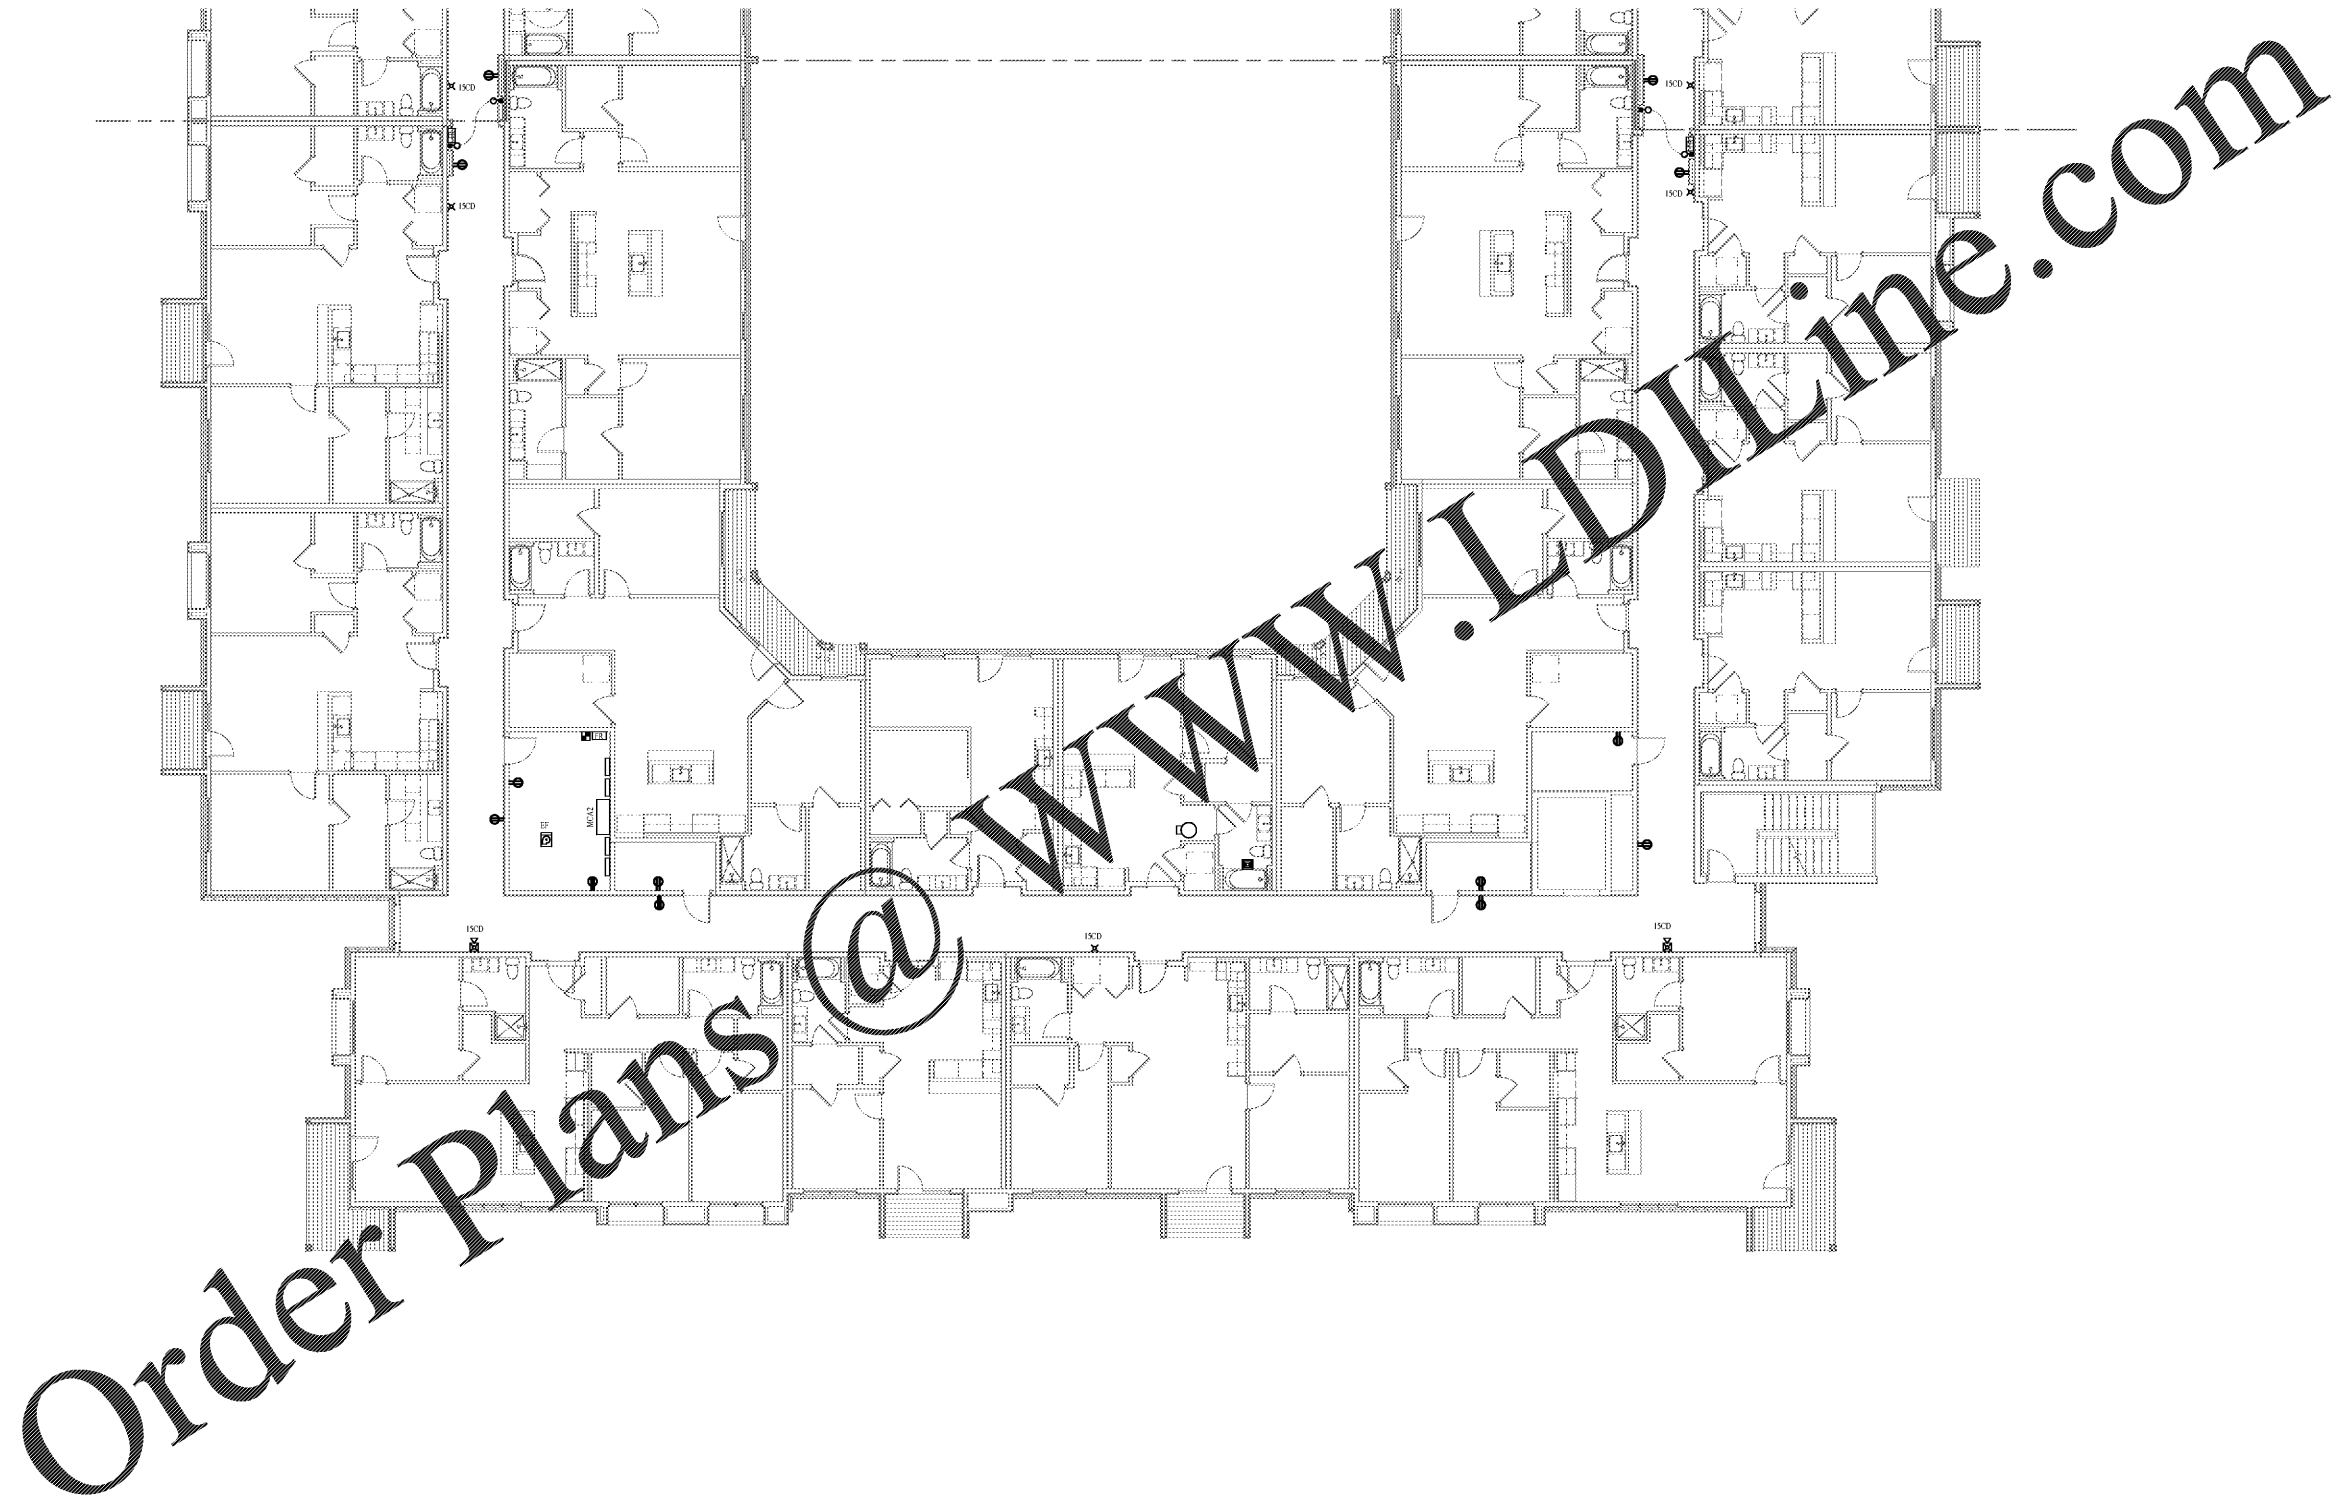

PROJECT NO. 0540150010	Revision Schedule
DATE 20/08/10	No. Description Date
DRAWN [Name]	
CHECKED [Name]	

PROJECT NAME ROCKLEDGE MULTI-FAMILY 220 Baron Boulevard Rockledge, FL 32955	CLIENT NAME
SHEET TITLE SECOND FLOOR POWER PLAN A	

PROJECT NO. 0540150010	DATE 20/08/10
DRAWN [Name]	CHECKED [Name]

PROJECT NO. 0540150010	DATE 20/08/10
DRAWN [Name]	CHECKED [Name]

OHM
Architectural Electrical Engineering
20000 Avenue 2000
Rockledge, FL 32955
Tel: 321.428.8838
Fax: 321.428.8839

Chalaci & Peterson
Architects Engineers Planners
1925 Prospect Ave.
Orlando, FL 32814
P (407) 661-9100
F (407) 661-9101
www.c&p.com

E202A

GMP PRICING SET