


Order Plans @ www.WLDLine.com

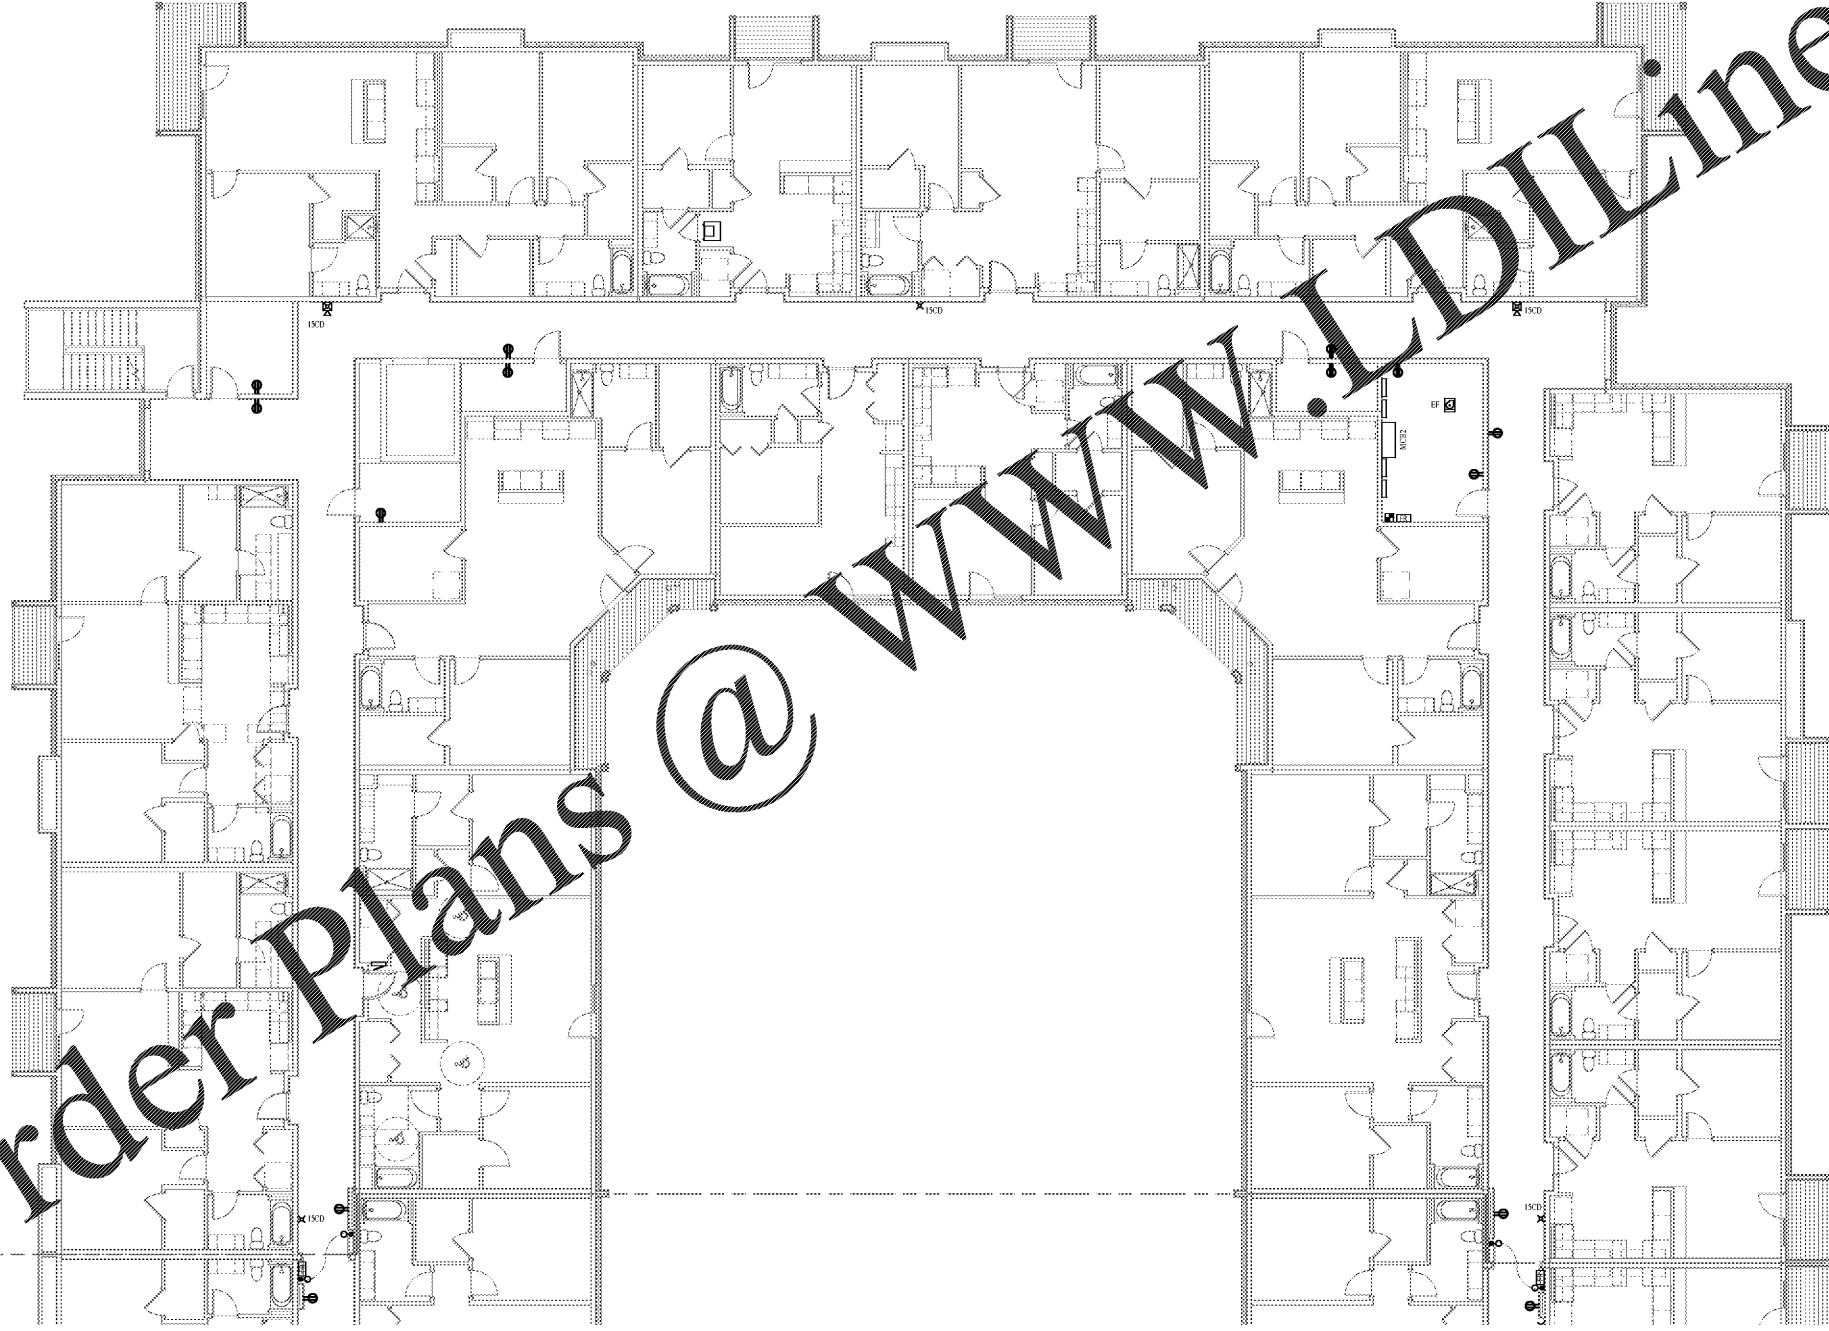

PROJECT NO. 0540150010	Revision Schedule
DATE 20/04/10	No. Description Date
DRAWN [Signature]	
CHECKED [Signature]	


PROJECT NAME ROCKLEDGE MULTI-FAMILY 220 Baron Boulevard Rockledge, FL 32955	CLIENT NAME
SHEET TITLE SECOND FLOOR POWER PLAN B	

NOV 03, 2015

PROJECT NO. 0540150010

CLIENT NAME

CLIENT NAME

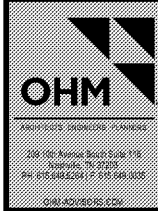

Colucci & Peterson
Architects Engineers Planners

1925 Prospect Ave.
Orlando, FL 32814
P (407) 661-9100
F (407) 661-9101
www.c-p.com