


① POWER PLAN FOURTH FLOOR
1/8" = 1'-0"

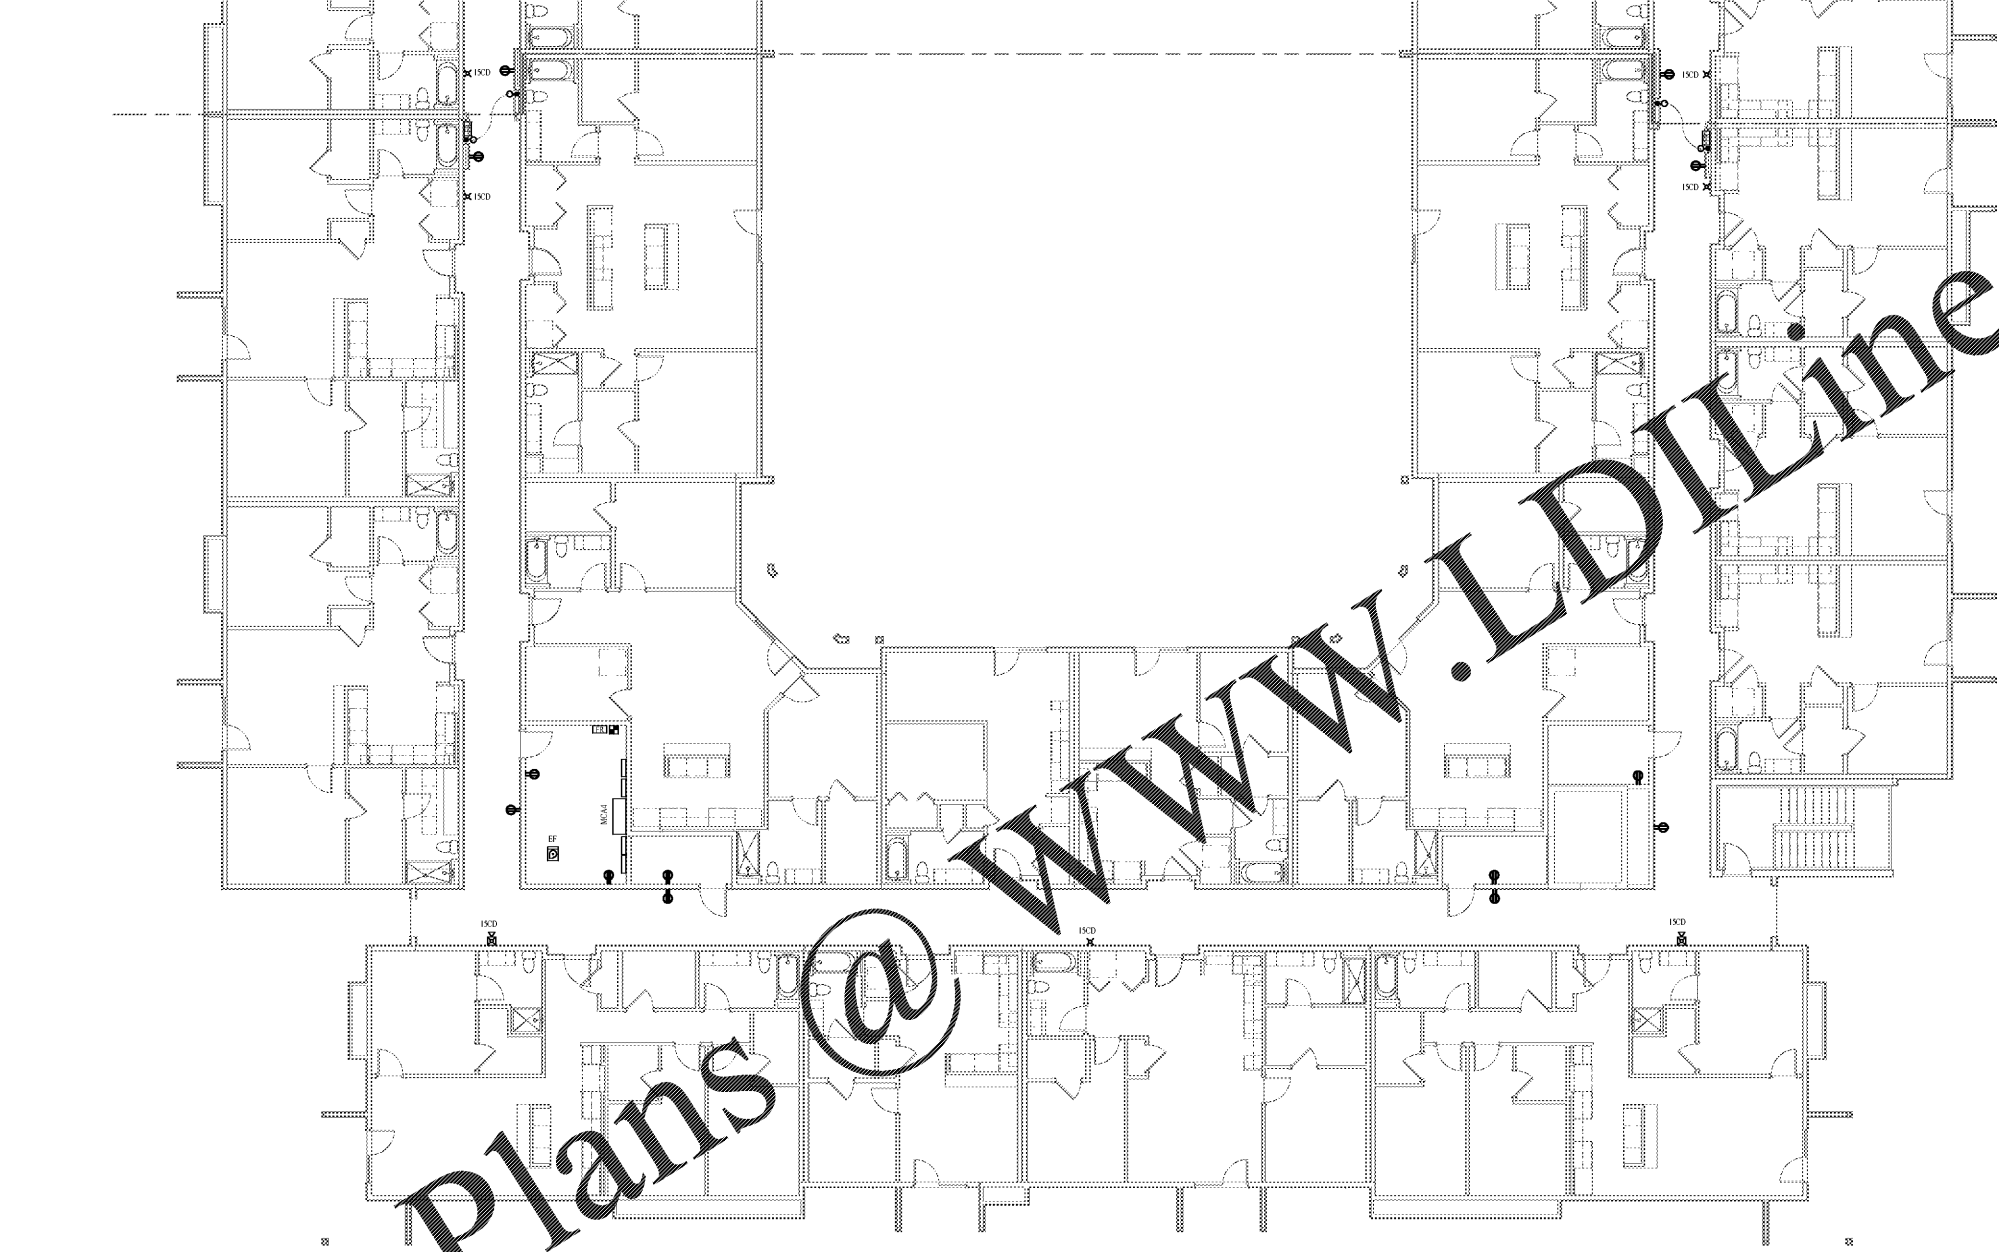

Order Plans @

| PROJECT NO. | DATE | BY | CHECKED |
|-------------|----------|----|---------|
| 0540150010 | 20/08/10 | | |

| Revision Schedule | |
|-------------------|-------------|
| No. | Description |
| | |

NOV 03, 2015

PROJECT NAME
ROCKLEDGE MULTI-FAMILY
220 Baron Boulevard
Rockledge, FL 32955

SHEET TITLE
FOURTH FLOOR POWER PLAN A

CLIENT NAME



1925 Prospect Ave.
Orlando, FL 32814
P (407) 661-9100
F (407) 661-9101
www.c.p.a.com

GMP PRICING SET

E402A