


Order Plans @ WWW.LDILine.com

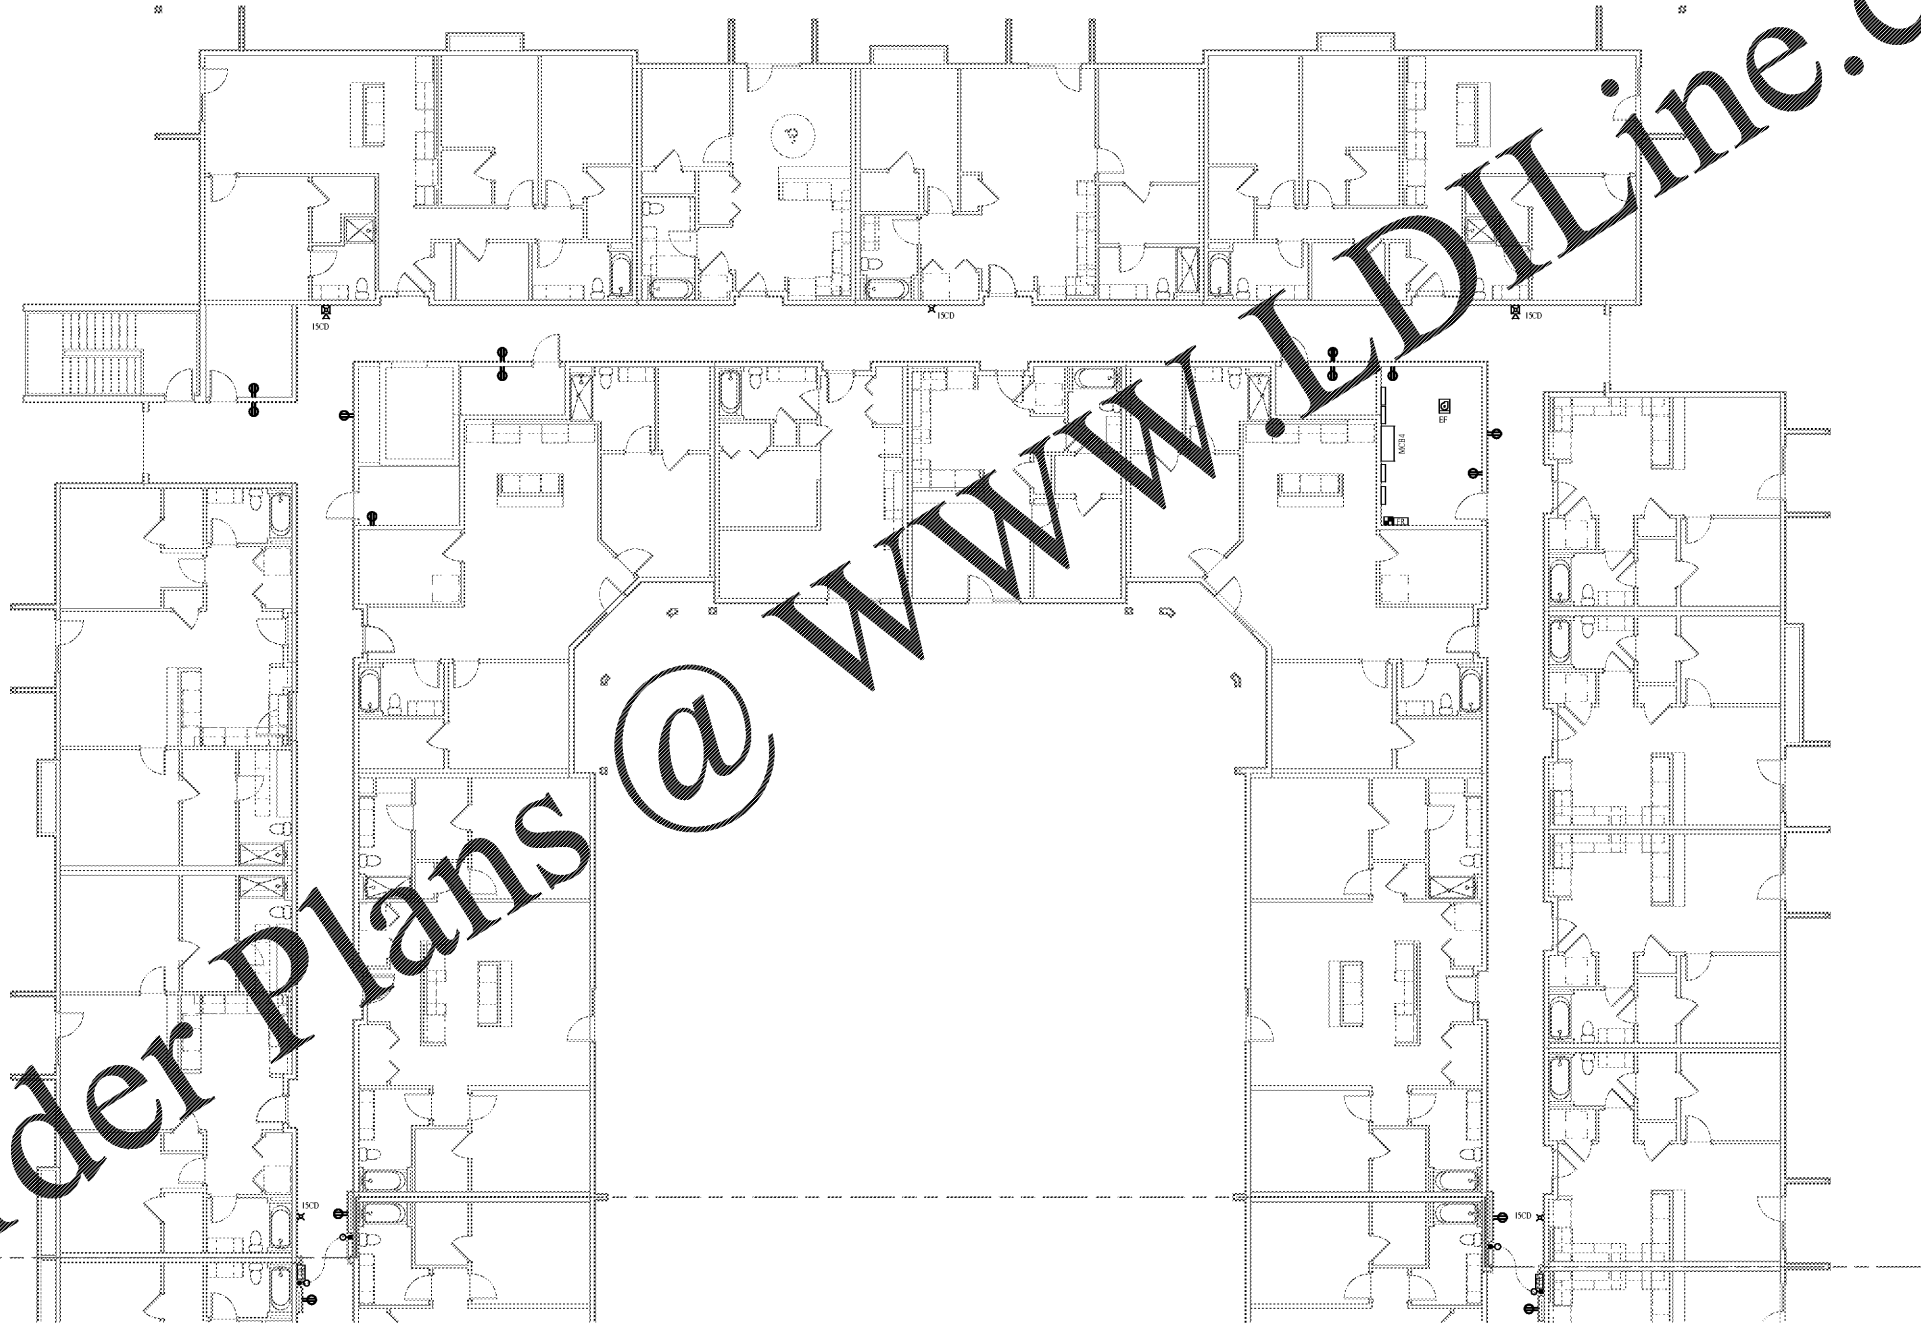

1 POWER PLAN B - 4TH FLOOR  
1/8" = 1'-0"

Revision Schedule	
No.	Description

PROJECT NO. 0540150010	DATE 20/04/10	DRAWN [Signature]	CHECKED [Signature]
---------------------------	------------------	----------------------	------------------------

NOV 03, 2015

PROJECT NAME  
**ROCKLEDGE MULTI-FAMILY**  
220 Baron Boulevard  
Rockledge, FL 32955

CLIENT NAME

SHEET TITLE  
**FOURTH FLOOR POWER PLAN B**



1925 Prospect Ave.  
Orlando, FL 32814  
P (407) 661-9100  
F (407) 661-9101  
www.o.p.a.com

**Colucci & Peterson**  
Architects Engineers Planners

GMP PRICING SET

E402B