


1 POWER PLAN B - ROOF
1/8" = 1'-0"

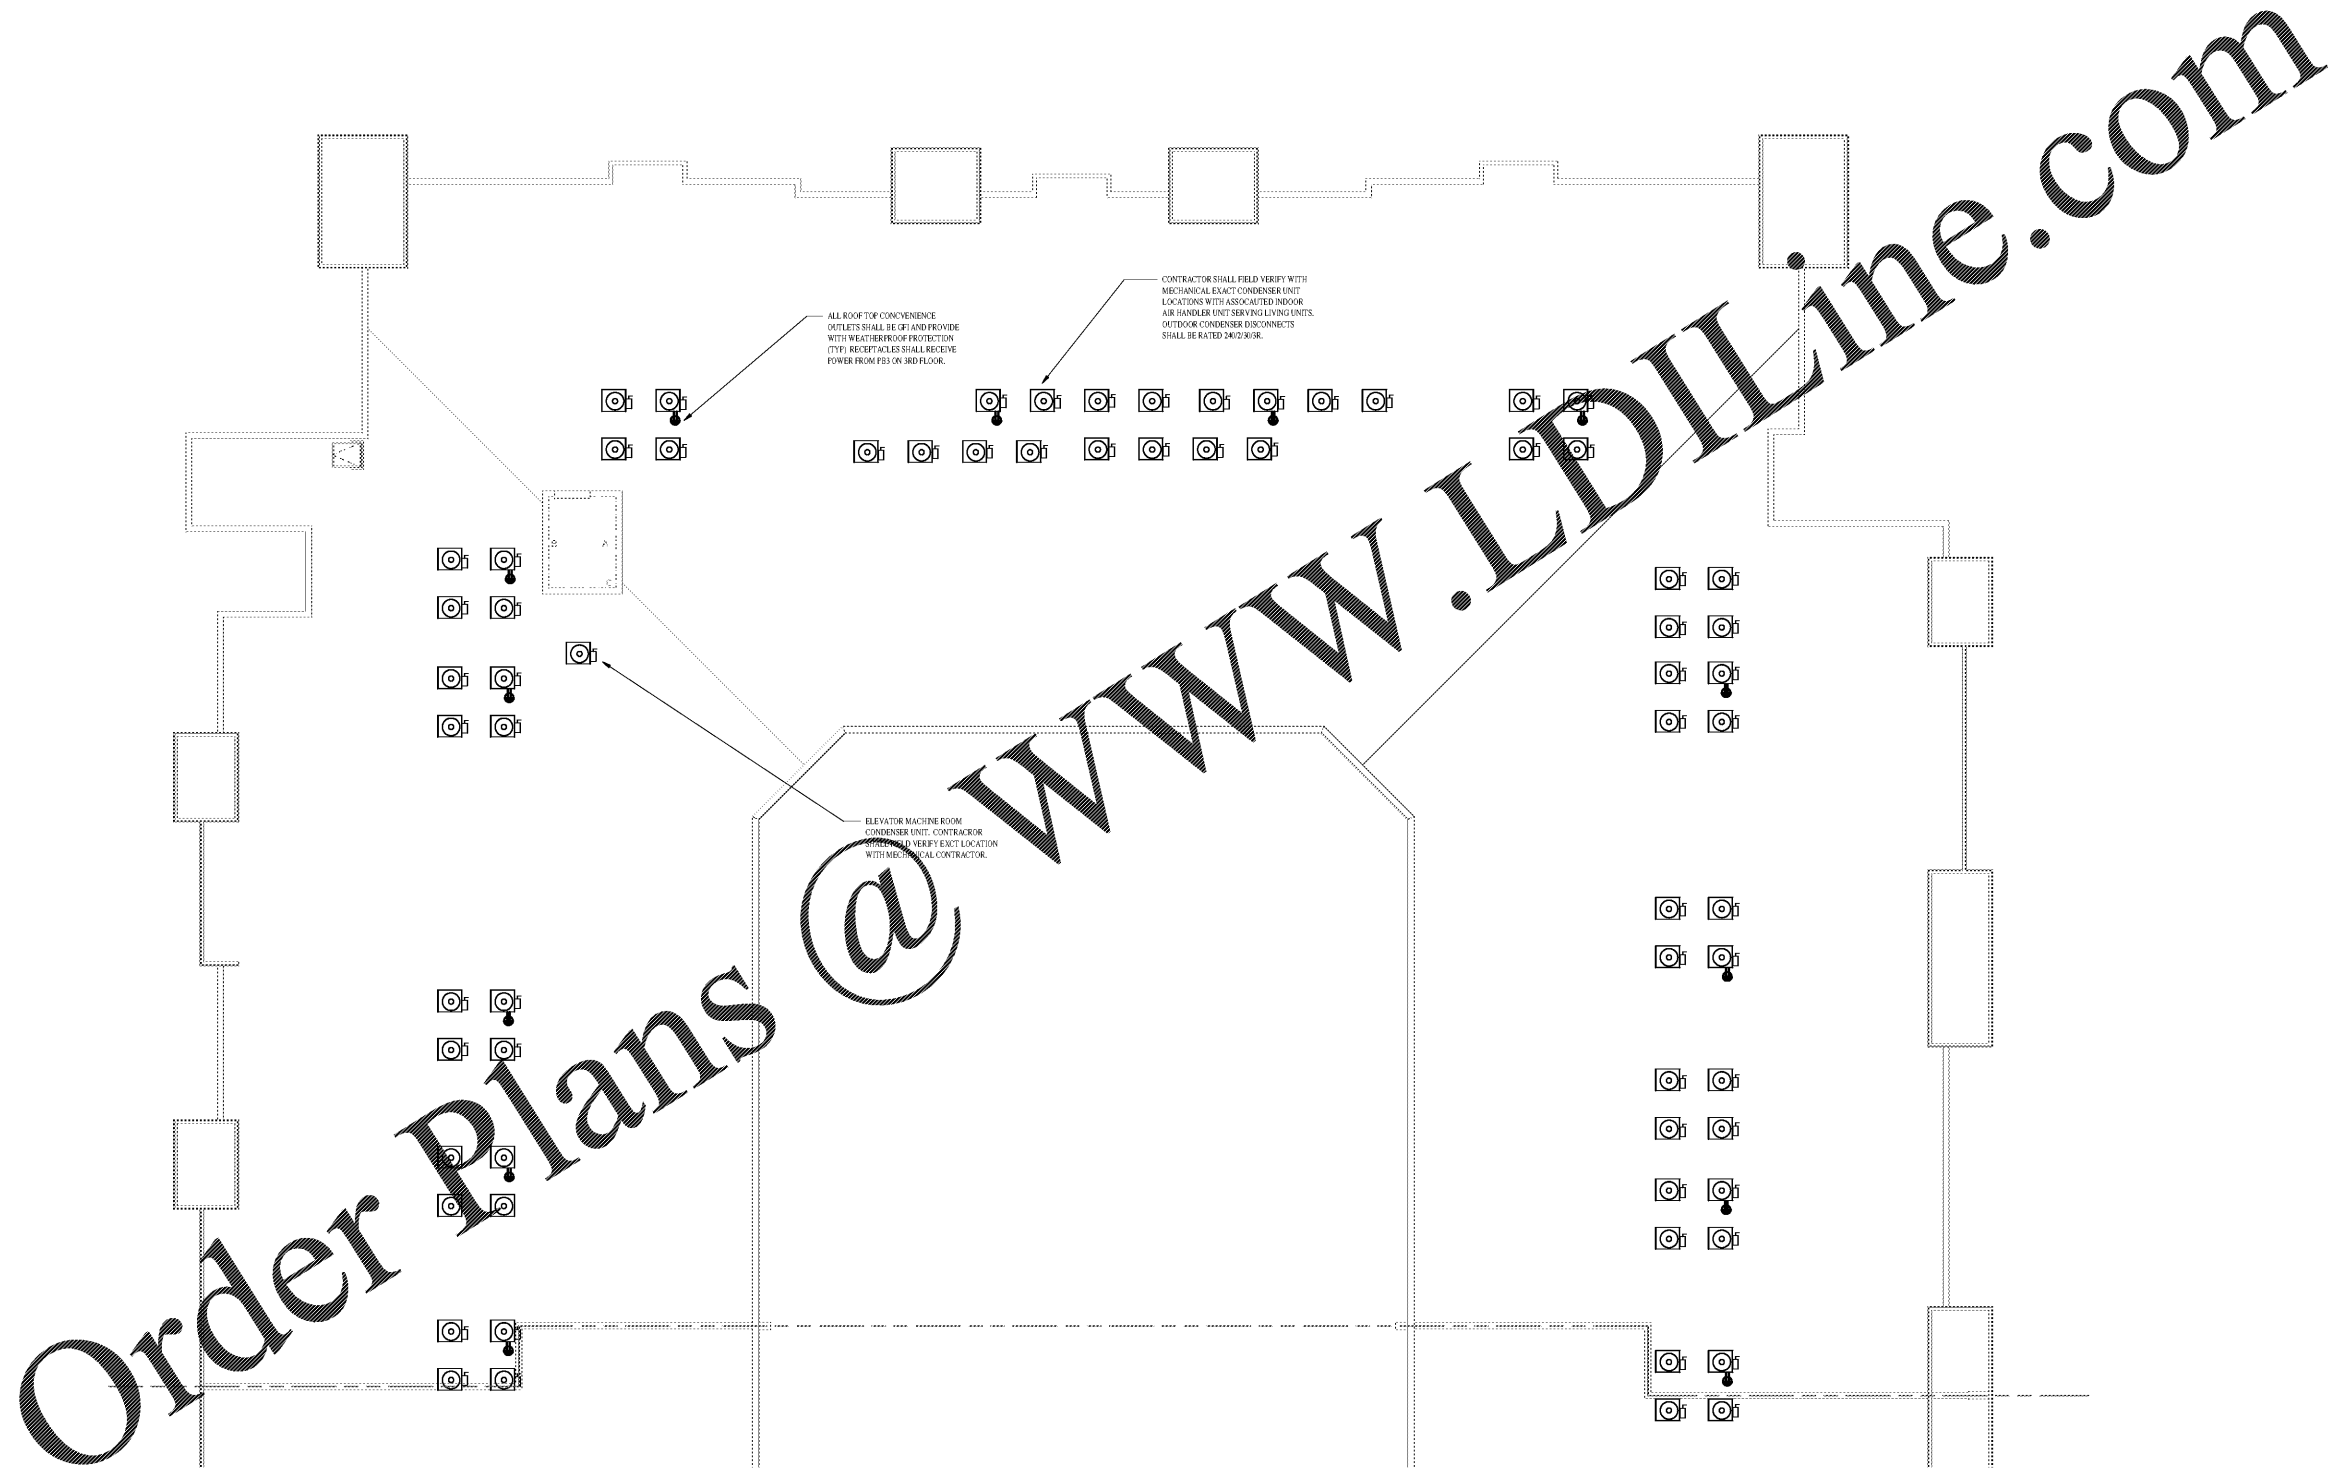

Revision Schedule	
No.	Description

PROJECT NO. 0540-15/010	DATE 20/04/10	DRWING AUFAR	CHECKED
----------------------------	------------------	-----------------	-------------

PROJECT NAME ROCKLEDGE MULTI-FAMILY 220 Baron Boulevard Rockledge, FL 32955	CLIENT NAME
--	-----------------

SHEET TITLE ROOF PLAN B

NOV 03, 2015

--



Colucci & Peterson
Architects Engineers Planners

1925 Prospect Ave.
Orlando, FL 32814
P (407) 661-9100
F (407) 661-9101
www.c&p.com

E501B

GMP PRICING SET