


Order Plans @

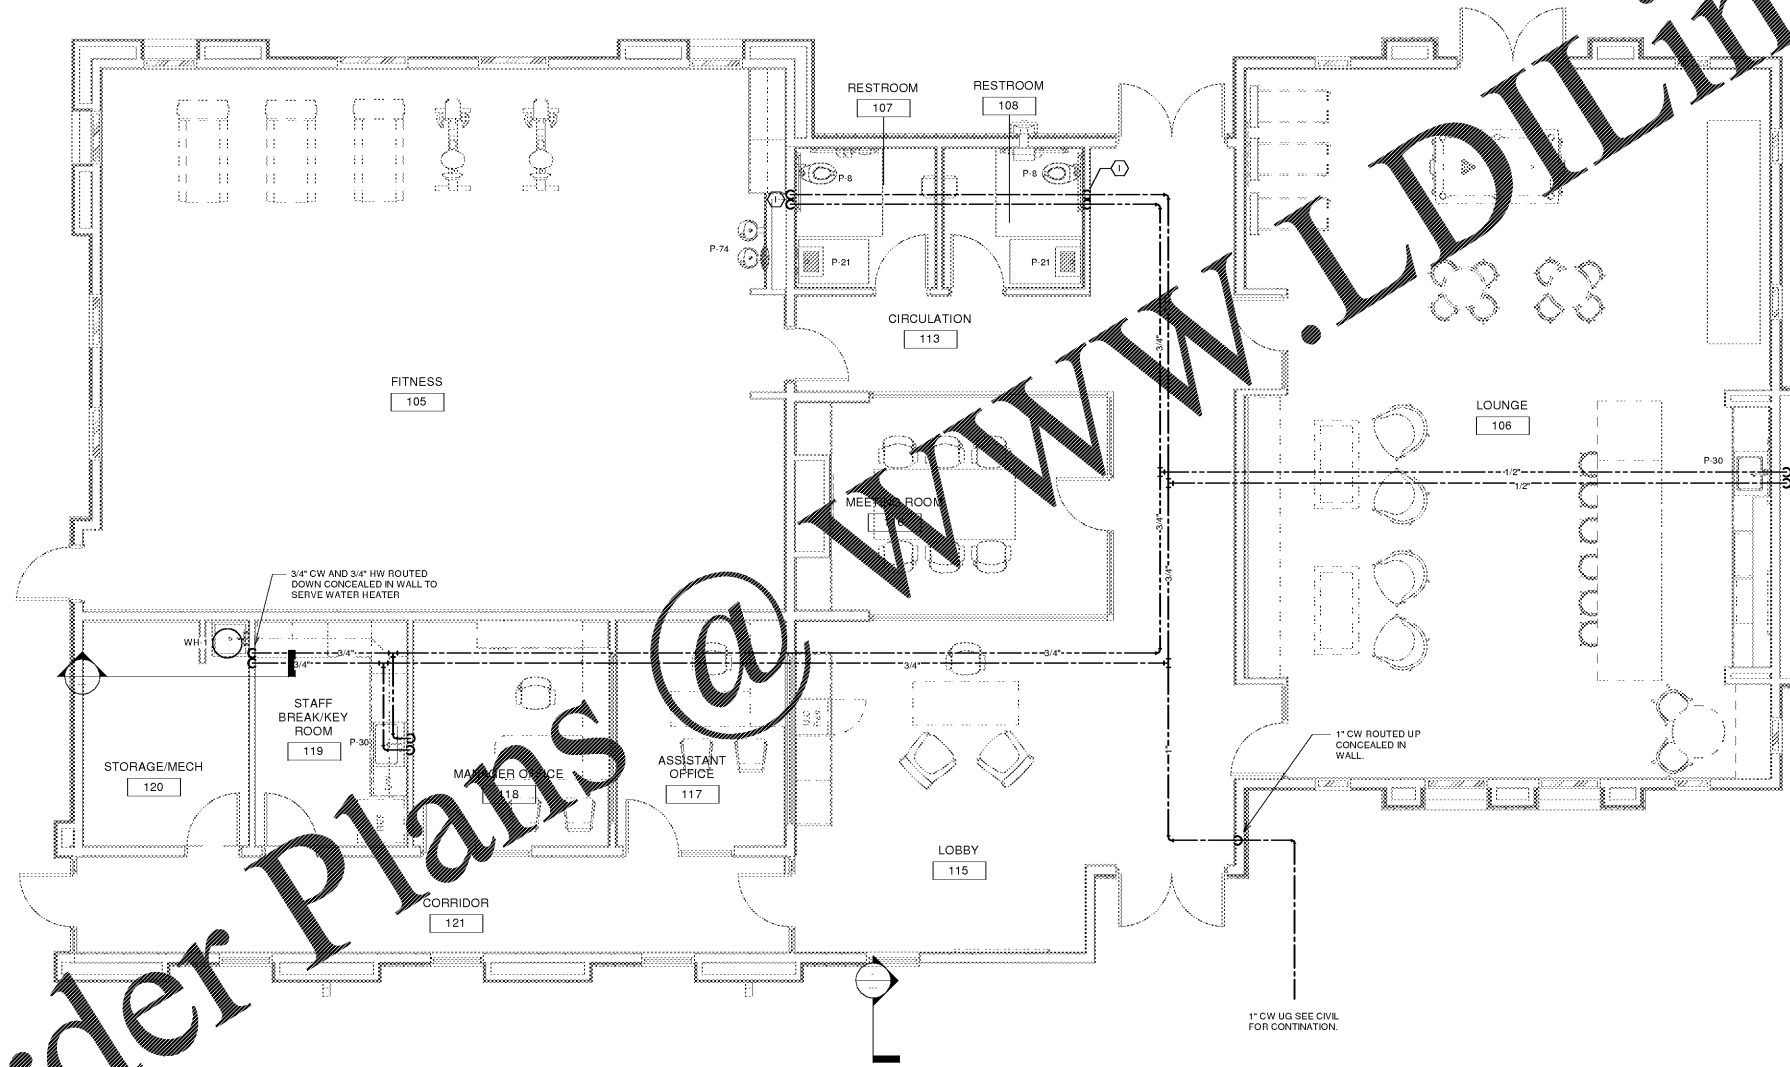

KEY NOTES:
1. 3/4" CW ROUTED DOWN CONCEALED IN WALL TO SERVE PLUMBING FIXTURES PER RUN ON SHEET P101.

1" CW UG SEE CIVIL FOR CONTINuation.

WWW.LDILine.com

1925 Prospect Ave.
Orlando, FL 32814
P (407) 661-9100
F (407) 661-9101
www.lp.com

Chalaci & Peterson
Architects Engineers Planners

OHM
ARCHITECTS ENGINEERS PLANNERS

200 W. Avenue 2000, Suite 200
Tampa, FL 33606
PH: 813.288.1234
FAX: 813.288.1235
www.ohm.com

PROJECT NAME: **ROCKLEDGE FLATS - BUILDING C**
220 Baron Boulevard
Rockledge, FL 32955

CLIENT NAME: **HUTTON DEVELOPMENT**

SHEET TITLE: **WATER SUPPLY FLOOR PLAN**

DATE: 20/01/16
DRAWN BY: [Name]
CHECKED BY: [Name]

REVISION SCHEDULE

| No. | Description | Date |
|-----|-------------|------|
| | | |

NOV 15, 2015

GMP PRICING SET

P101