


1 LIGHTING FLOOR PLAN  
1/4" = 1'-0"

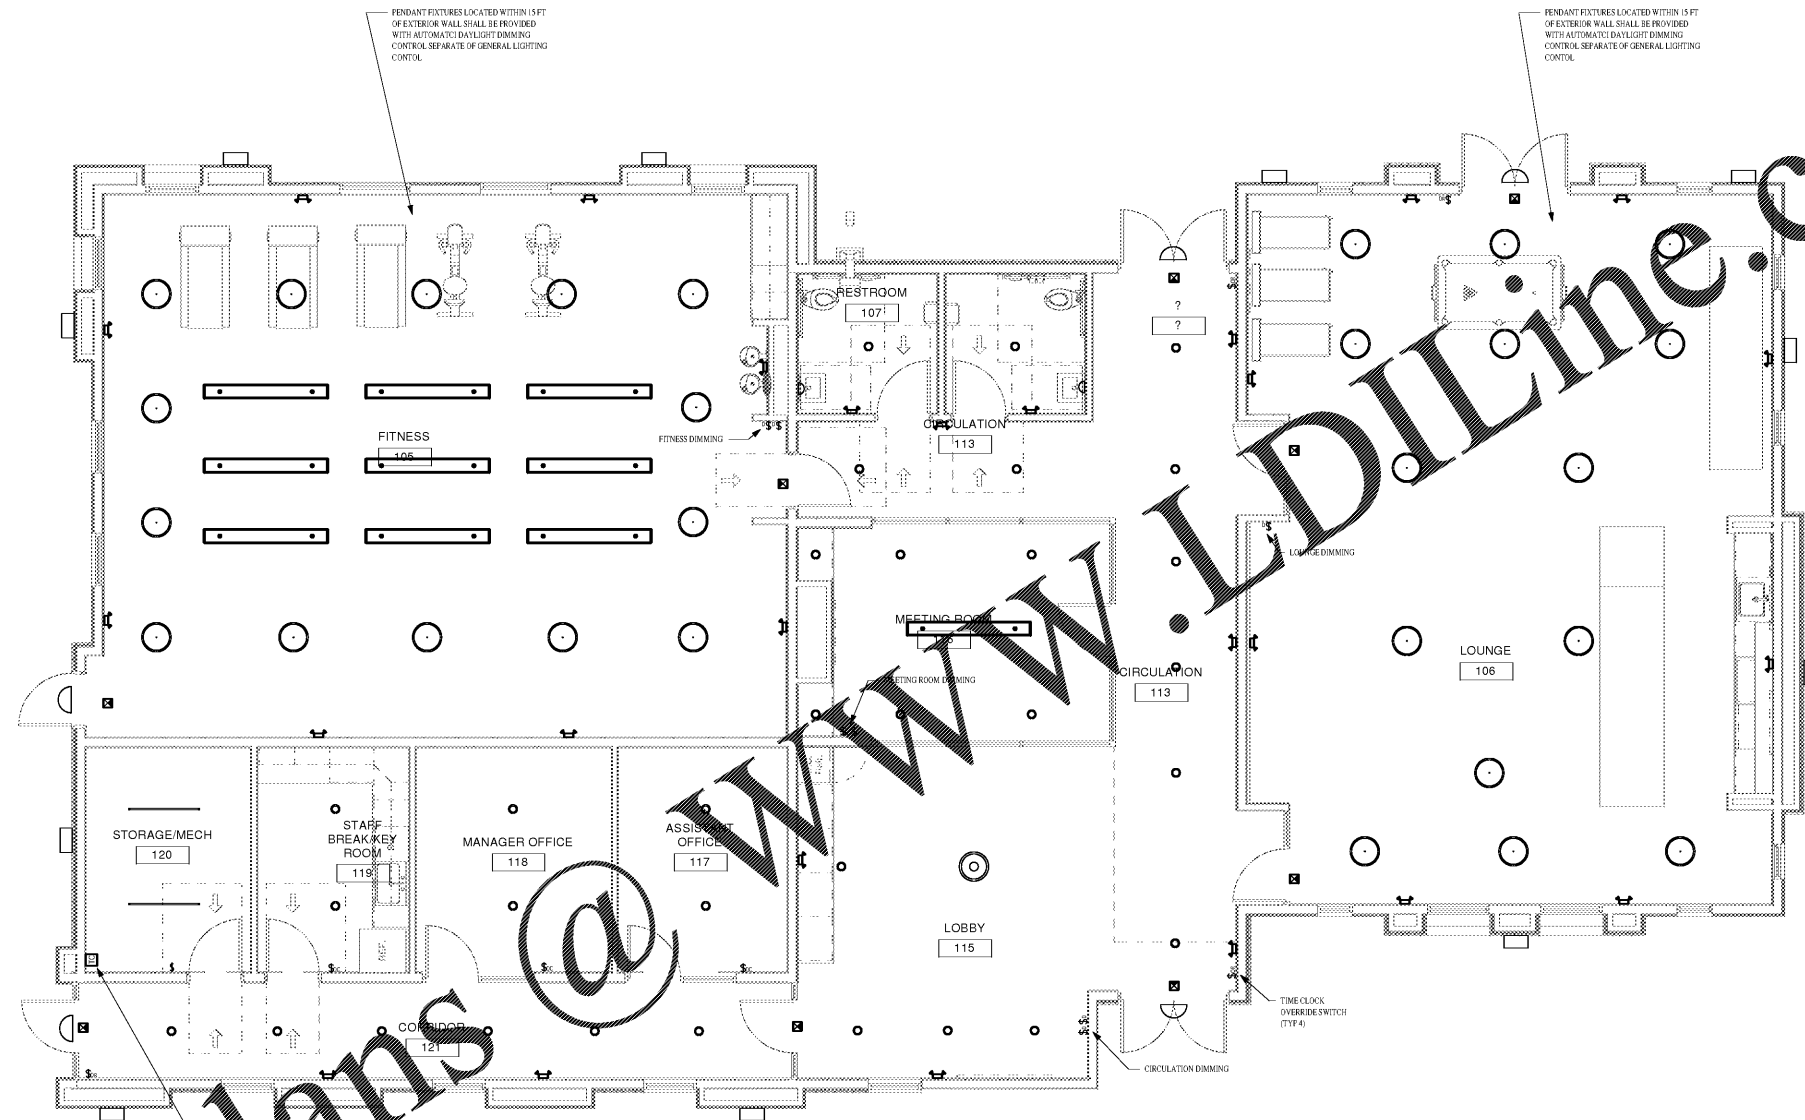

Order Plans @ [www.LDILine.com](http://www.LDILine.com)

1925 Prospect Ave.  
Orlando, FL 32814  
P (407) 661-9100  
F (407) 661-9101  
[www.r.p.c.com](http://www.r.p.c.com)



CLIENT NAME  
**HUTTON DEVELOPMENT**

PROJECT NAME  
**ROCKLEDGE FLATS - BUILDING C**  
220 Baron Boulevard  
Rockledge, FL 32955

SHEET TITLE  
**LIGHTING PLAN**

Revision Schedule		
No.	Description	Date

PROJECT NO.  
0540150010

DATE  
20/04/2019

DESIGNER  
[Signature]

CHECKED  
[Signature]

NOV 03, 2015

GMP PRICING SET

E101