


Order Plans @ www.LDILine.com

1 MECHANICAL FLOOR PLAN
1/4" = 1'-0"

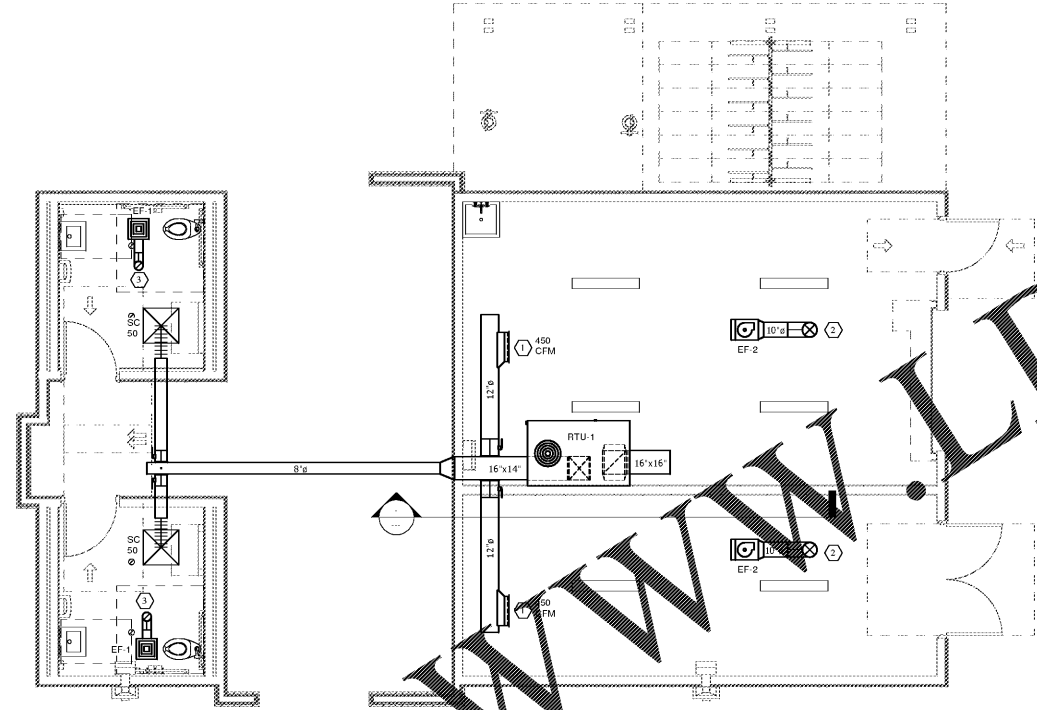

- KEY NOTE:
1. 20"X20" PRICE MODEL GRILLE WITH DIRECT MOUNTED BALANCE COIL PER FLOOR PLAN.
 2. 20"X20" PRICE MODEL GRILLE WITH DIRECT MOUNTED BALANCE COIL PER FLOOR PLAN.
 3. 20"X20" PRICE MODEL GRILLE WITH DIRECT MOUNTED BALANCE COIL PER FLOOR PLAN.



Orlando Heating & Mechanical
Architects Engineers Planners

1925 Prospect Ave.
Orlando, FL 32814
P (407) 661-9100
F (407) 661-9101
www.o.h.m.com

PROJECT NO. 0540150010	DATE 20/04/16	DRWING RUP	CHECKED C								
<table border="1"> <thead> <tr> <th colspan="2">Revision Schedule</th> </tr> <tr> <th>No.</th> <th>Description</th> <th>Date</th> </tr> </thead> <tbody> <tr> <td> </td> <td> </td> <td> </td> </tr> </tbody> </table>				Revision Schedule		No.	Description	Date			
Revision Schedule											
No.	Description	Date									
PROJECT NAME ROCKLEDGE MULTI-FAMILY 220 Baron Boulevard Rockledge, FL 32955		CLIENT NAME									
SHEET TITLE MECHANICAL FLOOR PLAN		NOV 15, 2015									

M101

GMP PRICING SET