


① WATER FLOOR PLAN
1/4" = 1'-0"

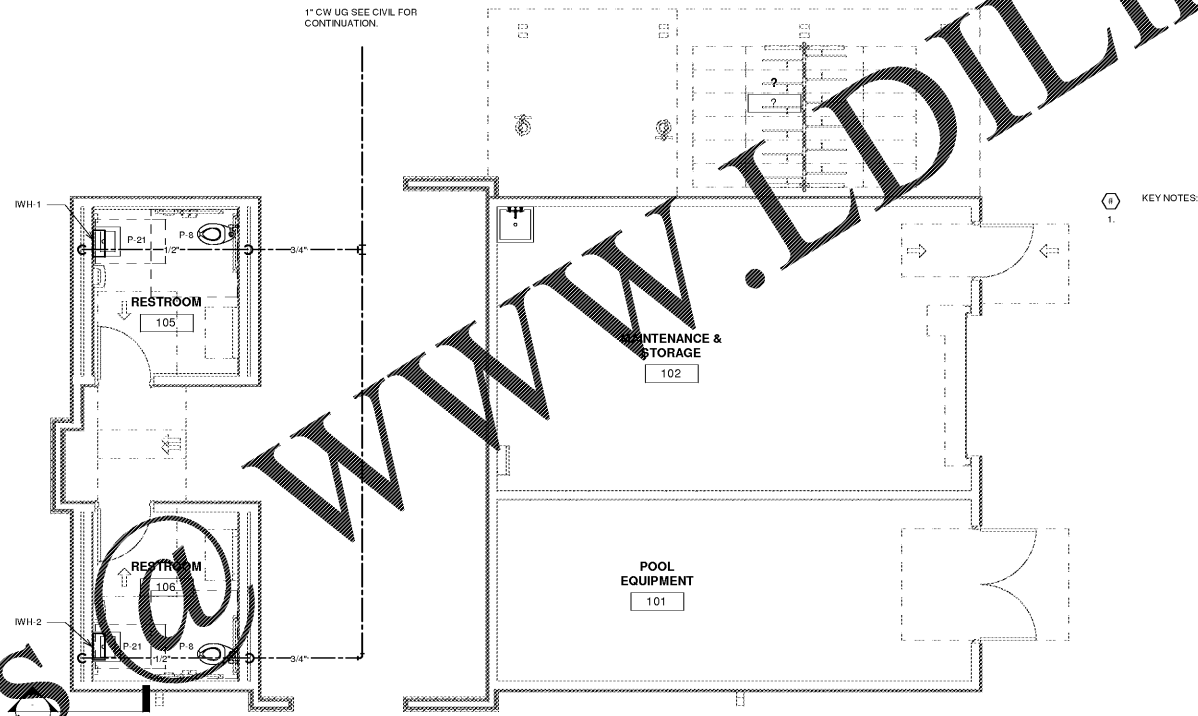

Order Plans @ www.LDILine.com

Revision Schedule	
No.	Description

PROJECT NO. 0540150010	DATE 20/01/16	DRAWN [Signature]	CHECKED [Signature]
---------------------------	------------------	----------------------	------------------------


PROJECT NAME ROCKLEDGE MULTI-FAMILY 220 Baron Boulevard Rockledge, FL 32955
--

CLIENT NAME ROCKLEDGE MULTI-FAMILY 220 Baron Boulevard Rockledge, FL 32955

CLIENT NAME PLUMBING FLOOR PLAN WATER PIPING

P101

GMP PRICING SET

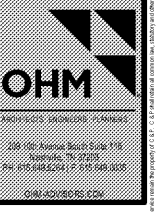

OHM
ARCHITECTS ENGINEERS PLANNERS
200 NE Avenue South, Suite 200
Rockledge, FL 32955
Tel: 321.422.8500 | Fax: 321.422.8501
www.ohm.com

1925 Prospect Ave.
Orlando, FL 32814
P (407) 661-9100
F (407) 661-9101
www.r.p.e.com

Caracci & Peterson
Architects Engineers Planners