

C:\2019\1915 - PRH.MCB\DWG\1915\F10_002.dwg
11/17/2019
3:45:16 PM



80' / 1" = 80'



PRH
MEDICAL OFFICE BUILDING
NAPLES, FLORIDA

THIS DOCUMENT CONTAINS PROPRIETARY INFORMATION TO WHICH THE HOLDER OF THIS DOCUMENT AND/OR ITS CONTENTS MAY NOT BE REPRODUCED, COPIED, OR OTHERWISE TRANSMITTED IN ANY FORM OR BY ANY MEANS, WITHOUT THE PRIOR WRITTEN PERMISSION OF DSC ARCHITECTS. COPYRIGHT 2019. ALL RIGHTS RESERVED.

7121 CROSSROADS BVD
888-HYWOOD, IN 37027
TEL: (615) 776-0310
MAE: dscinfo@dscarch.com
WWW: www.dscarch.com

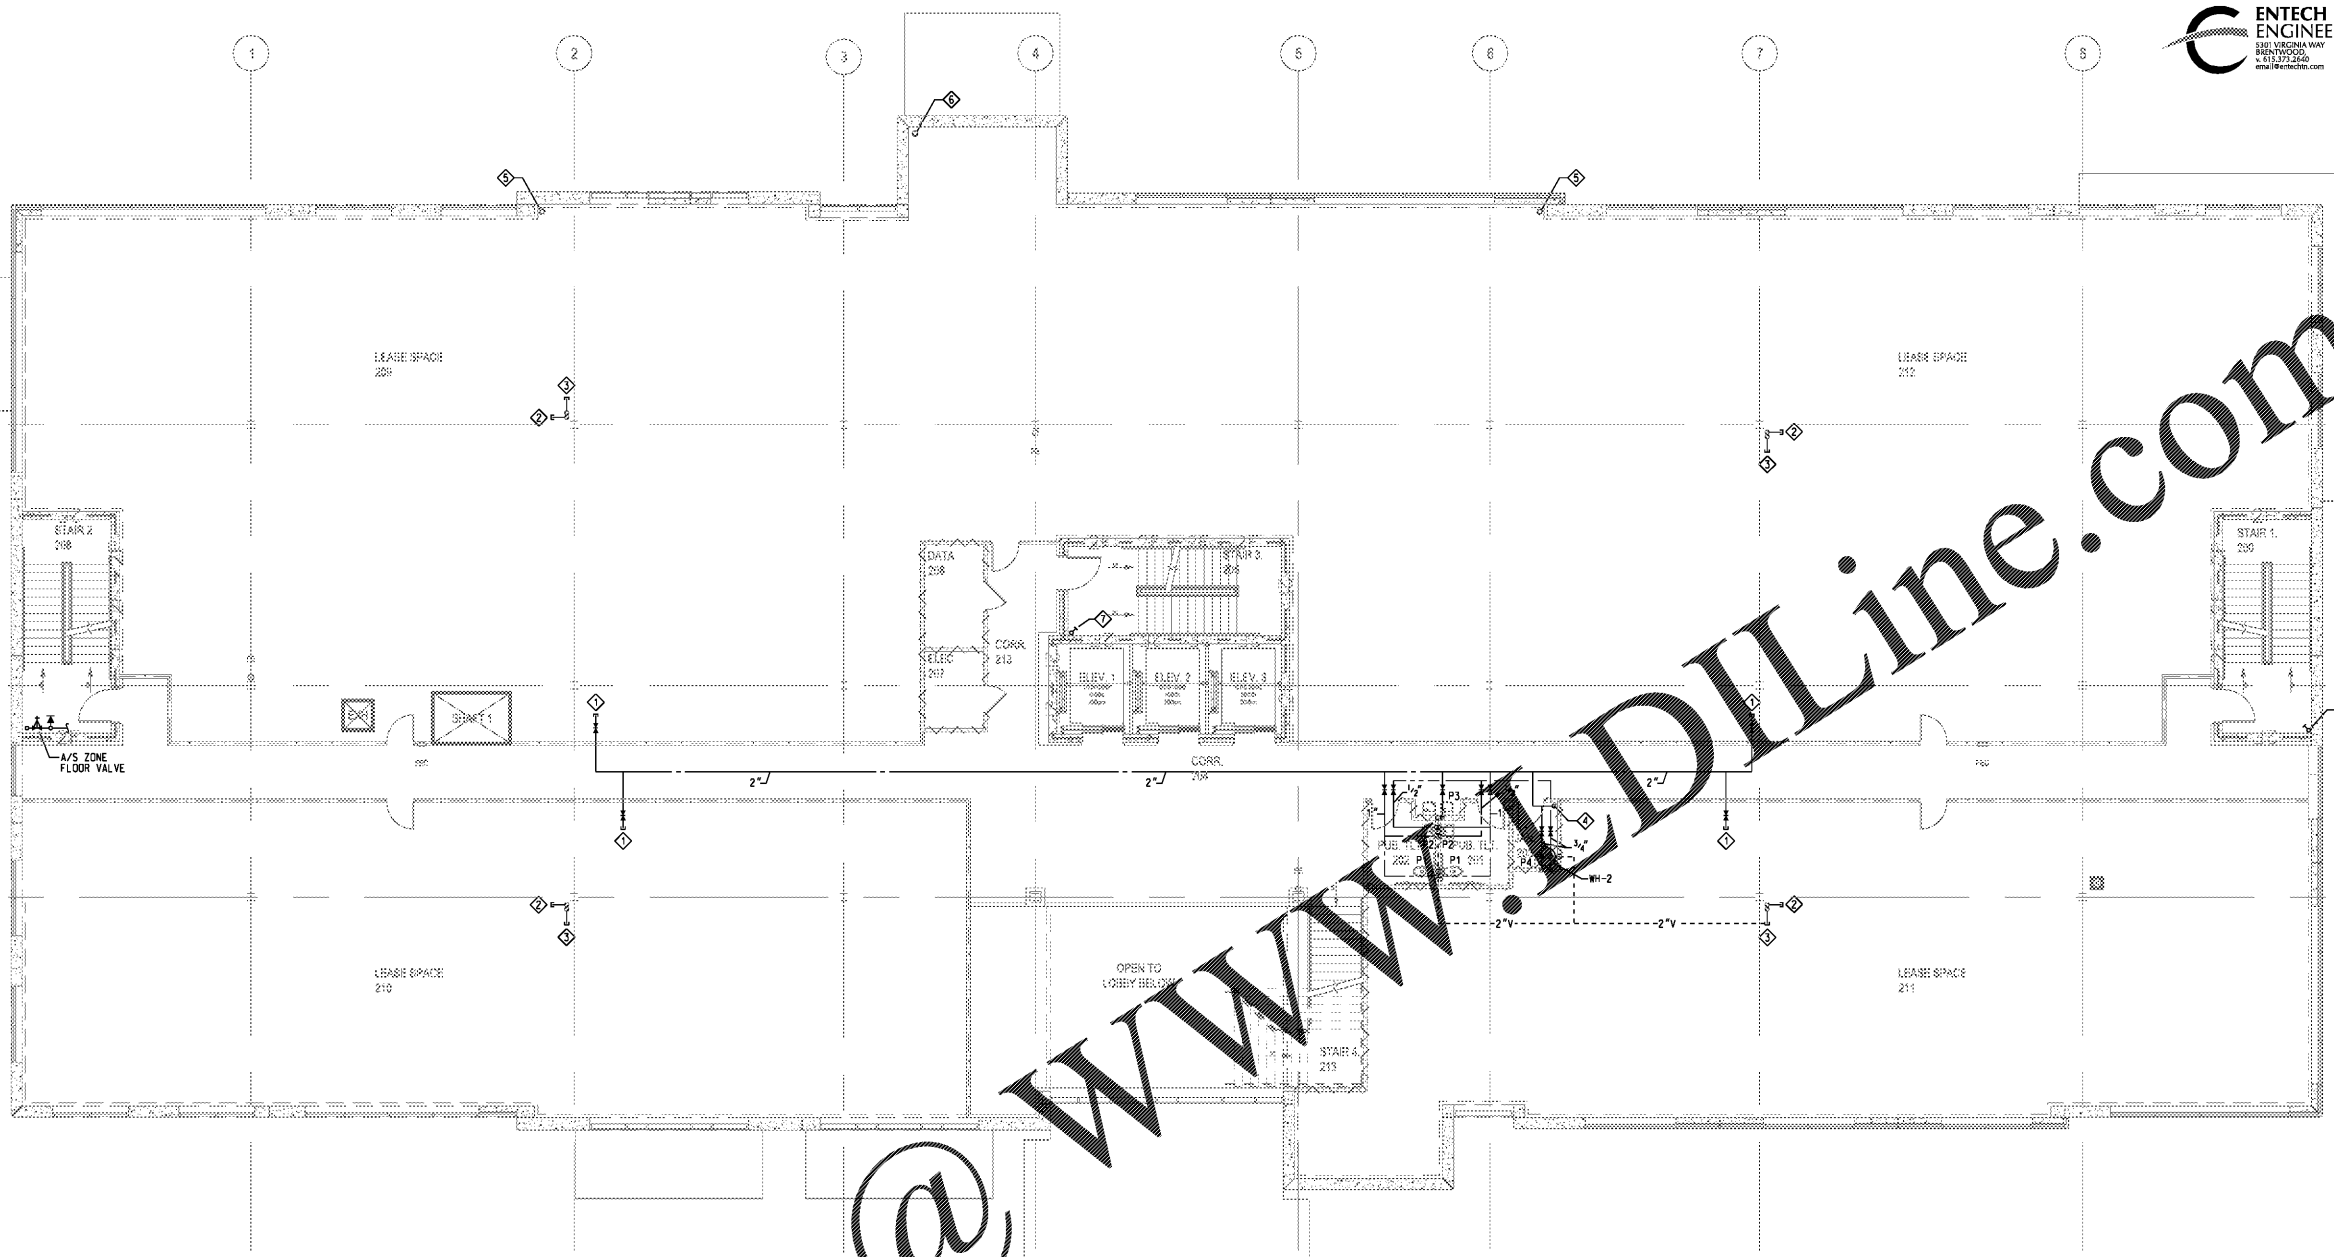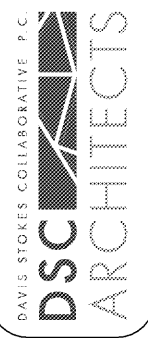

Order Plans @ www.DILine.com

- PLUMBING PLAN NOTES:**
- ◇ VALVE AND CAP 2" DOMESTIC CW FOR FUTURE.
 - ◇ 4" WASTE STACK UP/DOWN.
 - ◇ 4" VENT STACK UP.
 - ◇ 2 1/2" CW FROM BELOW.
 - ◇ 8" RWL UP/DOWN.
 - ◇ 6" RWL UP/DOWN.
 - ◇ STAND PIPE UP/DOWN.

WALL LEGEND	
WALL CONSTRUCTION TYP.	
.....	UNRATED PARTITION TO ABOVE CLG.
-----	LEASE SPACE PARTITION
.....	UNRATED PARTITION TO DECK
.....	SMOKE PARTITION
.....	SMOKE BARRIER
.....	1 HOUR FIRE BARRIER
.....	1 HOUR FIRE - SMOKE BARRIER
.....	2 HOUR FIRE BARRIER
.....	2 HOUR FIRE - SMOKE BARRIER
.....	2 HOUR SHAFT BARRIER

NOTE: 1.) FOR SOUND WALLS SEE DIMENSIONED PLAN.
2.) ALL WALL TYPES MAY NOT BE USED.

PLUMBING
SECOND FLOOR PLAN



REVISIONS	
NO.	DATE

P2.02
ISSUE DATE: 11.12.19
JOB NUMBER: 1902